



F.A. RTE.	SECTION	COUNTY	TOTAL SHEETS	SHEET NO.
80-55 99-1(K, BY&AC-B)		WILL	497	245
STA.	TO STA.			
FED. ROAD DIST. NO.	ILLINOIS	FED. AID PROJECT		
CONTRACT NO. 80906				

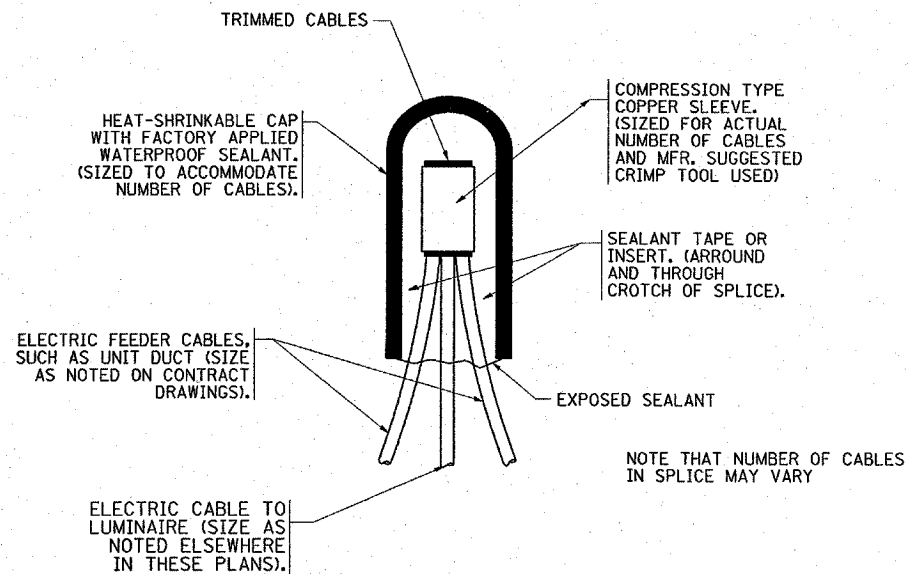


TYPICAL SPLICE DETAIL

N.T.S.

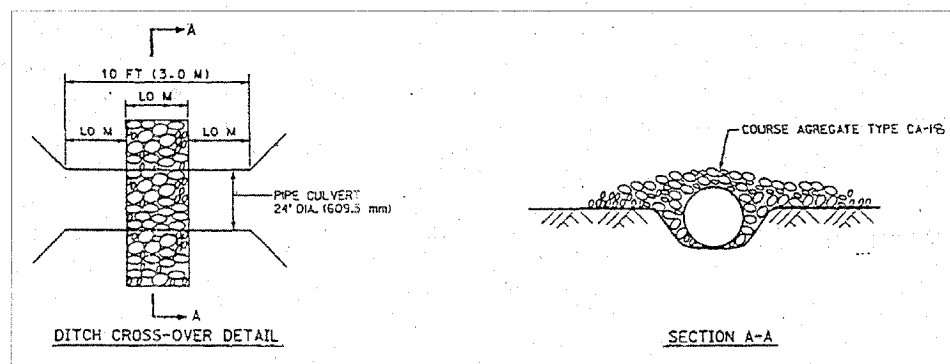


SECTION A-A

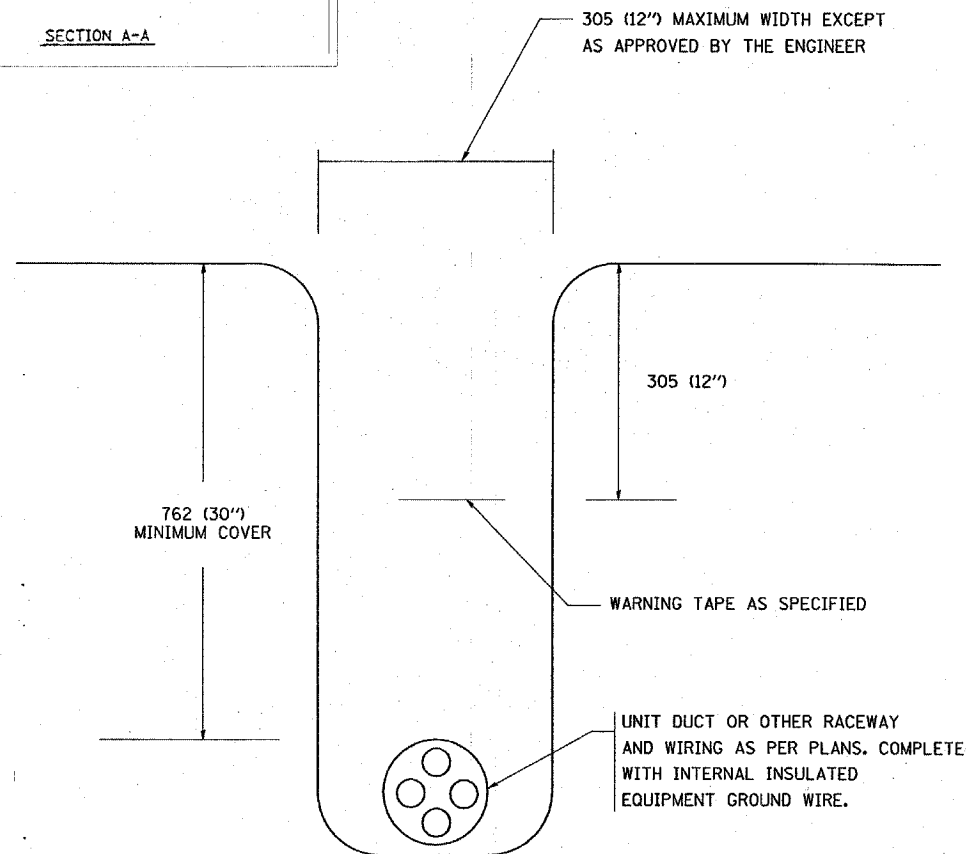

TYPICAL WIRING IN TRENCH DETAIL

N.T.S.

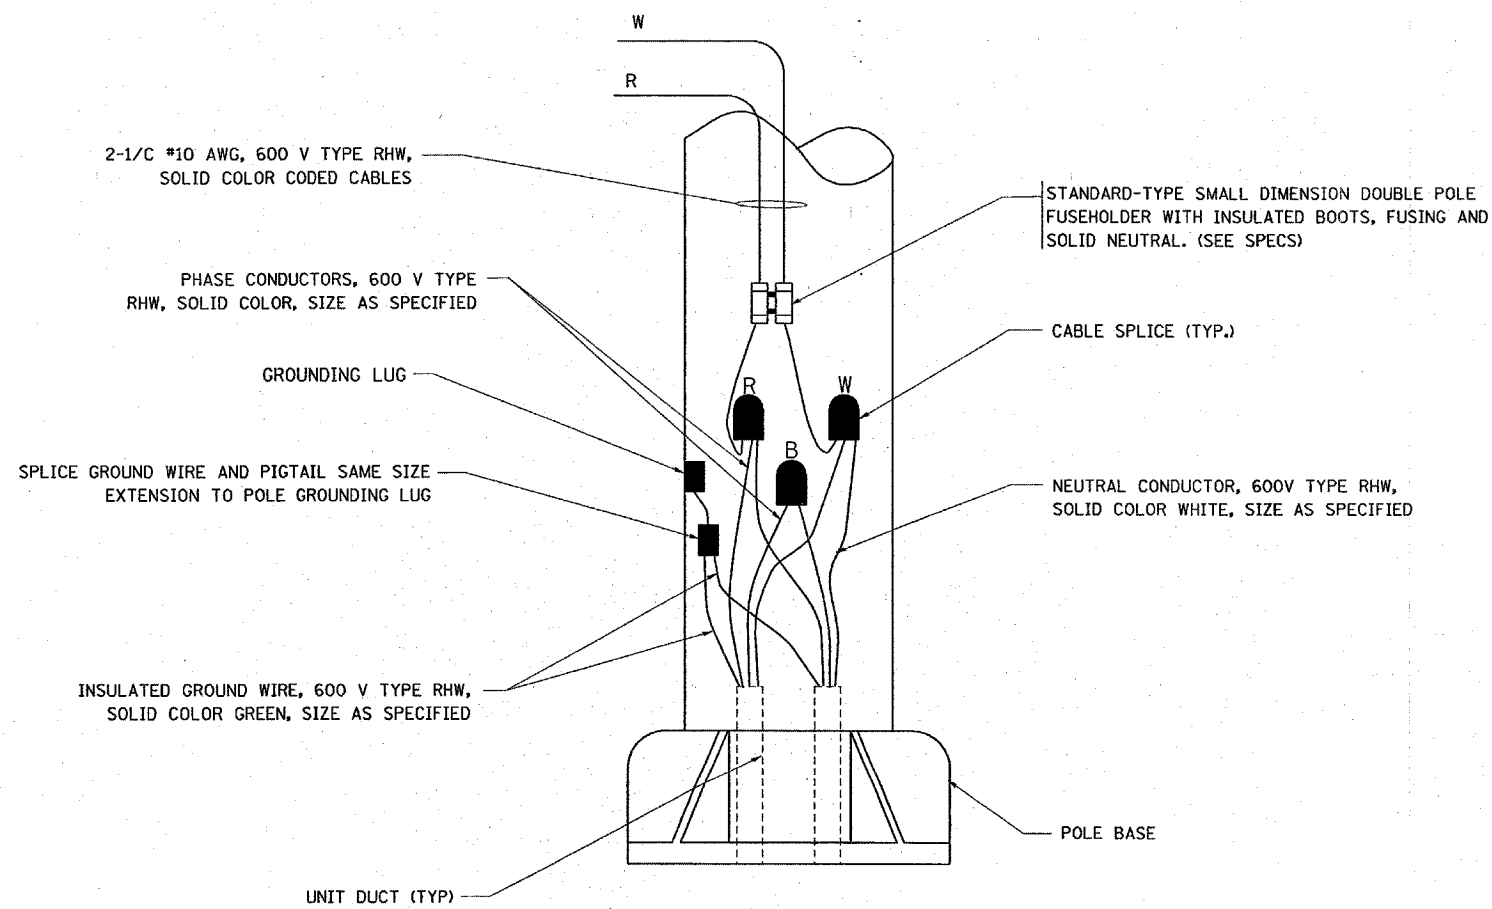

POLE WIRING DETAIL

N.T.S.

REVISIONS	
NAME	DATE

ILLINOIS DEPARTMENT OF TRANSPORTATION

MISC. ELECTRICAL DETAILS  
SHEET A

SCALE: NONE  
DATE 12/10/2004

DRAWN BY  
CHECKED BY

BE-702

REVISION DATE: