




Ckt. #	Description	Phase A (Red) (watts)	Phase B (Black) (watts)
A	0-150W, 0-250W, 7-400W	3360	
B	0-150W, 0-250W, 7-400W		3360
C	0-150W, 0-250W, 7-400W	3360	
D	0-150W, 0-250W, 8-400W		3840
E	0-150W, 0-250W, 1-400W	480	
F	0-150W, 0-250W, 0-400W		0
G	0-150W, 0-250W, 0-400W	0	
H	0-150W, 0-250W, 0-400W		0
Totals:		7200	7200

Ckt. #	Description	Phase A (Red) (watts)	Phase B (Black) (watts)
A	0-150W, 0-250W, 6-400W	2880	
B	0-150W, 0-250W, 5-400W		2400
C	0-150W, 0-250W, 5-400W	2400	
D	0-150W, 0-250W, 4-400W		1920
E	0-150W, 2-250W, 3-400W	2064	
F	0-150W, 2-250W, 4-400W		2544
G	1-150W, 2-250W, 4-400W	2736	
H	1-150W, 2-250W, 4-400W		2736
J	0-150W, 0-250W, 0-400W	0	
K	0-150W, 0-250W, 0-400W		0
Festoons		720	
Totals:		10080	10320

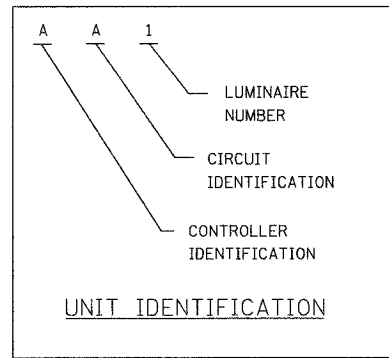

LEGEND:

- (A) 400W HPS LUMINAIRE, 45' M.H.
- (B) 250W HPS LUMINAIRE, 45' M.H.
- (C) 150W HPS LUMINAIRE, 35' M.H.

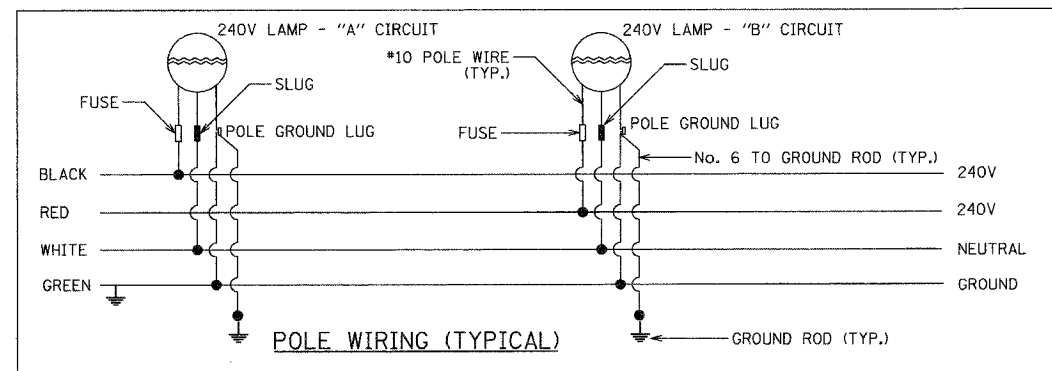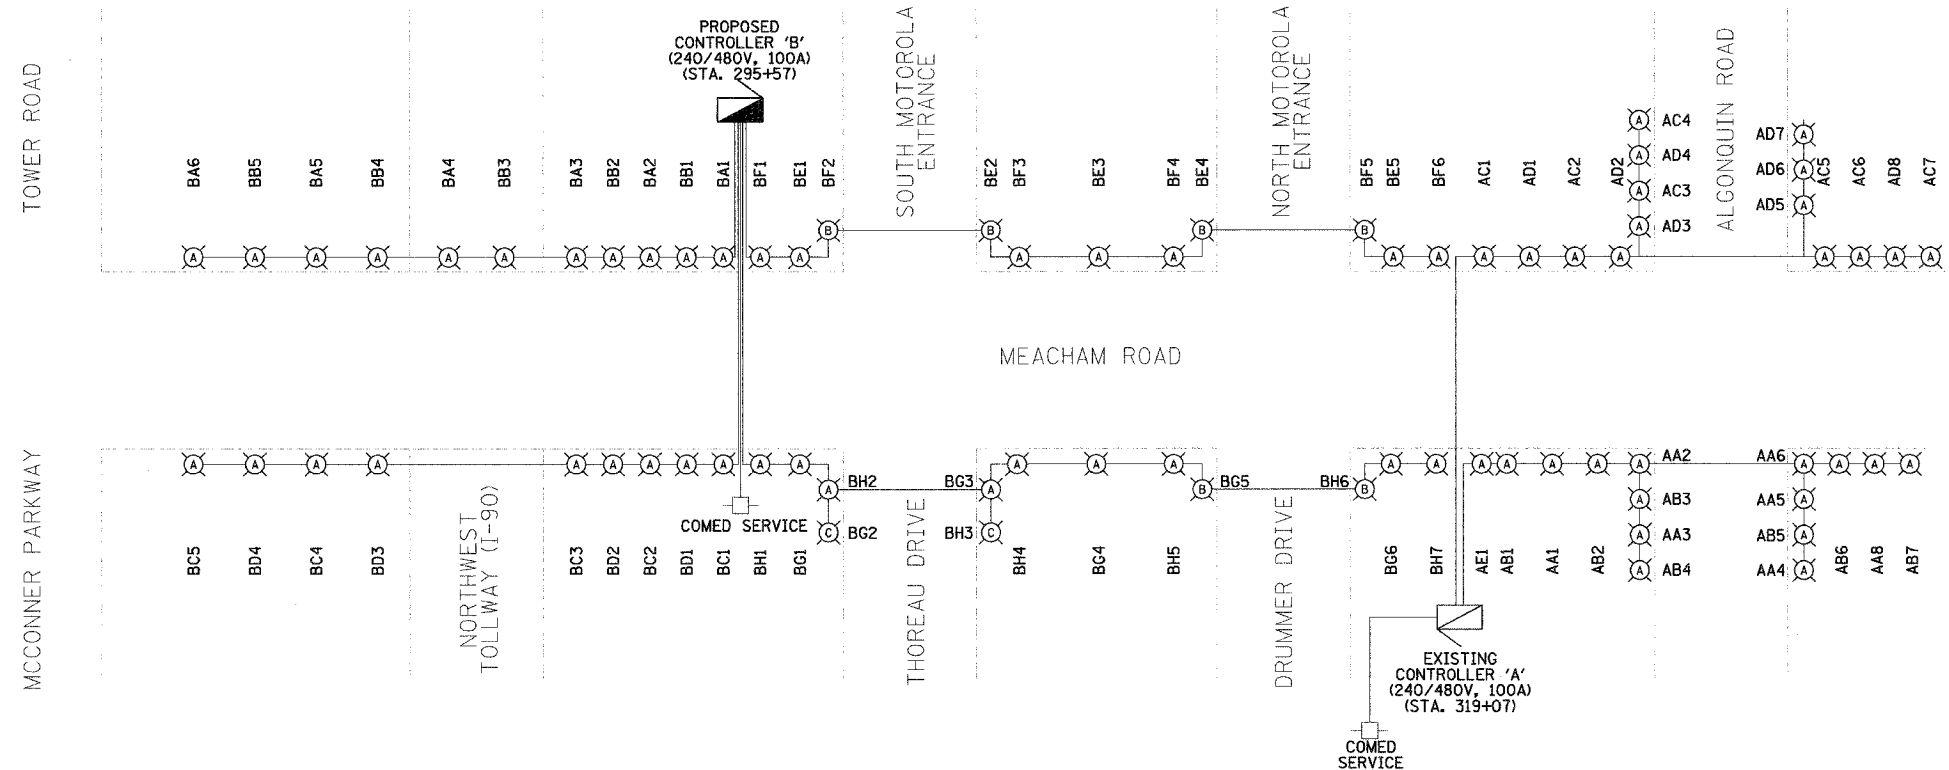

NAME	DATE

MEACHAM ROAD

ILLINOIS DEPARTMENT OF TRANSPORTATION
VILLAGE OF SCHAUMBURG

**MEACHAM ROAD
LIGHTING IMPROVEMENTS
LIGHTING ONE LINE DIAGRAM**

SCALE: NTS
DATE: DECEMBER 2004

DRAWN BY: KDM
CHECKED BY: JMV

m:\p10132826\design\lighting\3286-one line.dgn