


R.I.E.	SECTION	COUNTY	TOTAL SHEETS	SHEET NO.
FAI80	(50-2)HBR	LA SALLE	440	104
	STA. 663+50	TO STA. 676+50		
FED. ROAD DIST. NO.	ILLINOIS	FED. AID PROJECT		

**CONTRACT NO. 86603**

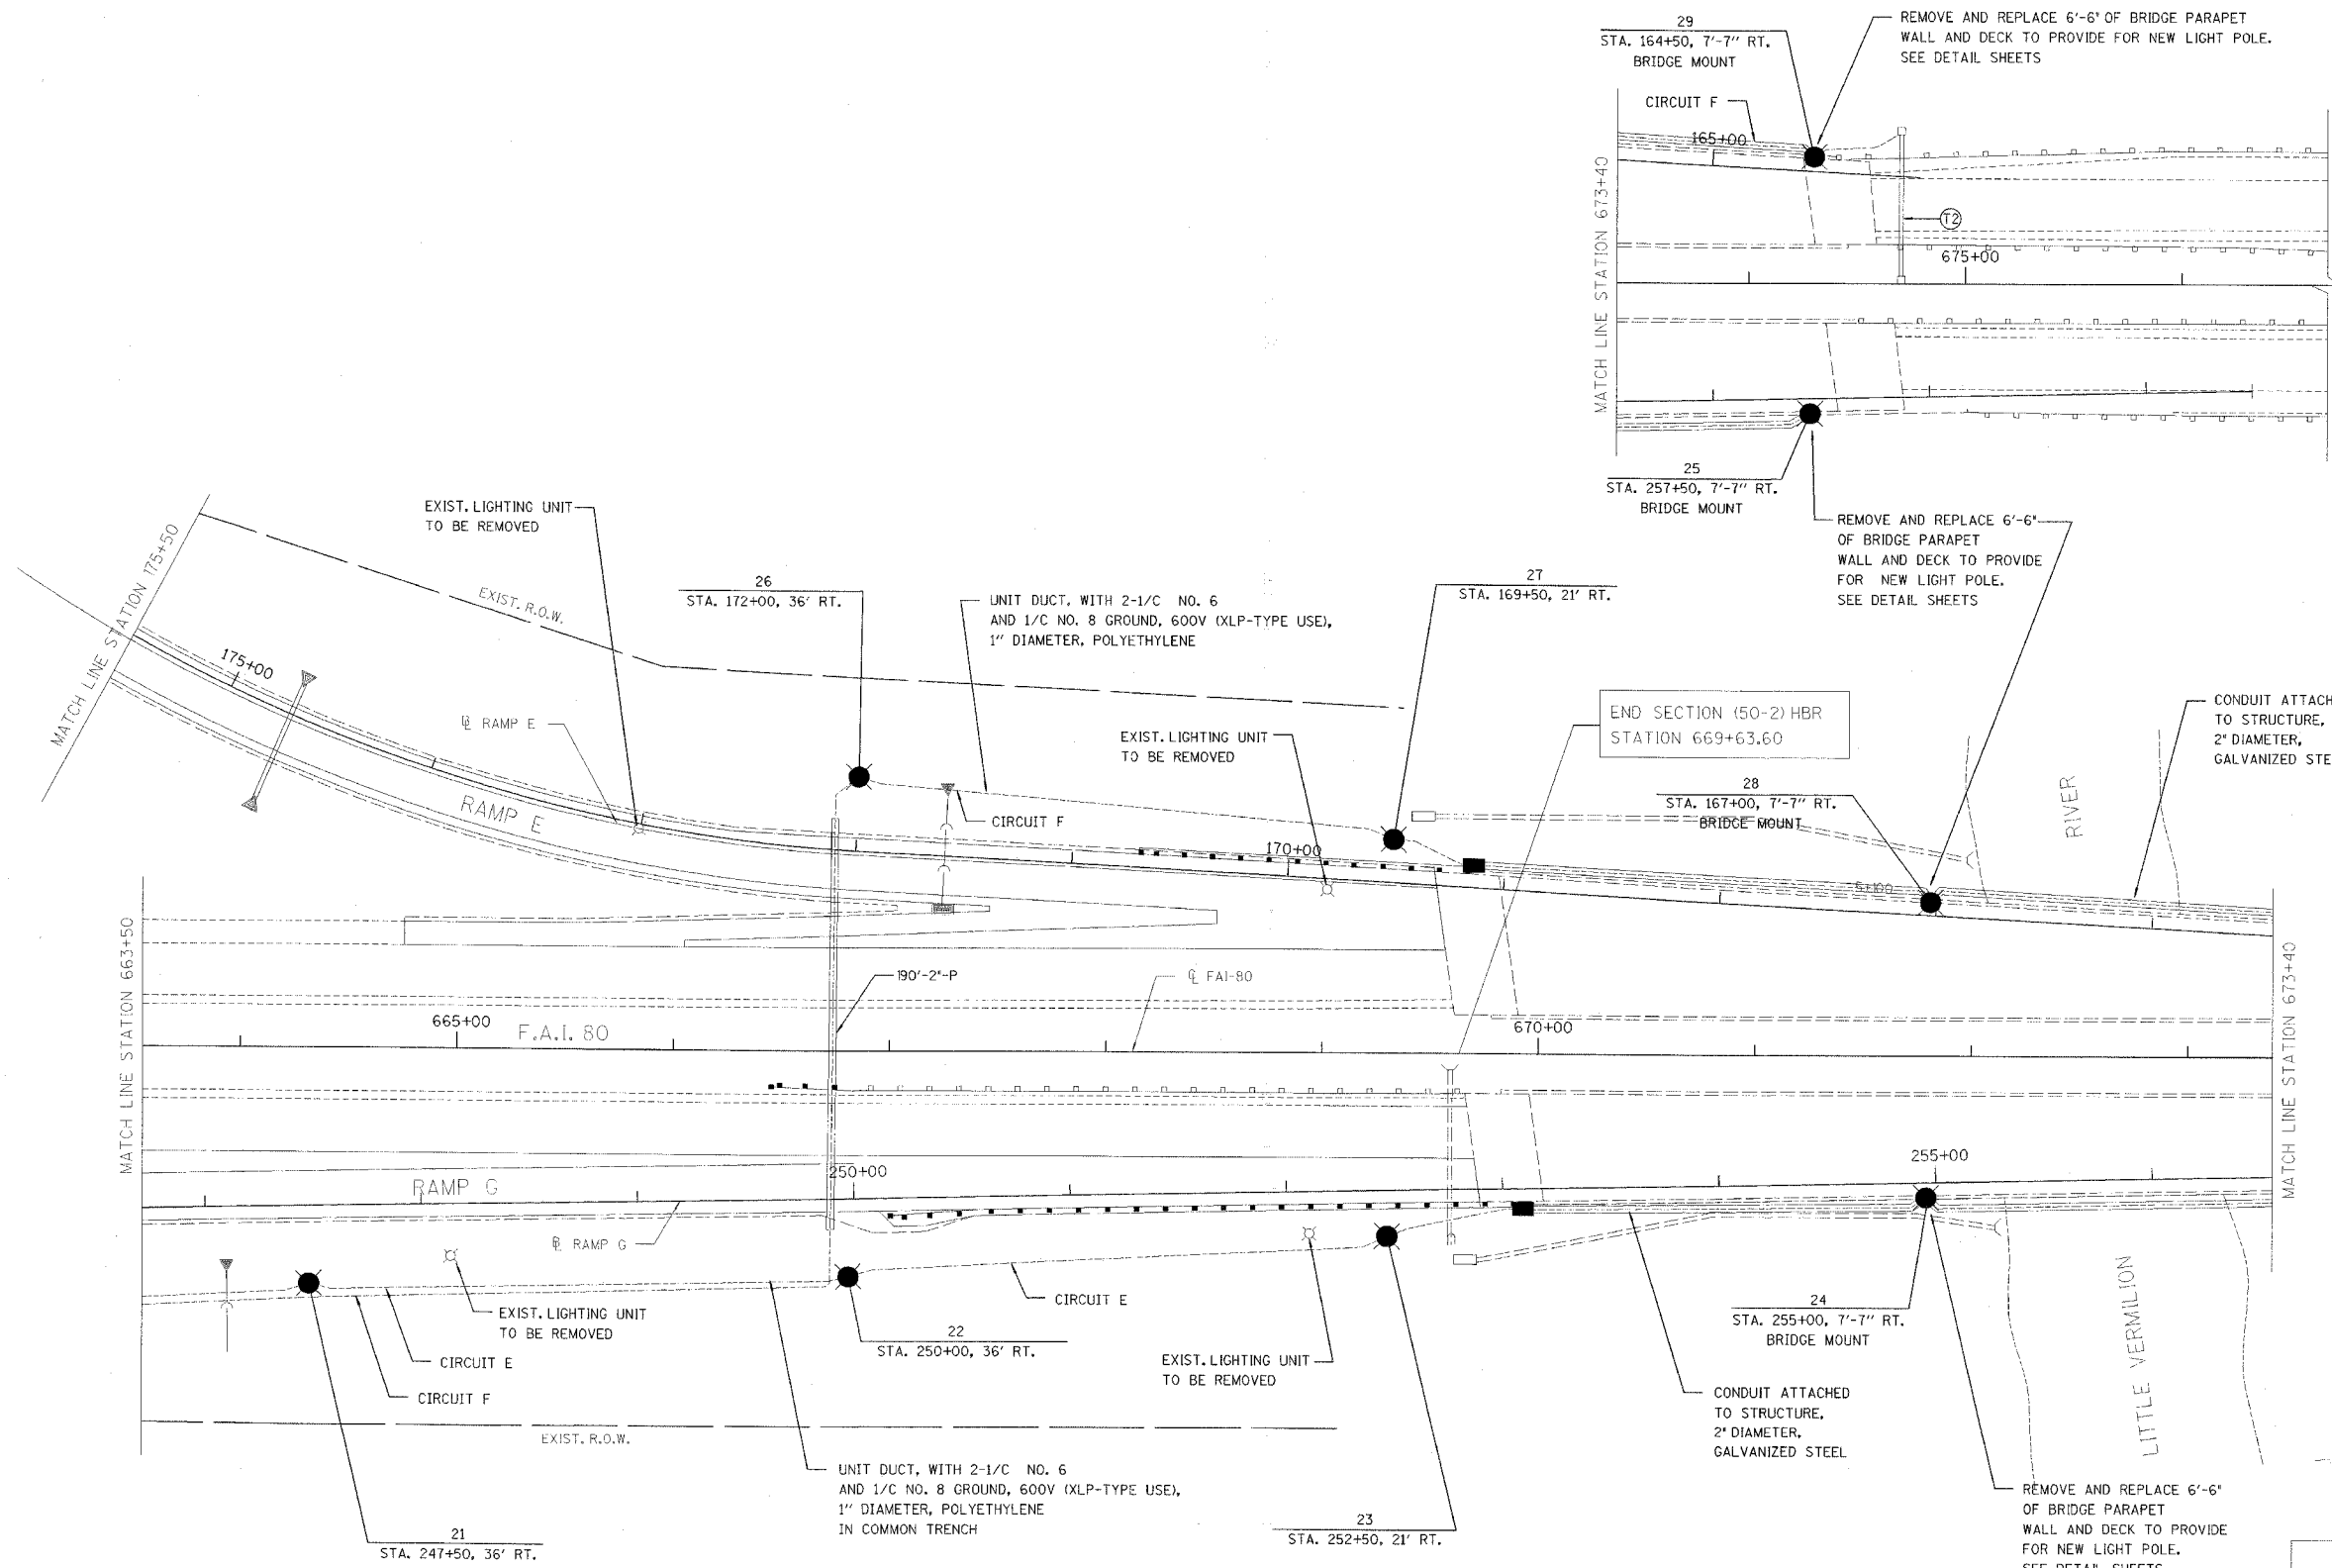

REVISIONS NAME	DATE

ILLINOIS DEPARTMENT OF TRANSPORTATION

**ROADWAY LIGHTING PLAN**

F.A.I. 80 AT ILLINOIS ROUTE 351  
STATION 663+50 TO STATION 676+50

DATE: 09/04  
DRAWN BY: JDK  
CHECKED BY: MTD

0 40 80  
SCALE IN FEET