

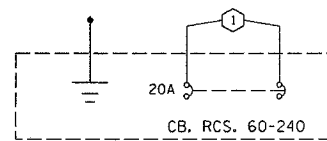


F.A.P. RTE.	SECTION	COUNTY	TOTAL SHEETS	SHEET NO.
774	.	EFFINGHAM	344	117
FED. ROAD DIST. NO. 7 ILLINOIS FED. AID PROJECT				
*107WRS-1, 107BY, 107BY-1 & 107B-2				
CONTRACT NO. 94827				

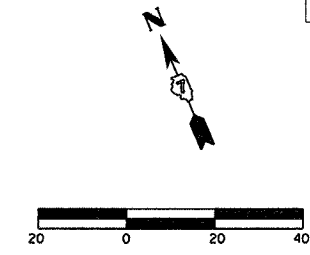

CONTROL ONE LINE

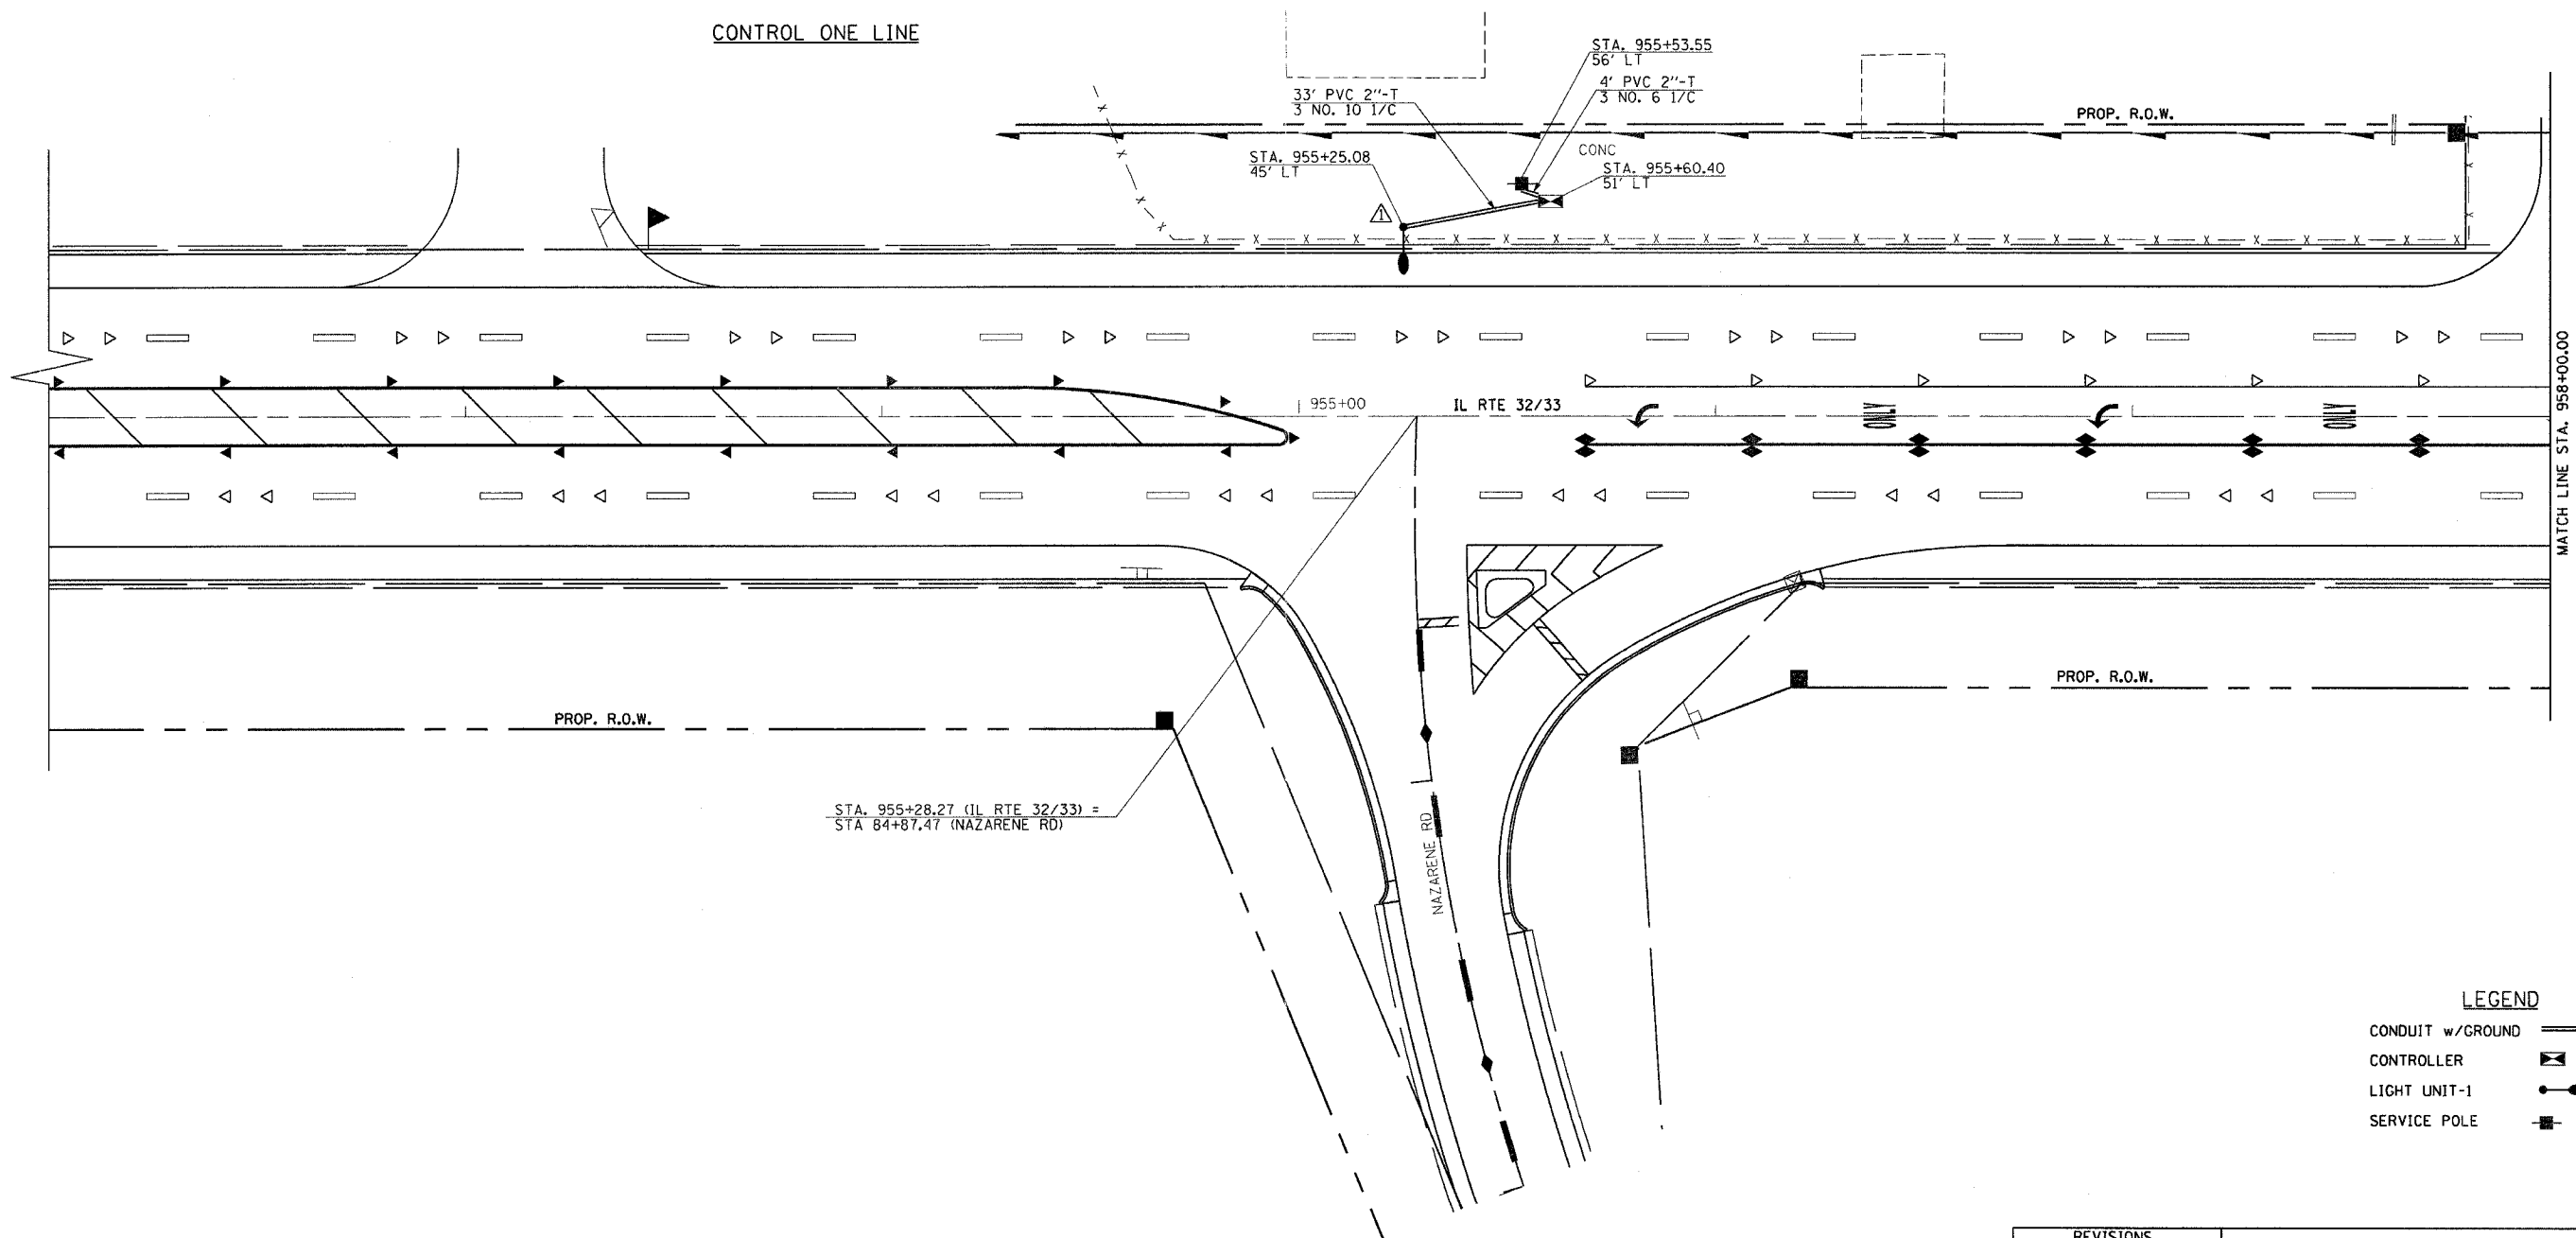

LIGHT/CABLE LAYOUT

LEGEND

CONDUIT w/GROUND	====
CONTROLLER	⊠
LIGHT UNIT-1	●
SERVICE POLE	■

REVISIONS	
NAME	DATE

ILLINOIS DEPARTMENT OF TRANSPORTATION

NAZARENE ROAD  
LIGHTING PLANS  
SHEET 5 OF 8

DATE 8/02

DRAWN BY ASB  
CHECKED BY BWD