


WORK SHOWN ON THIS SHEET IS FOR BID ALTERNATE NO. 2

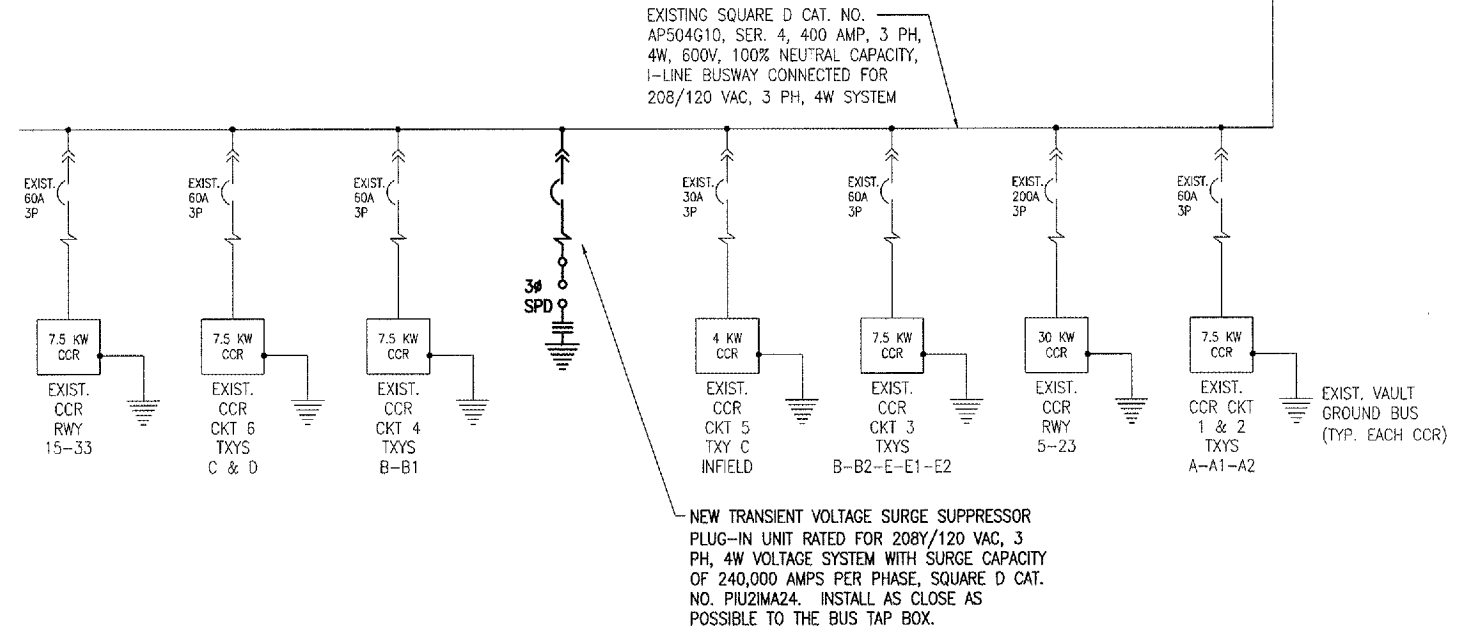

- NOTES
1. ALL WORK AND/OR POWER OUTAGES SHALL BE COORDINATED WITH THE AIRPORT MANAGER AND THE RESIDENT ENGINEER.
  2. CONTRACTOR SHALL FIELD VERIFY EXISTING CONDITIONS & REPORT ANY VARIATIONS TO RESIDENT ENGINEER.
  3. ALL ELECTRICAL EQUIPMENT SHALL BE INSTALLED IN CONFORMANCE WITH NFPA 70 (NEC MOST CURRENT ISSUE IN FORCE), THE RESPECTIVE EQUIPMENT MANUFACTURER'S DIRECTIONS AND AL OTHER APPLICABLE LOCAL CODES, LAWS, ORDINANCES AND REQUIREMENTS IN FORCE. ANY INSTALLATIONS WHICH VOID THE U.L. LISTING, ETL LISTING, (OR OTHER THIRD PARTY LISTING) AND/OR THE MANUFACTURER'S WARRANTY OF A DEVICE SHALL NOT BE PERMITTED.
  4. ALL EQUIPMENT NOT LABELED AS EXISTING IS NEW.
  5. VAULT WORK SHALL BE PAID FOR UNDER ITEM AT109200.
  6. FURNISH & INSTALL A WEATHERPROOF WARNING LABEL FOR EACH METER SOCKET, SERVICE DISCONNECT, PANELBOARD & LOAD CENTER (NEW & EXISTING) TO WARN PERSONS OF POTENTIAL ELECTRIC ARC FLASH HAZARDS, PER THE REQUIREMENTS OF NEC 110.16 "FLASH PROTECTION". LABELS SHALL BE HAZARD COMMUNICATION SYSTEMS, LLC (190 OLD MILFORD RD., P.O. BOX 1174, MILFORD, PA 18337 PHONE: 1-877-748-0244) PART NO. H6010-9VWHBJ OR APPROVED EQUAL.

VAULT ELECTRICAL ONE LINE DIAGRAM WITH NEW SURGE PROTECTION WORK

BY	
REVISION	
DATE	

MT. VERNON AIRPORT  
  
 MT. VERNON, ILLINOIS  
 A.I.P. PROJ.: 3-17-00XX-XX  
 I.L. PROJ.: MN-XXXX

819-05RW0D-0800	12/13/04
E-607.DWG	12/13/04
Scale: NONE	01/14/05
Drawn: KNL	Checked: CAH
Reviewed: MW	

**HANSON**  
 Hanson Professional Services Inc.  
 1528 South Sixth Street  
 Springfield, Illinois 62703-2888  
 Offices Nationwide

REHABILITATE RUNWAY 5-23  
 VAULT ELECTRICAL ONE LINE DIAGRAM WITH NEW SURGE PROTECTION WORK

JAN 31, 2005 11:29 AM BAK  
 I:\AIRPORTS\MTVERNON\B19-05RWY\DESIGN\SHEETS\E-607.DWG - Work-FLR