
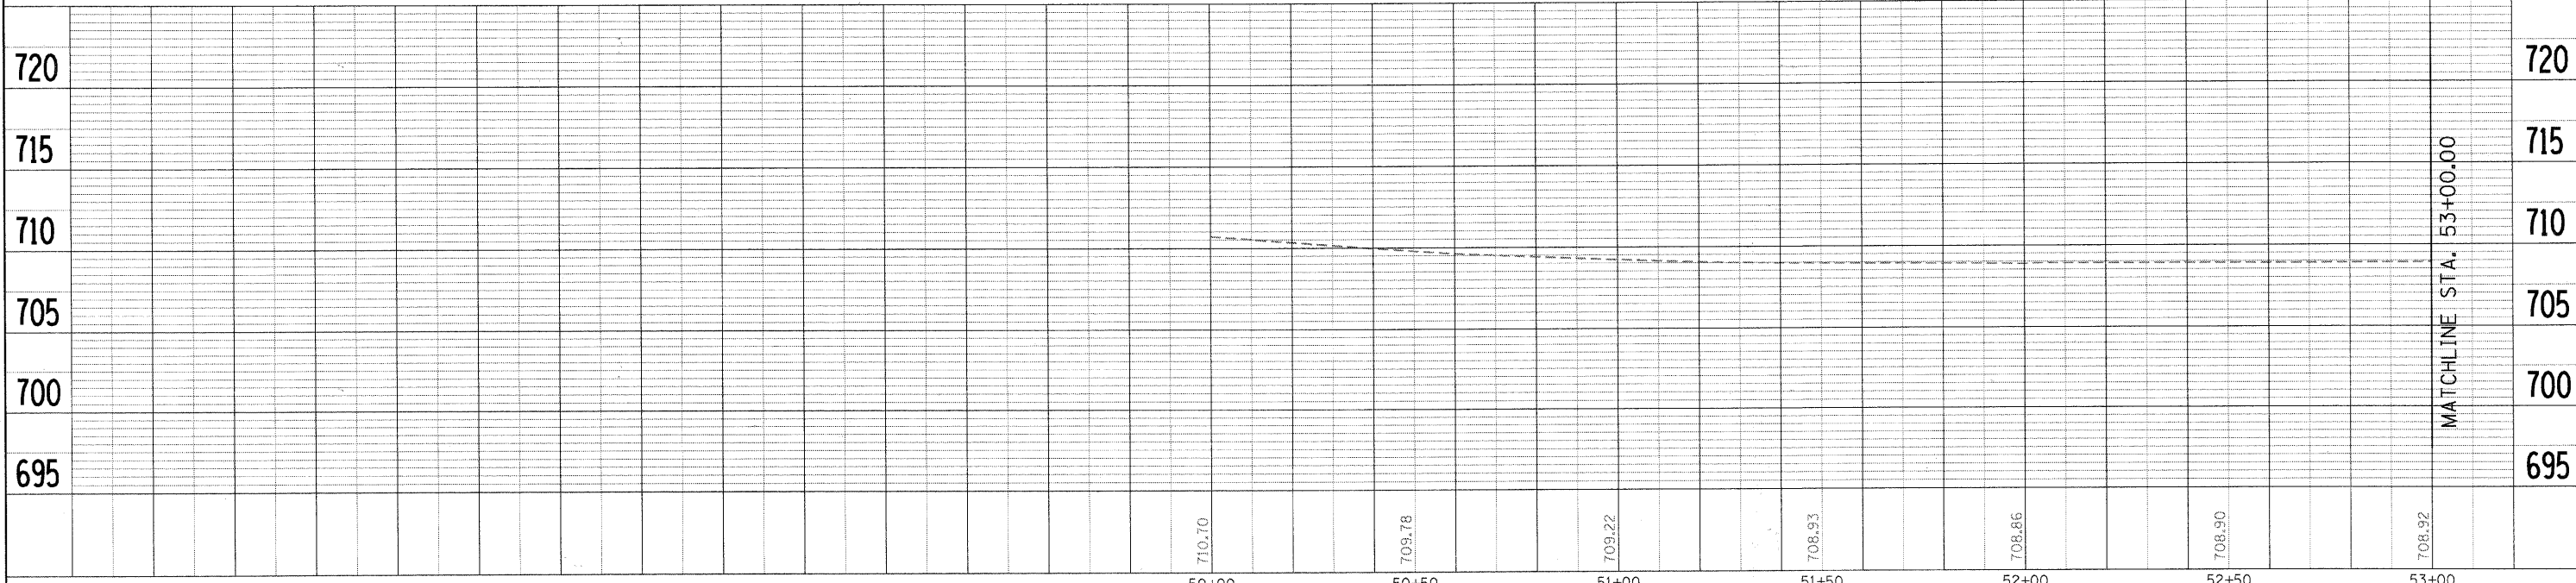
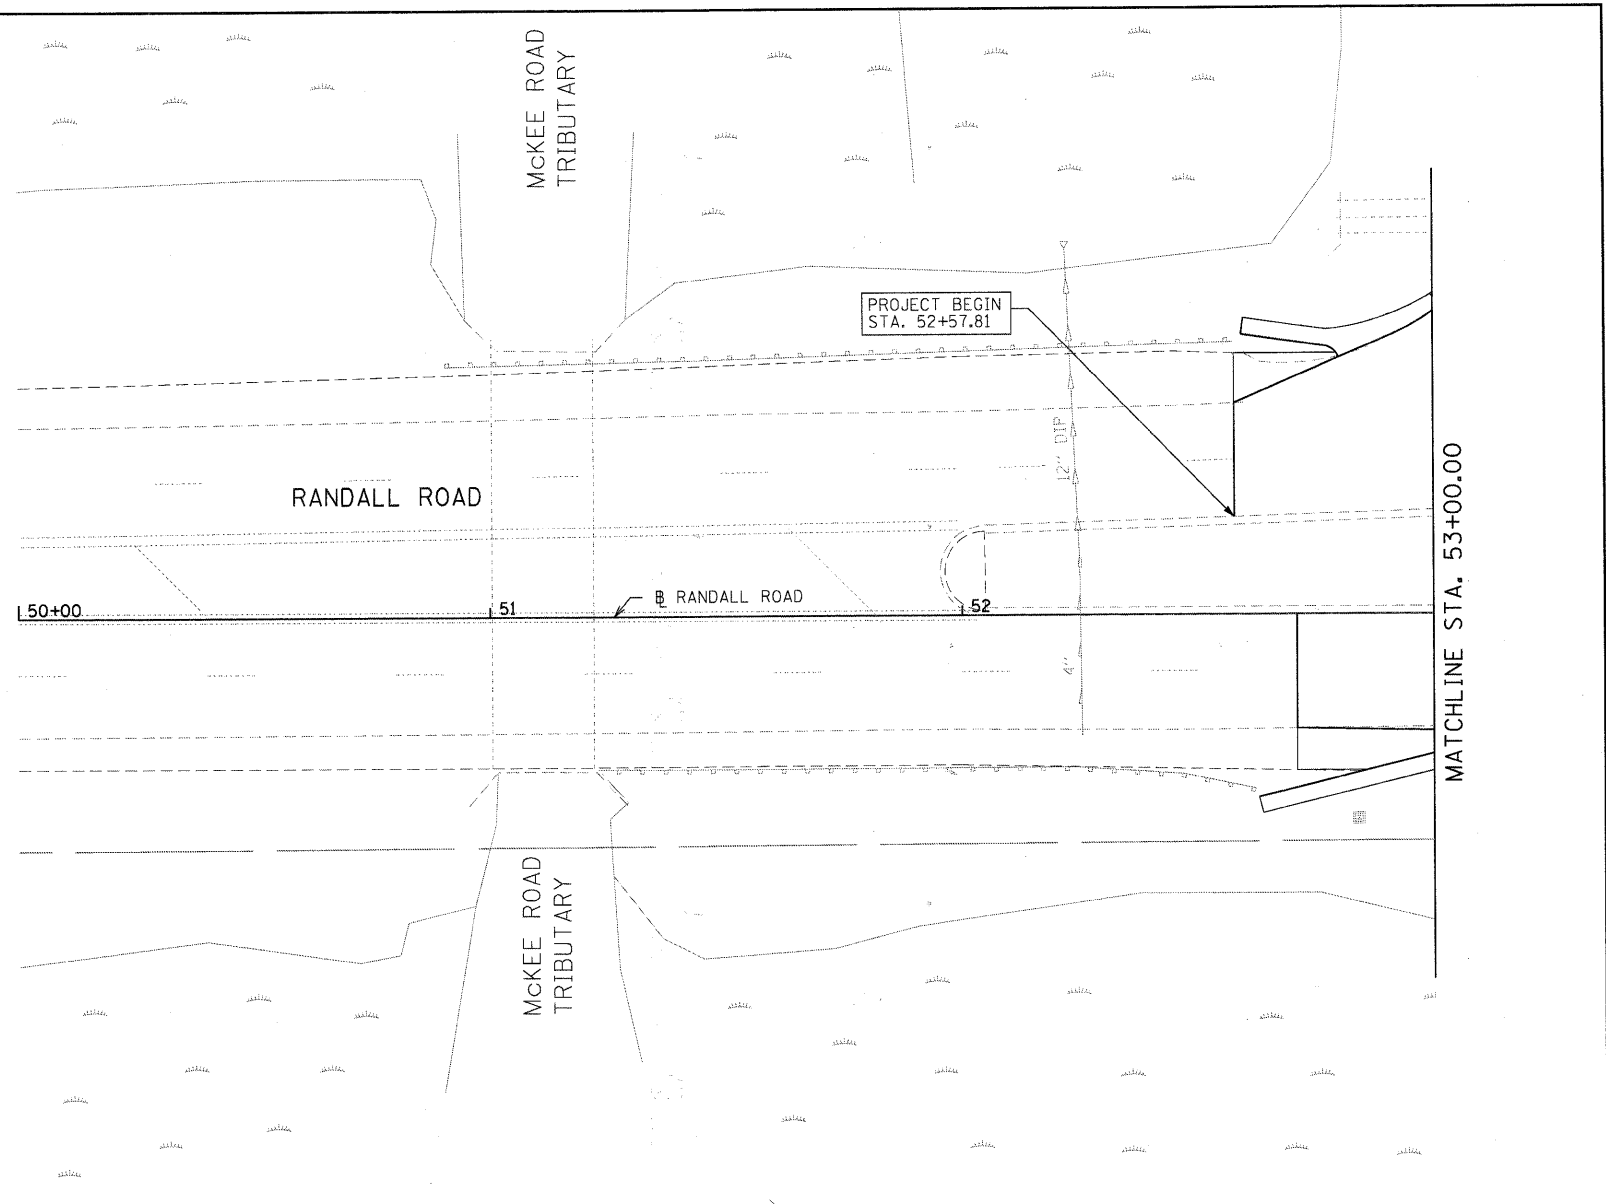


PLAN	REVISIONS	DATE
NO.	NO.	NO.
CHECKED	CHECKED	CHECKED
DATE	DATE	DATE
BY	BY	BY
DATE	DATE	DATE

PROFILE	REVISIONS	DATE
NO.	NO.	NO.
CHECKED	CHECKED	CHECKED
DATE	DATE	DATE
BY	BY	BY
DATE	DATE	DATE

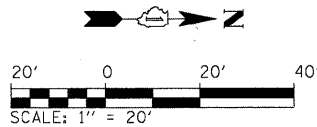

FILE NAME = J:\kennecott\0923603_dr\04\cadd\sheet\RR_DR_01.dgn
 CMT
 CRAWFORD, MURPHY & TILLY, INC.
 CONSULTING ENGINEERS
 License No. 084-000813

	USER NAME = Matt Baldwin DESIGNED - PWK DRAWN - ERD CHECKED - KDF PLOT DATE = 12/29/2010	REVISED - REVISED - REVISED - REVISED -	STATE OF ILLINOIS DEPARTMENT OF TRANSPORTATION	DRAINAGE AND UTILITY PLAN	F.A.P. RTE. 336 SECTION 01-00269-00-CH COUNTY KANE TOTAL SHEETS 124 SHEET NO. 44	CONTRACT NO. 63533 ILLINOIS FED. AID PROJECT
	PLOT SCALE = 20.0000' / 1" IN. DATE = 12/29/2010	SCALE: 20'H 5'V SHEET NO. 1 OF 6 SHEETS STA. 50+00.00 TO STA. 53+00.00				