


F.A.I. RTE.	SECTION	COUNTY	TOTAL SHEETS	SHEET NO.
57	2122-B	COOK	75	20
STA. - - - - -		TO STA. - - - - -		
FED. ROAD DIST. NO.	ILLINOIS	FED. AID PROJECT		CONTRACT NO. 60366

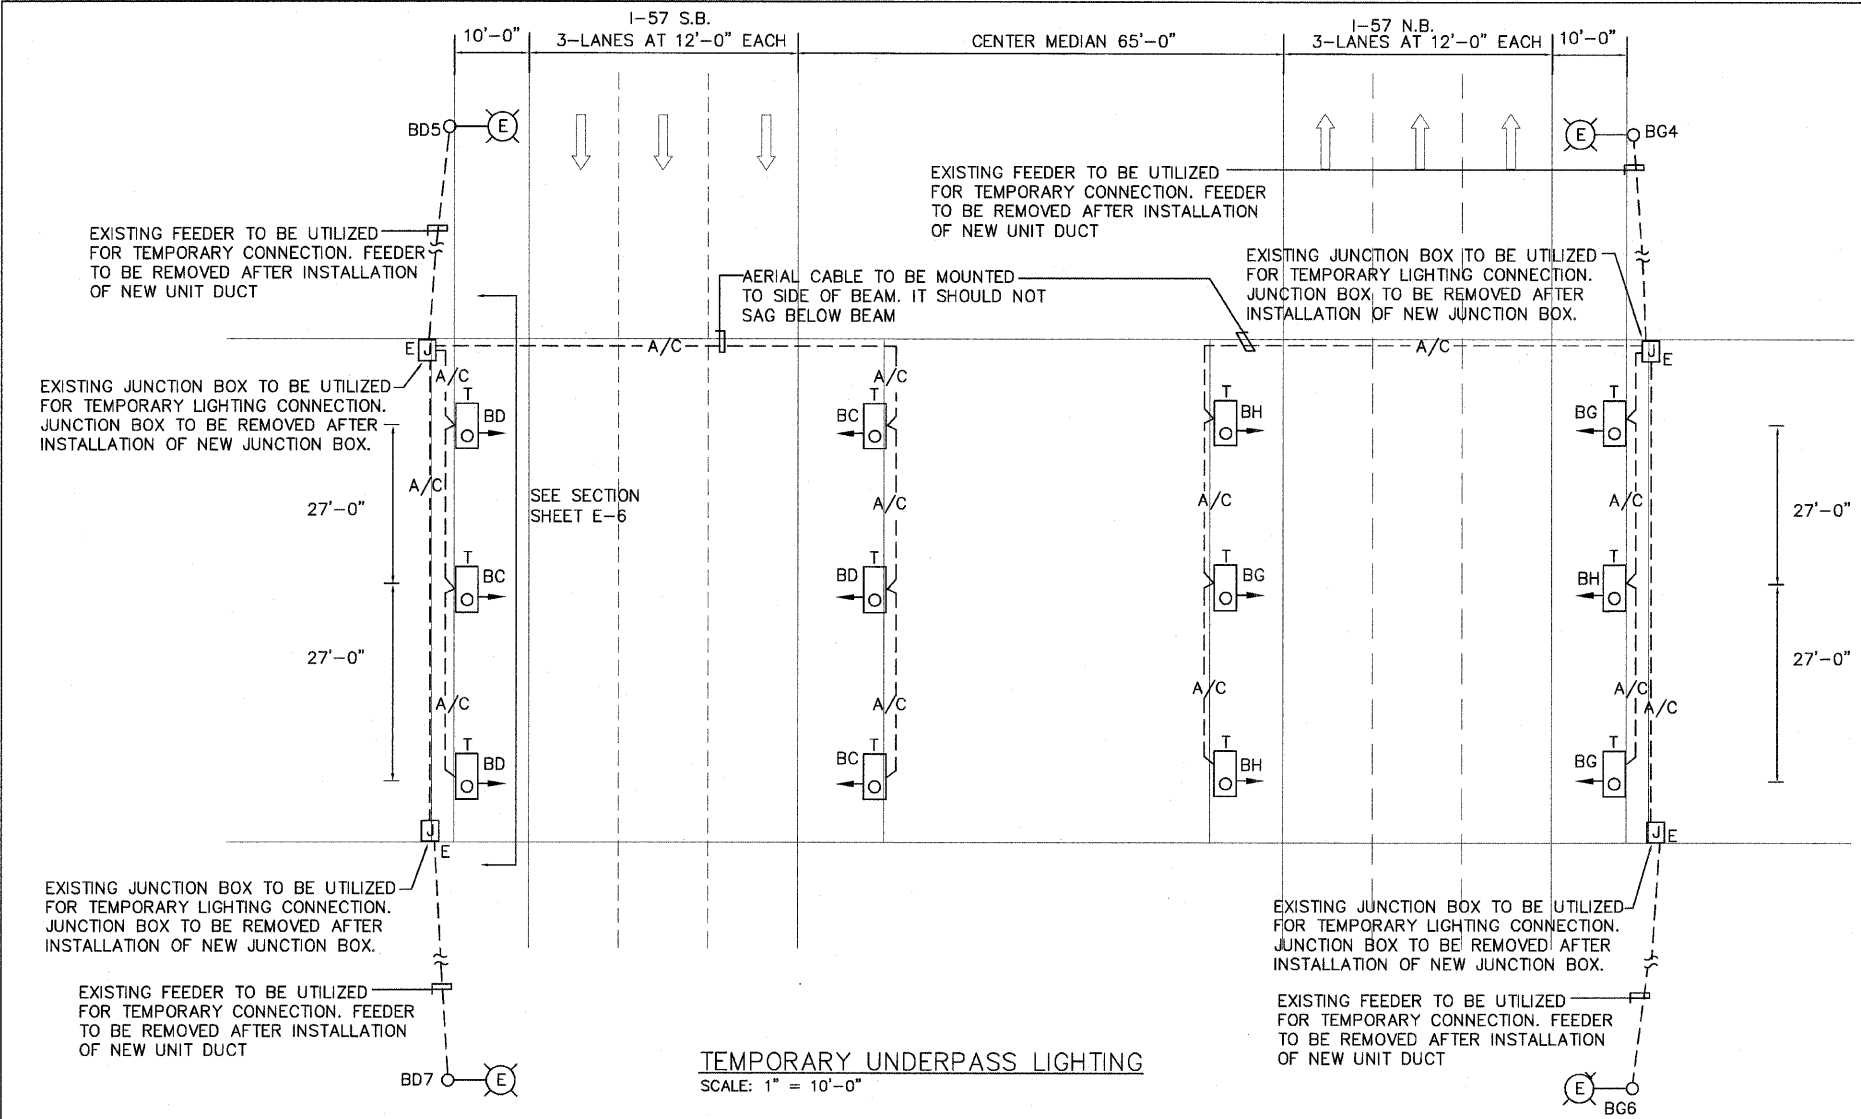


TEMPORARY UNDERPASS LIGHTING
SCALE: 1" = 10'-0"

LEGEND

- A/C --- TEMPORARY AERIAL CABLE 3-1/8" NO. 2, ALUMINUM, WITH MESSENGER WIRE
- [O] E R EXISTING UNDERPASS LUMINAIRE TO BE REMOVED
- [O] T TEMPORARY UNDERPASS LUMINAIRE, 70W HPS, WALL MOUNTED 15'-0" FROM GRADE
- [E] O EXISTING LIGHTING UNIT AND POLE TO REMAIN, CIRCUIT NUMBER AS NOTED.
- [J] E JUNCTION BOX ATTACHED TO STRUCTURE


BG6
 LIGHTING UNIT NUMBER
 CIRCUIT NAME
 LIGHTING CONTROLLER NAME

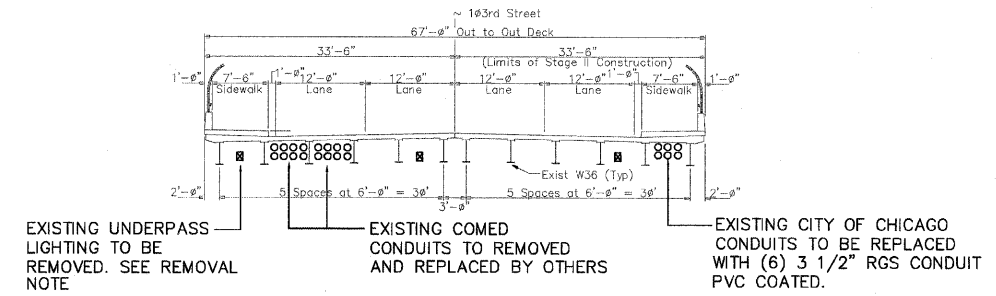

REMOVAL LIGHTING SECTION
SCALE: 1" = 10'-0" (LOOKING WEST)

SEQUENCE OF TEMPORARY AND REMOVAL NOTES:


1. INSTALL TEMPORARY LIGHTING LUMINAIRES WITH ALL ASSOCIATED AERIAL CABLES AND SUPPORT AS REQUIRED FOR OPERATION. ENSURE FULL FUNCTIONAL OPERATION.
2. REMOVE EXISTING UNDERPASS LIGHTING UNITS INCLUDING ALL ASSOCIATED CONDUITS, WIRING, JUNCTION BOXES AND ALL ASSOCIATED EQUIPMENT PART OF REMOVAL WORK.
3. INSTALL NEW UNDERPASS LIGHTING AS INDICATED ON SHEET E-3.
4. REMOVE TEMPORARY UNDERPASS LIGHTING AND ALL ASSOCIATED WIRING, JUNCTION BOXES, ETC. PART OF THE TEMPORARY LIGHTING WORK.
5. COMPONENTS OTHER THAN 70W HPS TEMPORARY UNDERPASS LUMINAIRES COMPRISING THE TEMPORARY LIGHTING SHALL BECOME THE PROPERTY OF THE CONTRACTOR AND SHALL BE REMOVED FROM THE LIMITS OF THE PROJECT. THE CONTRACTOR SHALL PACK THE 70W HPS UNDERPASS LUMINAIRES INTO ORIGINAL BOXES AND RETURN THEM TO THE STATE STOCK.

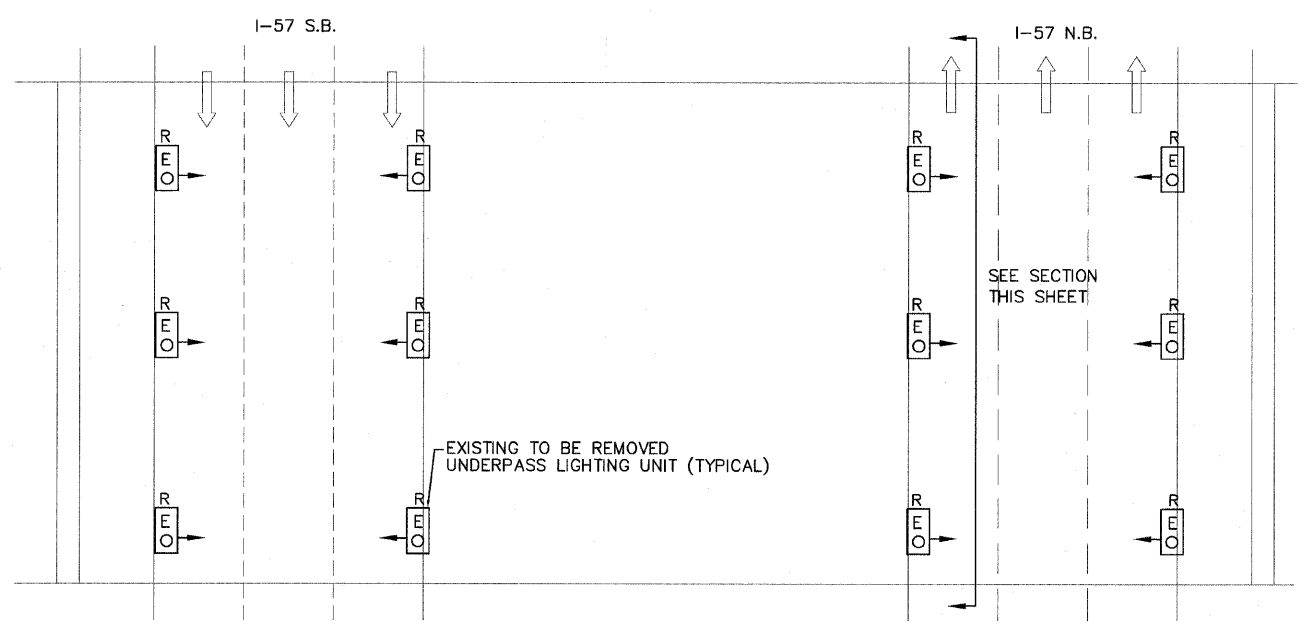

REMOVAL OF EXISTING UNDERPASS LIGHTING PLAN
SCALE: 1" = 10'-0"

Advance
Consulting Group International

 300 W. ADAMS ST.
SUITE 400
CHICAGO, IL 60606
TEL: 312-357-1940
FAX: 312-357-1945
Web Site: www.angrid.com



REVISIONS	
NAME	DATE

ILLINOIS DEPARTMENT OF TRANSPORTATION

103RD STREET
BRIDGE OVER FAI 57 (DAN RYAN)
UNDERPASS TEMPORARY AND REMOVAL LIGHTING PLAN

DRAWN BY EHE
CHECKED BY EE

DATE 01-16-08