


F.A.I. RTE.	SECTION	COUNTY	TOTAL SHEETS	SHEET NO.
57	1919.2B	COOK	119	51
STA.		TO STA.		
FED. ROAD DIST. NO.		ILLINOIS FED. AID PROJECT		

CONTRACT #60371

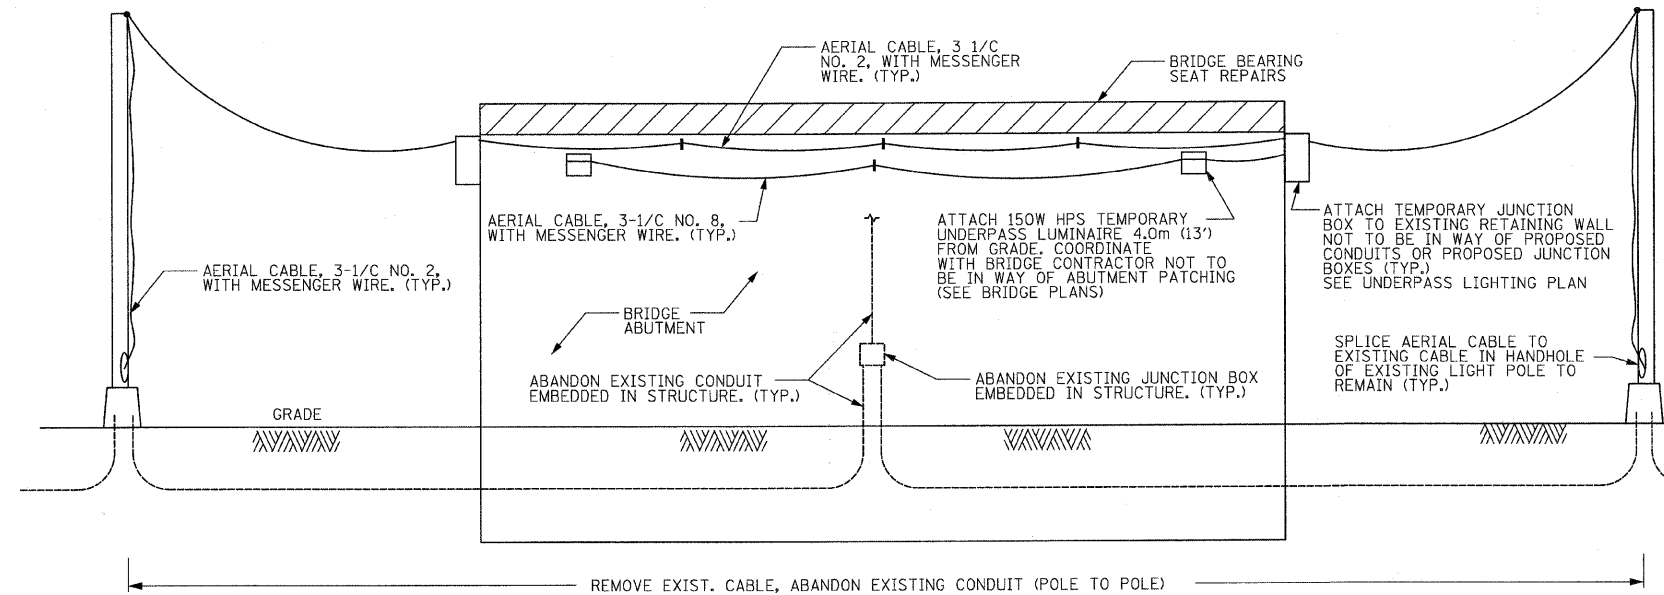

TEMPORARY UNDERPASS LIGHTING DETAIL (ELEVATION)

CONSTRUCTION NOTES:

1. SEE LIGHTING PLAN FOR LUMINAIRE SPACING.
2. CONTRACTOR SHALL COORDINATE WITH BRIDGE CONTRACTOR TO ESTABLISH MOUNTING HEIGHT OF LUMINAIRES TO ALLOW SUFFICIENT CLEARANCE FOR REPAIRS TO BRIDGE BEARING SEAT. CONTRACTOR SHALL NOT LOCATE TEMPORARY LUMINAIRES IN AREA OF SPALLED OR DELAMINATED CONCRETE AS SHOWN ON PLANS. SEE BRIDGE PLANS FOR DETAIL.
3. CONTRACTOR SHALL GROUT ANY HOLES IN "FINISHED" CONCRETE THAT WERE USED TO ATTACH TEMPORARY UNDERPASS LUMINAIRES. THIS WORK SHALL BE INCIDENTAL TO TEMPORARY UNDERPASS LIGHTING INSTALLATION AND REMOVAL.
4. ADDITIONAL WOOD POLES MAY BE NEEDED TO FACILITATE SPAN OF AERIAL WIRE.
5. INSTALLATION DETAILS FOR CENTER PIER MOUNTED LUMINAIRES ARE SIMILAR. SEE TEMPORARY UNDERPASS LIGHTING PLAN.
6. THE EXISTING LIGHTING CONTROLLER "D" POWERING THE UNDERPASS LUMINAIRES IS LOCATED ALONG I-57, NORTH EAST OF THE 115TH STREET BRIDGE.

REVISIONS	
NAME	DATE

ILLINOIS DEPARTMENT OF TRANSPORTATION
115th STREET OVER I-57
UNDERPASS LIGHTING DETAILS &
SECTIONS 115TH STREET BRIDGE

SCALE: NTS
DATE: 01-16-09

DRAWN BY: VG
CHECKED BY: PV

SINGH SINGH & ASSOCIATES, INC.
CONSULTING ENGINEERS