


**TEMPORARY WIRING NOTES:**

1. SECURE AERIAL CABLE ATTACHMENTS TO POLE WITH POLE BANDS AT A HEIGHT THAT WILL PROVIDE THE REQUIRED 18 FOOT NATIONAL ELECTRICAL CODE CONDUCTOR CLEARANCE OVER THE ROADWAY. REFER TO DETAIL 2, SHEET LT-09.
2. INSERT CIRCUIT CONDUCTORS THROUGH POLE CAP. SPLICE CONDUCTORS TO THE LIGHTING CIRCUITS AT THE POLE BASE. REFER TO DETAIL 3, SHEET LT-09. REPLACE POLE CAP AFTER TEMPORARY CONDUCTORS ARE REMOVED.
3. CIRCUIT IDENTIFICATION IS ASSUMED AND IS PROVIDED FOR CLARIFICATION OF CIRCUIT ROUTING ONLY.
4. LOCATIONS SHOWN FOR ComEd OVERHEAD LINES ARE APPROXIMATE. CONTRACTOR SHALL VERIFY LOCATIONS AND CLEARANCE.

NOTES 1,2  
REFER TO SHEET LT-09  
DETAIL 3 (TYPICAL)

NOTE 1  
REFER TO SHEET LT-09  
DETAIL 2 (TYPICAL)

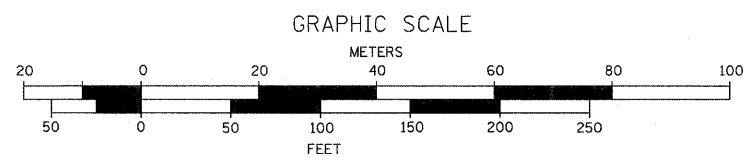

LT-04

FILE NAME = LT-04.dgn PLOT DATE = 1/26/2009	 SPAAN Tech, Inc. <small>311 S. Wacker Drive, Suite 2400 Chicago, Illinois 60606 phone: 312.277.8800 fax: 312.277.8808 web: www.spaanTech.com</small>	DESIGNED - I.A.B. DRAWN - M.K.J. CHECKED - A.D.O. DATE - JANUARY, 2009	REVISED - REVISED - REVISED - REVISED -	<b>STATE OF ILLINOIS DEPARTMENT OF TRANSPORTATION</b>	<b>TEMPORARY LIGHTING PLAN LEMONT ROAD</b>	F.A.U. RTE. 2612 SECTION 3104 B-1-I-2 COUNTY COOK TOTAL SHEETS 80 SHEET NO. 28 CONTRACT NO. 60D76 <small>FED. ROAD DIST. NO. 1 ILLINOIS FED. AID PROJECT</small>
SCALE: 1" = 50'    SHEET NO. OF SHEETS    STA. TO STA.						