


FOUNDATION & CONDUIT PLAN
SCALE: 1"=20'

- FOREMAN TO CONTACT ALL UTILITIES PRIOR TO EXCAVATION FOR EXACT LOCATION OF THEIR UNDERGROUND FACILITIES.
- FOR CODE SEE DRAWING #826.
- Z - FOREMAN TO CHISEL MARK FOR EXACT LOCATION OF CONDUIT END.
- W - REMOVE POST MOUNTED TRAFFIC CONTROLLER & BREAKDOWN FOUNDATION TYPE "A".

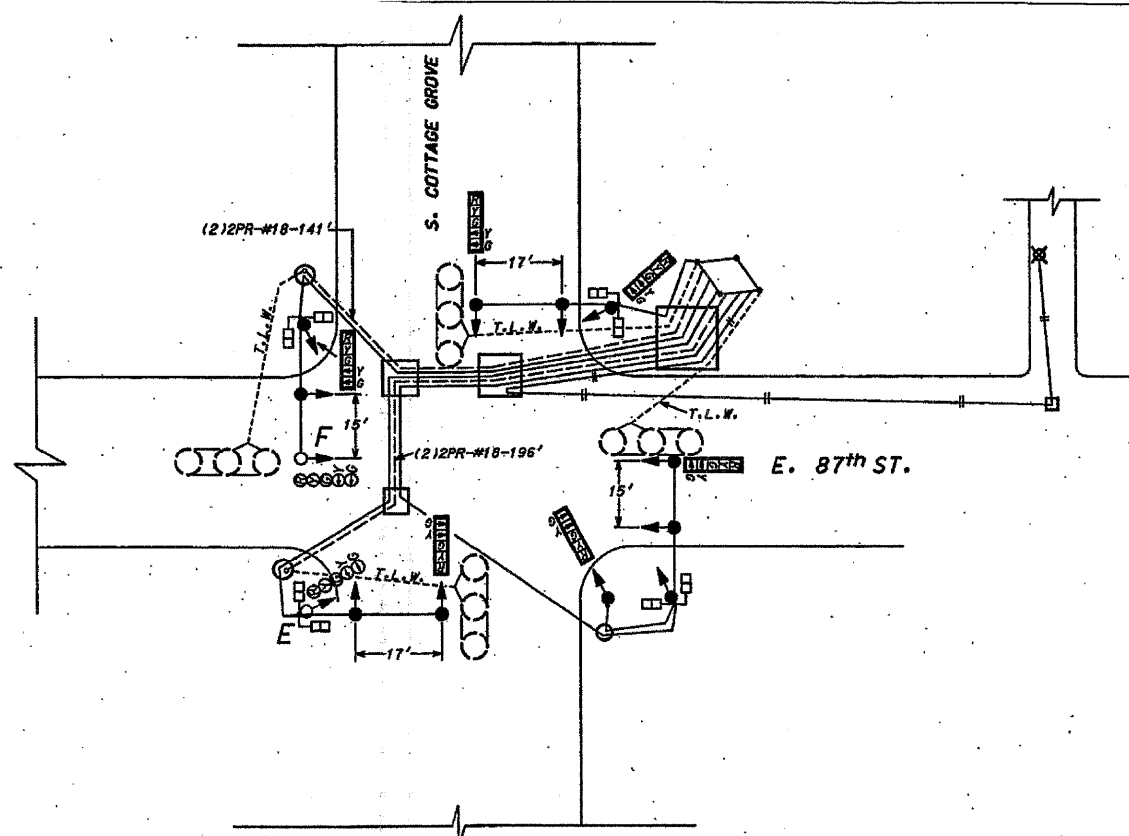

CABLE & SIGNAL PLAN
NOT TO SCALE

- - DENOTES SPLICE #18, CABLE TO TWISTED LOOP WIRE.
- E - INSTALL SIGNAL HEAD/POLY/LED, 1-FACE/S-SIGNAL BRACKET MOUNTED.
- F - INSTALL SIGNAL HEAD/POLY/LED, 1-FACE/S-SIGNAL, MAST ARM MOUNTED.




NOTE:
OPERATIONS SUCH AS PAVEMENT GRINDING OR PATCHING WHICH RESULT IN THE DESTRUCTION OF TRAFFIC SIGNAL DETECTION REQUIRE A NOTIFICATION OF INTENT TO WORK AND AN INSPECTION. A MINIMUM OF SEVEN (7) WORKING DAYS PRIOR TO THE DETECTION REMOVAL, THE CONTRACTOR SHALL NOTIFY ROBERT NELSON, CITY OF CHICAGO BUREAU OF ELECTRICITY TRAFFIC SIGNAL MAINTENANCE SUPERVISOR AT (312)746-4525 AT WHICH TIME ARRANGEMENTS WILL BE MADE TO ADJUST THE TRAFFIC CONTROLLER TIMING TO COMPENSATE FOR THE ABSENCE OF DETECTION. FINAL LOCATIONS OF THE DETECTOR LOOP REPLACEMENT WILL BE APPROVED BY THE CITY OF CHICAGO AND ENGINEER.

THIS PLAN IS FOR INFORMATION AND IS FOR THE SOLE PURPOSE OF DETECTOR LOOP REPLACEMENTS ONLY.

REPLACE ALL DETECTOR LOOPS AS SHOWN
(WITHIN THE RESURFACING LIMITS)

CODE	QUANTITY	UNIT	ITEM
88600600	468	FOOT	DETECTOR LOOP REPLACEMENT

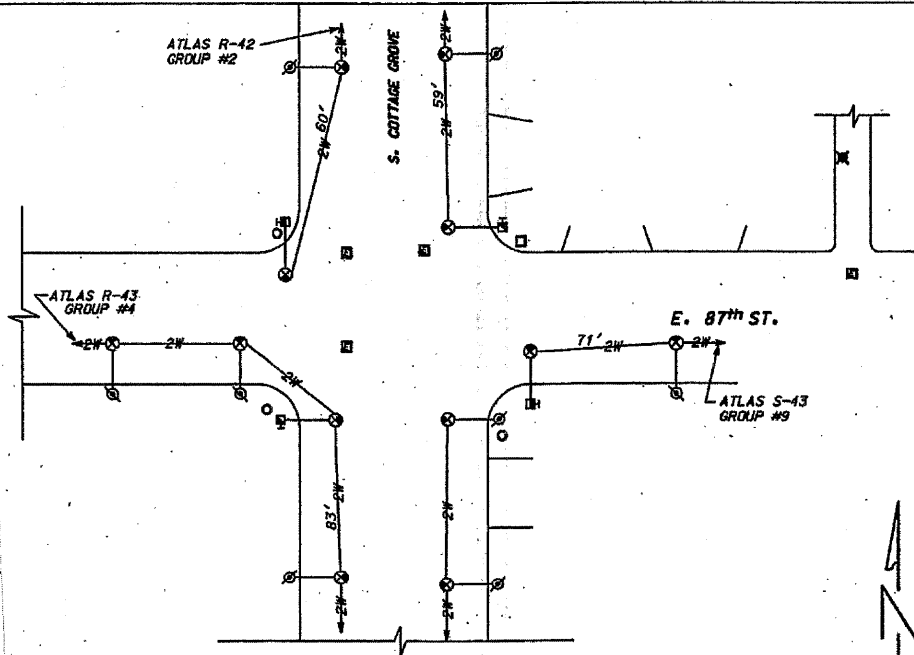

STREET LIGHTING PLAN
NOT TO SCALE

DATE	REVISION
WORK ORDER NO. 1213075	DATE 9-3-02
COST ALLOCATION ACCOUNT	
APPROPRIATION ACCOUNT	MATERIAL
	LABOR
SUPERSEDES DRAWING #12812 DATED 7-29-86.	
TRAFFIC CONTROL SIGNALS	
S. COTTAGE GROVE AVE. & E. 87th ST.	
CITY OF CHICAGO	
<small>DEPT. OF STREET AND SANITATION BUREAU OF ELECTRICITY DIVISION OF ELECTRICAL ENGINEERING</small>	
DRAFTSMAN ARMANDO VIVANCO	CHIEF DRAFTSMAN ROBERT CARTER
SUPERVISING ENGINEER ELEC. DESIGN ENGR. [Signature]	ENGINEER ARMANDO VIVANCO
ENGINEER OF ELECTRICITY [Signature]	DRG. NO. 12812
GEN'L SUPPLY OF ELECTRICALS [Signature]	
DEPUTY COMMISSIONER [Signature]	
SIZE: 22" x 36"	SCALE: AS NOTED
	DATE: 9-3-02

FILE NAME = P:\2009\ME09026_Ver-Yer-PA1\CAD\DWG\CottageGr\Shets\DI06J68-Border-CottageGr.dgn
 PLOT SCALE = 2.0000" / 1"
 USER NAME = Millennium Professional Services

200 22ND Street, Suite 216, Lombard, IL 60148
 630.785.8110 voice, 630.839.3566 fax
 WWW.MPS-IL.COM
MILLENNIA PROFESSIONAL SERVICES

DESIGNED	REVISION
CJD	-
CJD	REVISED -
RPD	REVISED -
	REVISED -

**STATE OF ILLINOIS
DEPARTMENT OF TRANSPORTATION**

COTTAGE GROVE AVENUE
 83RD STREET TO 92ND STREET
DETECTOR LOOP REPLACEMENT PLANS
 COTTAGE GROVE AVE AT 87th STREET

SCALE: - SHEET NO. OF SHEETS STA. TO STA.

F.A.U. RTE.	SECTION	COUNTY	TOTAL SHEETS	SHEET NO.
2919	2009-118 RS	COOK	29	14
CONTRACT NO. 60J68				

FED. ROAD DIST. NO. 1 [ILLINOIS] FED. AID PROJECT

P:\2009\ME09026_Ver-Yer-PA1\CAD\DWG\CottageGr\Shets\DI06J68-Border-CottageGr.dgn