
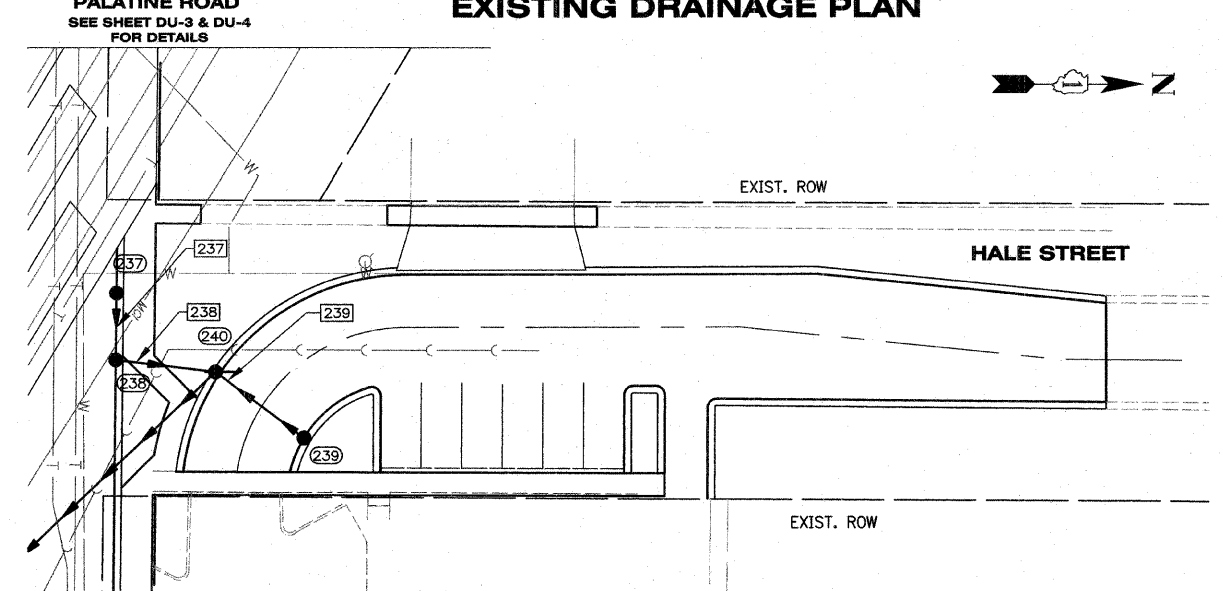
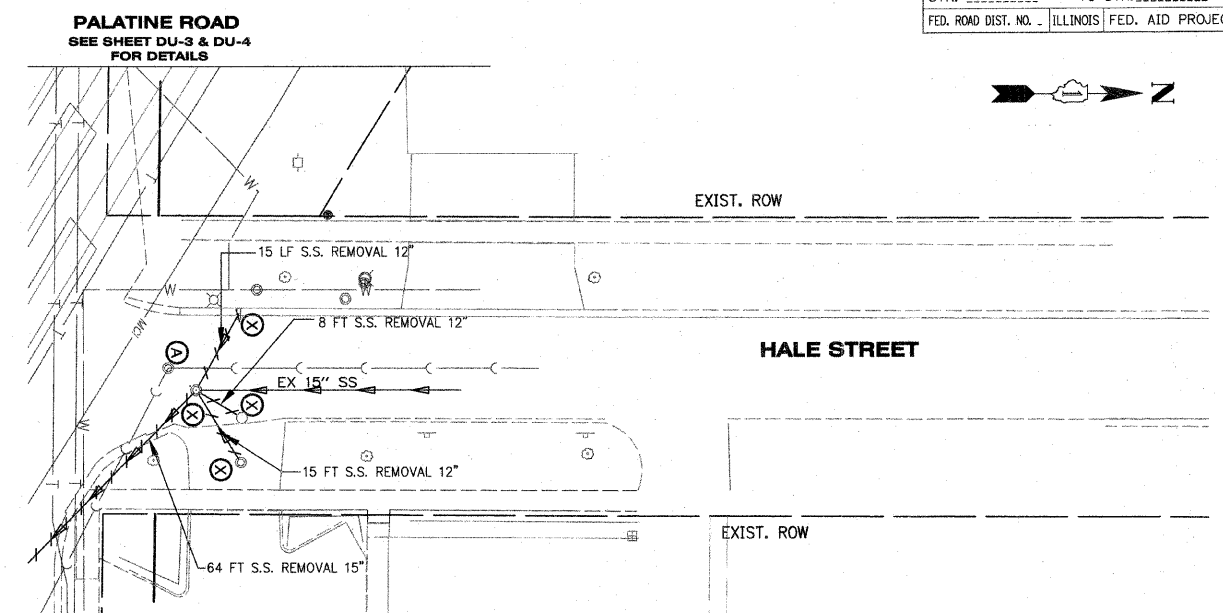
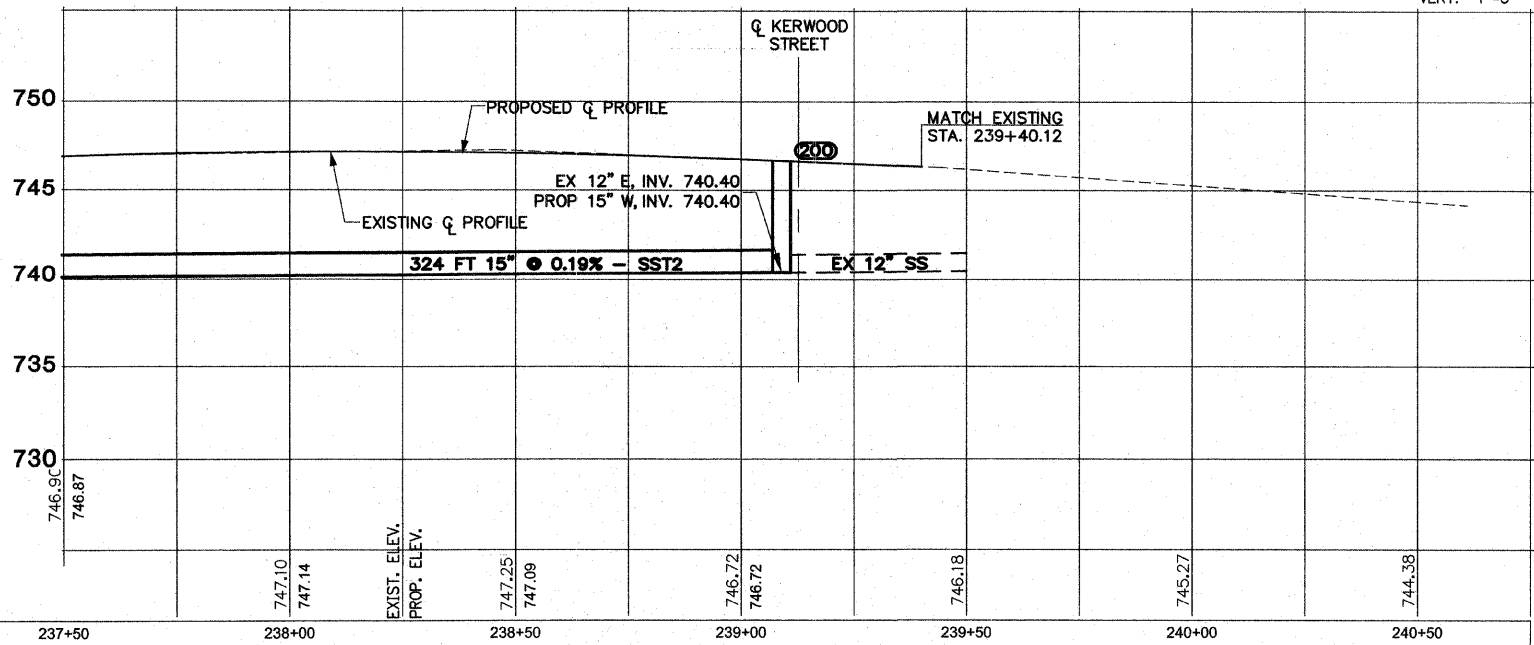
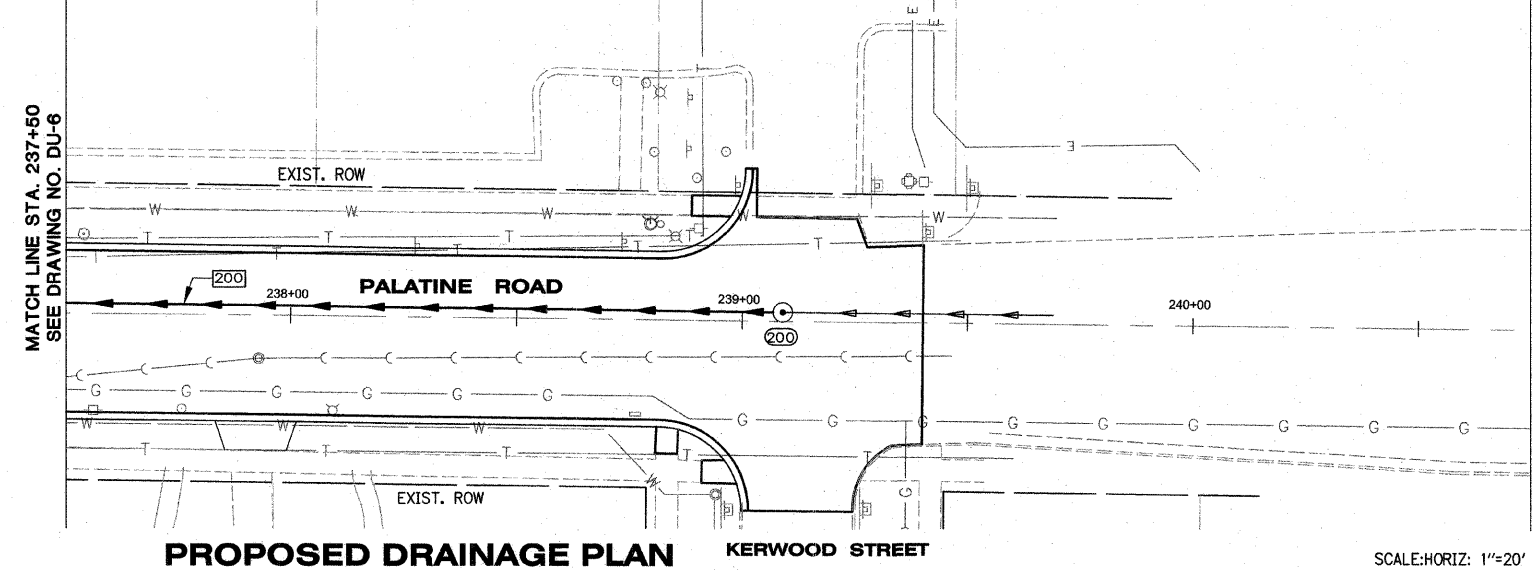


CONTRACT NO. 63083		F.A.P. RTE.	SECTION	COUNTY	TOTAL SHEETS	SHEET NO.
		1285	02-00075-00-PV	COOK	161	50
STA. _____		TO STA. _____				
FED. ROAD DIST. NO. _____		ILLINOIS		FED. AID PROJECT		

PLAN	DATE
BY	
CHECKED	
APPROVED	
NO.	

PROFILE	DATE
BY	
CHECKED	
APPROVED	
NO.	

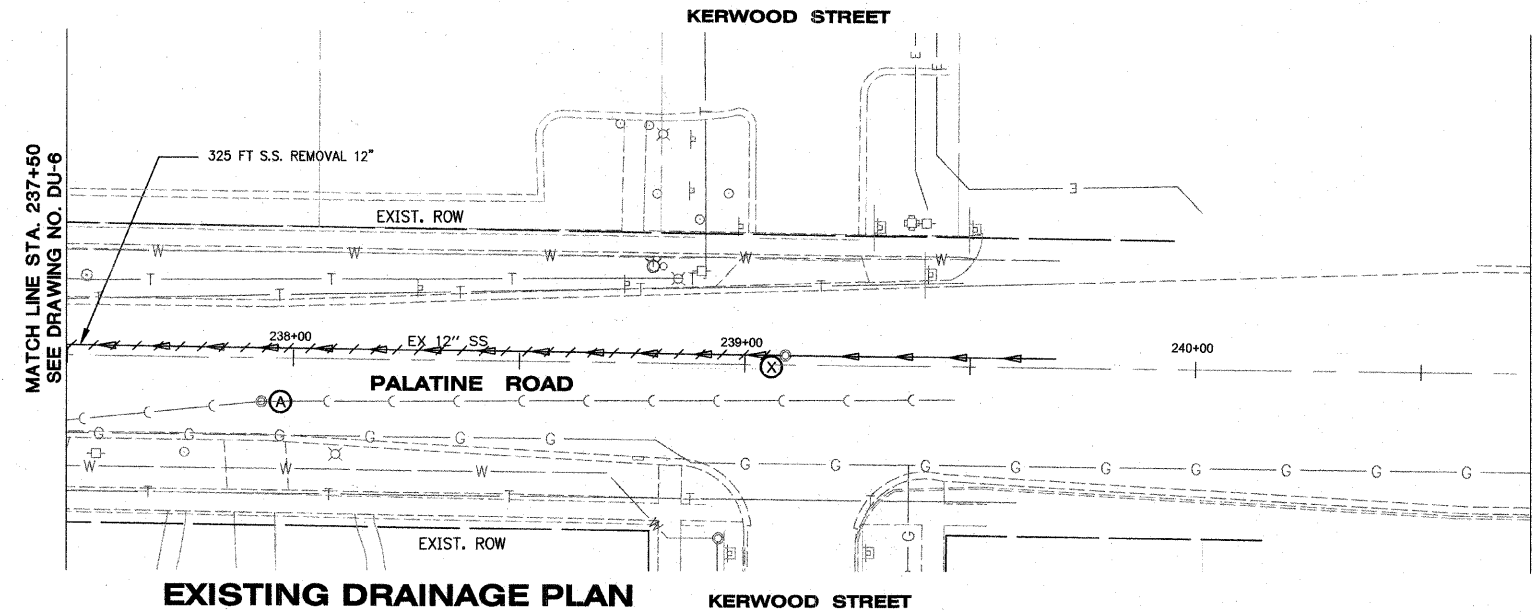

LEGEND

- EXISTING STORM SEWER
- - - STORM SEWER REMOVAL
- PROPOSED STORM SEWER
- PROPOSED MANHOLE
- PROPOSED CATCH BASIN
- ⊗ REMOVE
- ⊙ ADJUST
- ⊕ ABANDON
- ⊗ PROPOSED STORM SEWER (SEE DU-11 FOR SCHEDULE)
- ⊗ PROPOSED DRAINAGE STRUCTURE (SEE DU-11 FOR SCHEDULE)

ILLINOIS DEPARTMENT OF TRANSPORTATION
 VILLAGE OF PALATINE
 PALATINE ROAD & PLUM GROVE ROAD RECONSTRUCTION
 DRAINAGE PLAN AND PROFILE
 STA 237+50.00 TO STA 239+40.12