

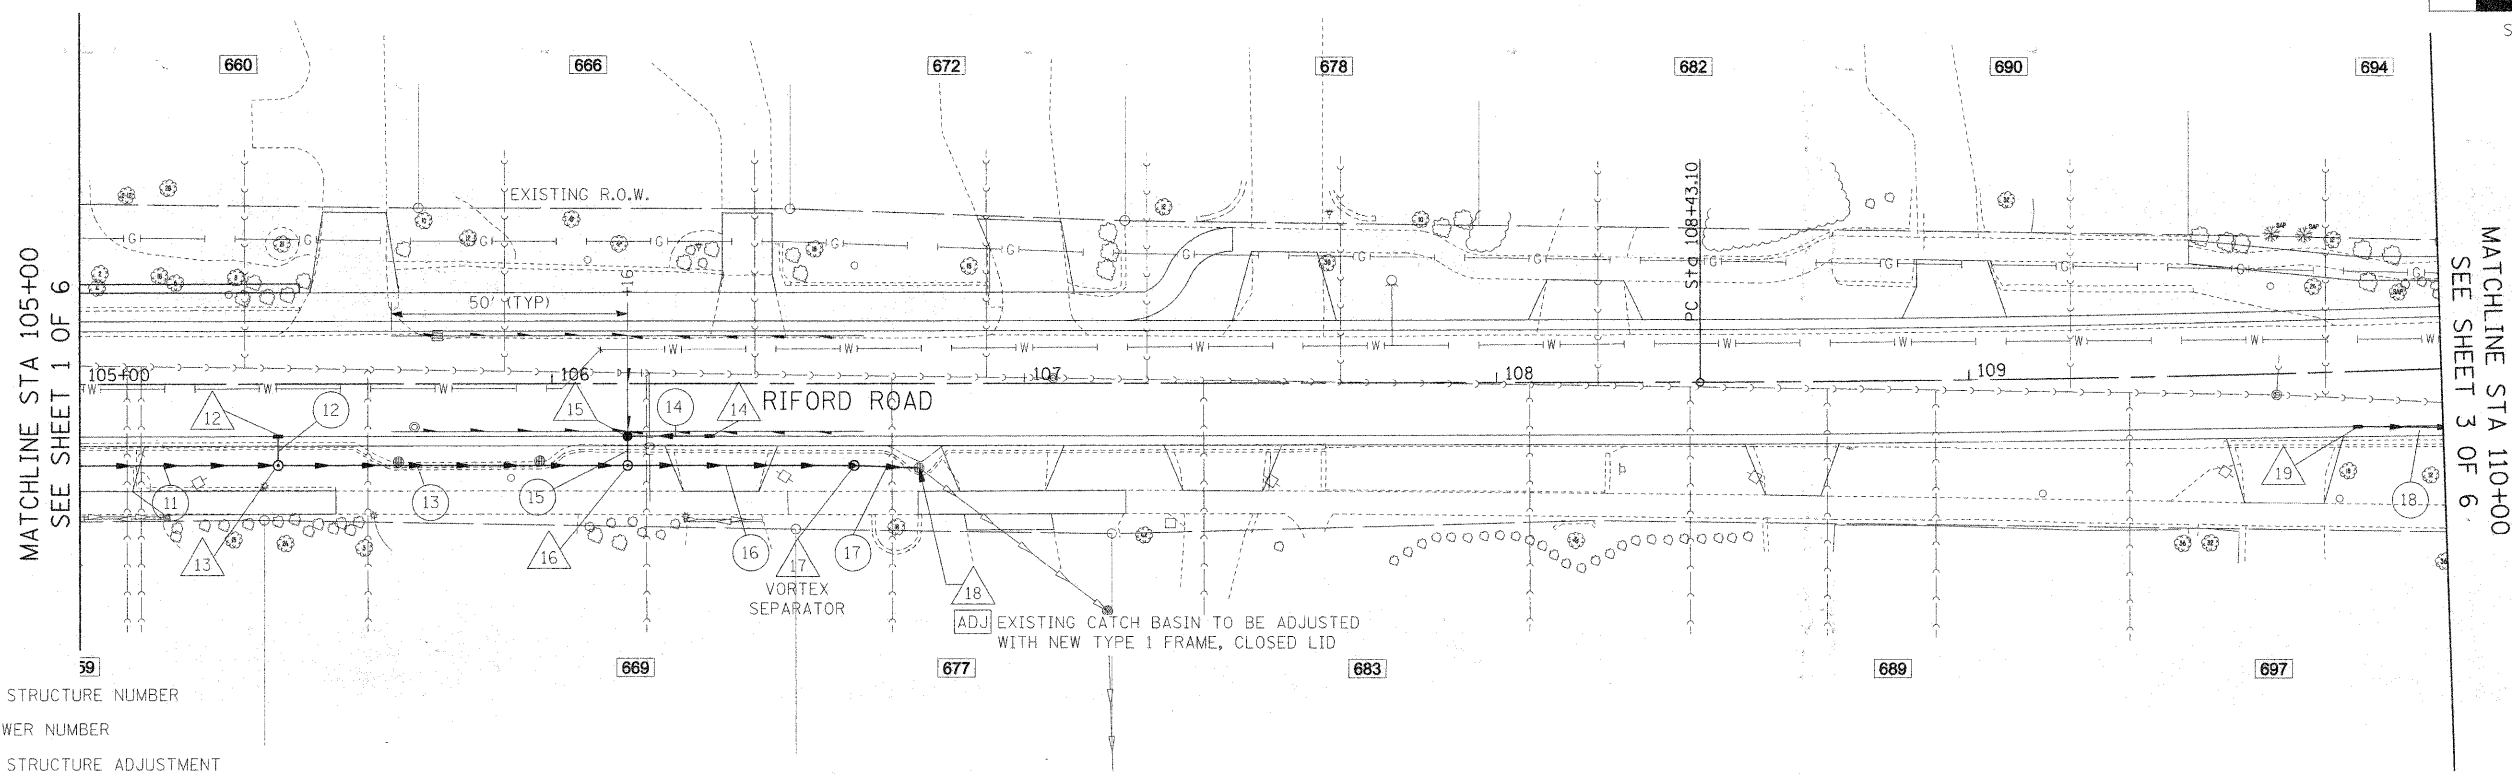


PLAN	SURVEYED	BY	DATE
	PLOTTED		
	CHECKED		
	NO. OF WAY CHECKED		
	NOTE BOOK NO.		
	DATE		
	CADD FILE NAME		

PROFILE	SURVEYED	BY	DATE
	PLOTTED		
	CHECKED		
	NO. OF WAY CHECKED		
	NOTE BOOK NO.		
	DATE		
	CADD FILE NAME		

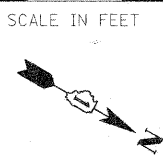

- DRAINAGE LEGEND:**
- XX DRAINAGE STRUCTURE NUMBER
 - XX STORM SEWER NUMBER
 - ADJ DRAINAGE STRUCTURE ADJUSTMENT
 - STORM SEWER WITH CASING PIPE
 - 4" PIPE UNDERDRAIN

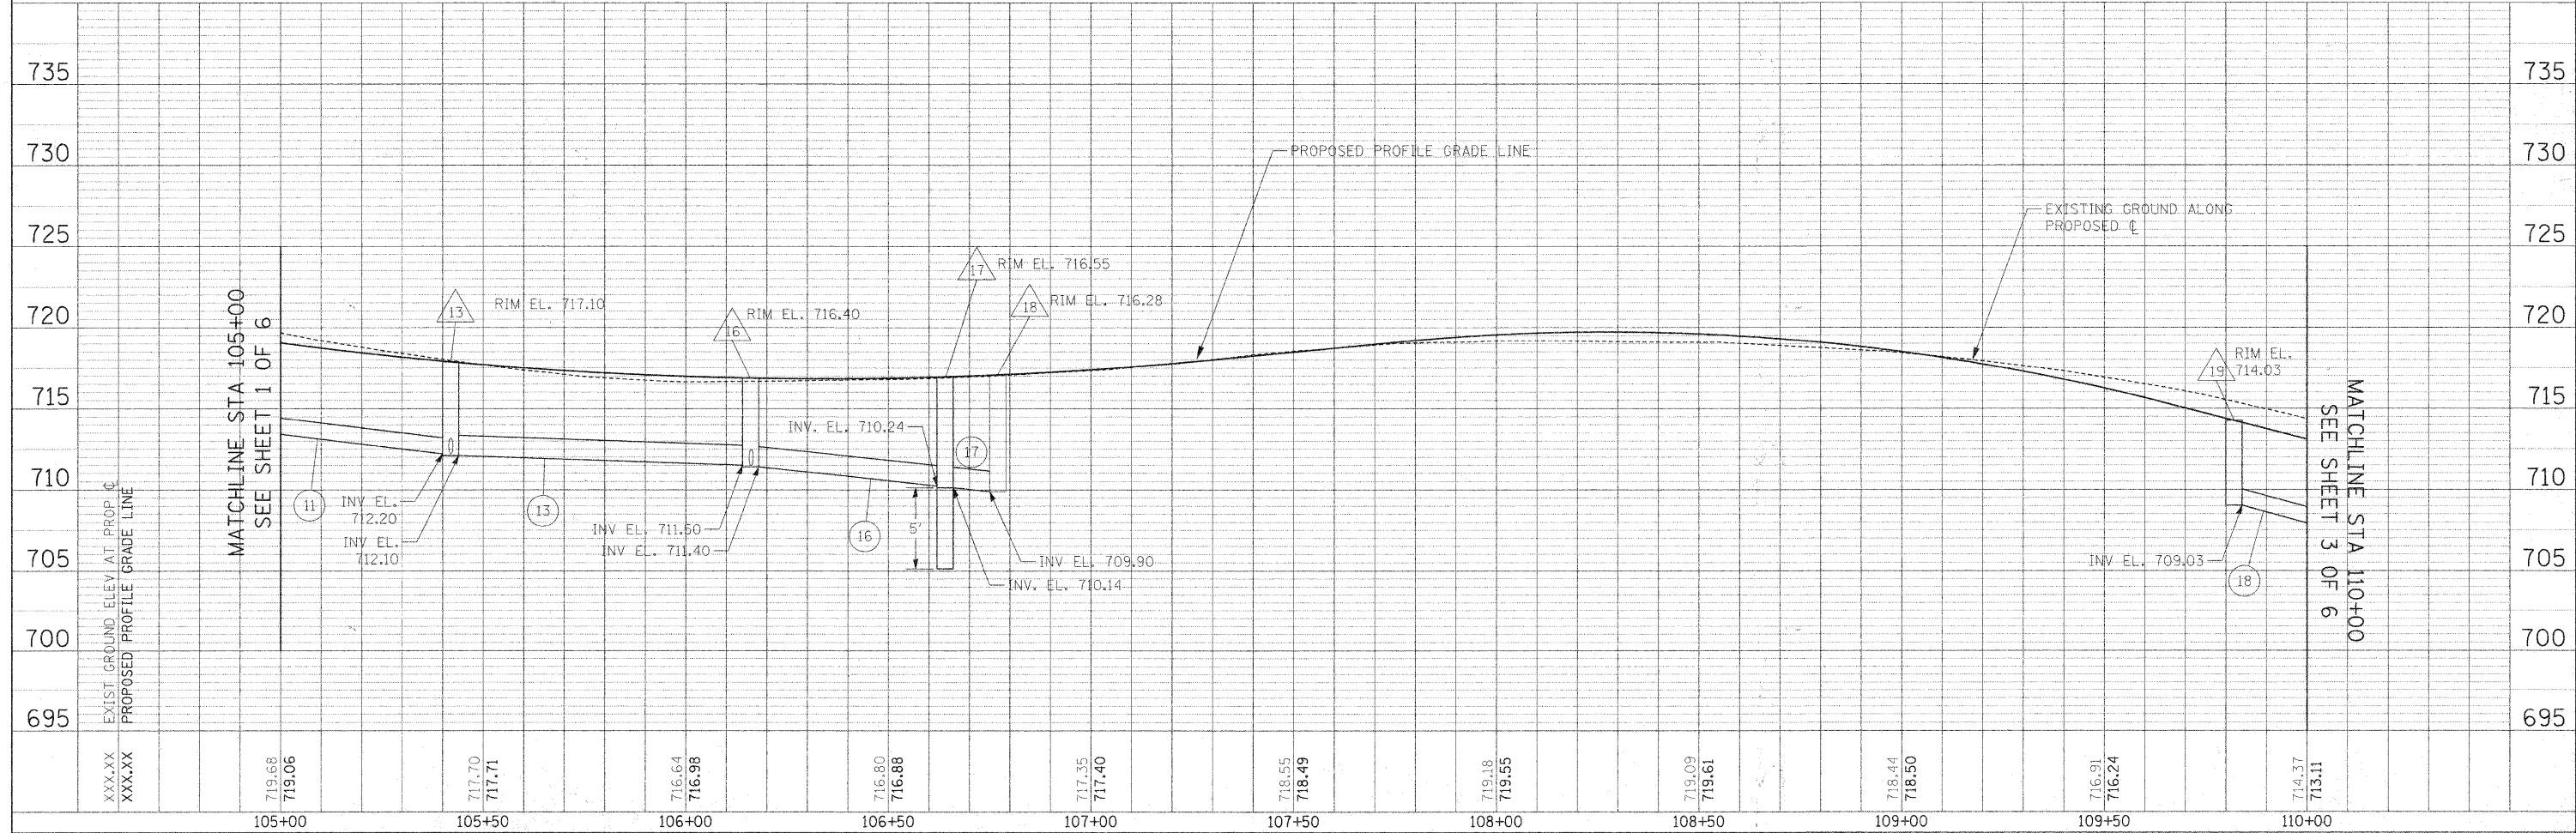

FILE NAME = #FILE#	USER NAME = #USER#	DESIGNED -	REVISED -	STATE OF ILLINOIS DEPARTMENT OF TRANSPORTATION	RIFORD ROAD DRAINAGE PLAN AND PROFILE	F.A.U. R.F.E. 2005	SECTION 05-00068-00-FP	COUNTY DUPAGE	TOTAL SHEETS 141	SHEET NO. 50	
	PLOT SCALE = #SCALE#	CHECKED -	REVISED -			SCALE: 1"=20'		SHEET NO. 2 OF 6 SHEETS		STA. 105+00.00 TO STA. 110+00.00	
	PLOT DATE = #DATE#	DATE - 12/01/2009	REVISED -			RIFORD ROAD RECONSTRUCTION		CONTRACT NO. 63092		FED. ROAD DIST. NO. 1 ILLINOIS FED. AID PROJECT	