



PLAN	SURVEYED	BY	DATE
	ALIGNED		
	NOTED		
	NO.		

PROFILE	SURVEYED	BY	DATE
	PROF. CHECKED		
	BLK. NOTED		
	NO.		

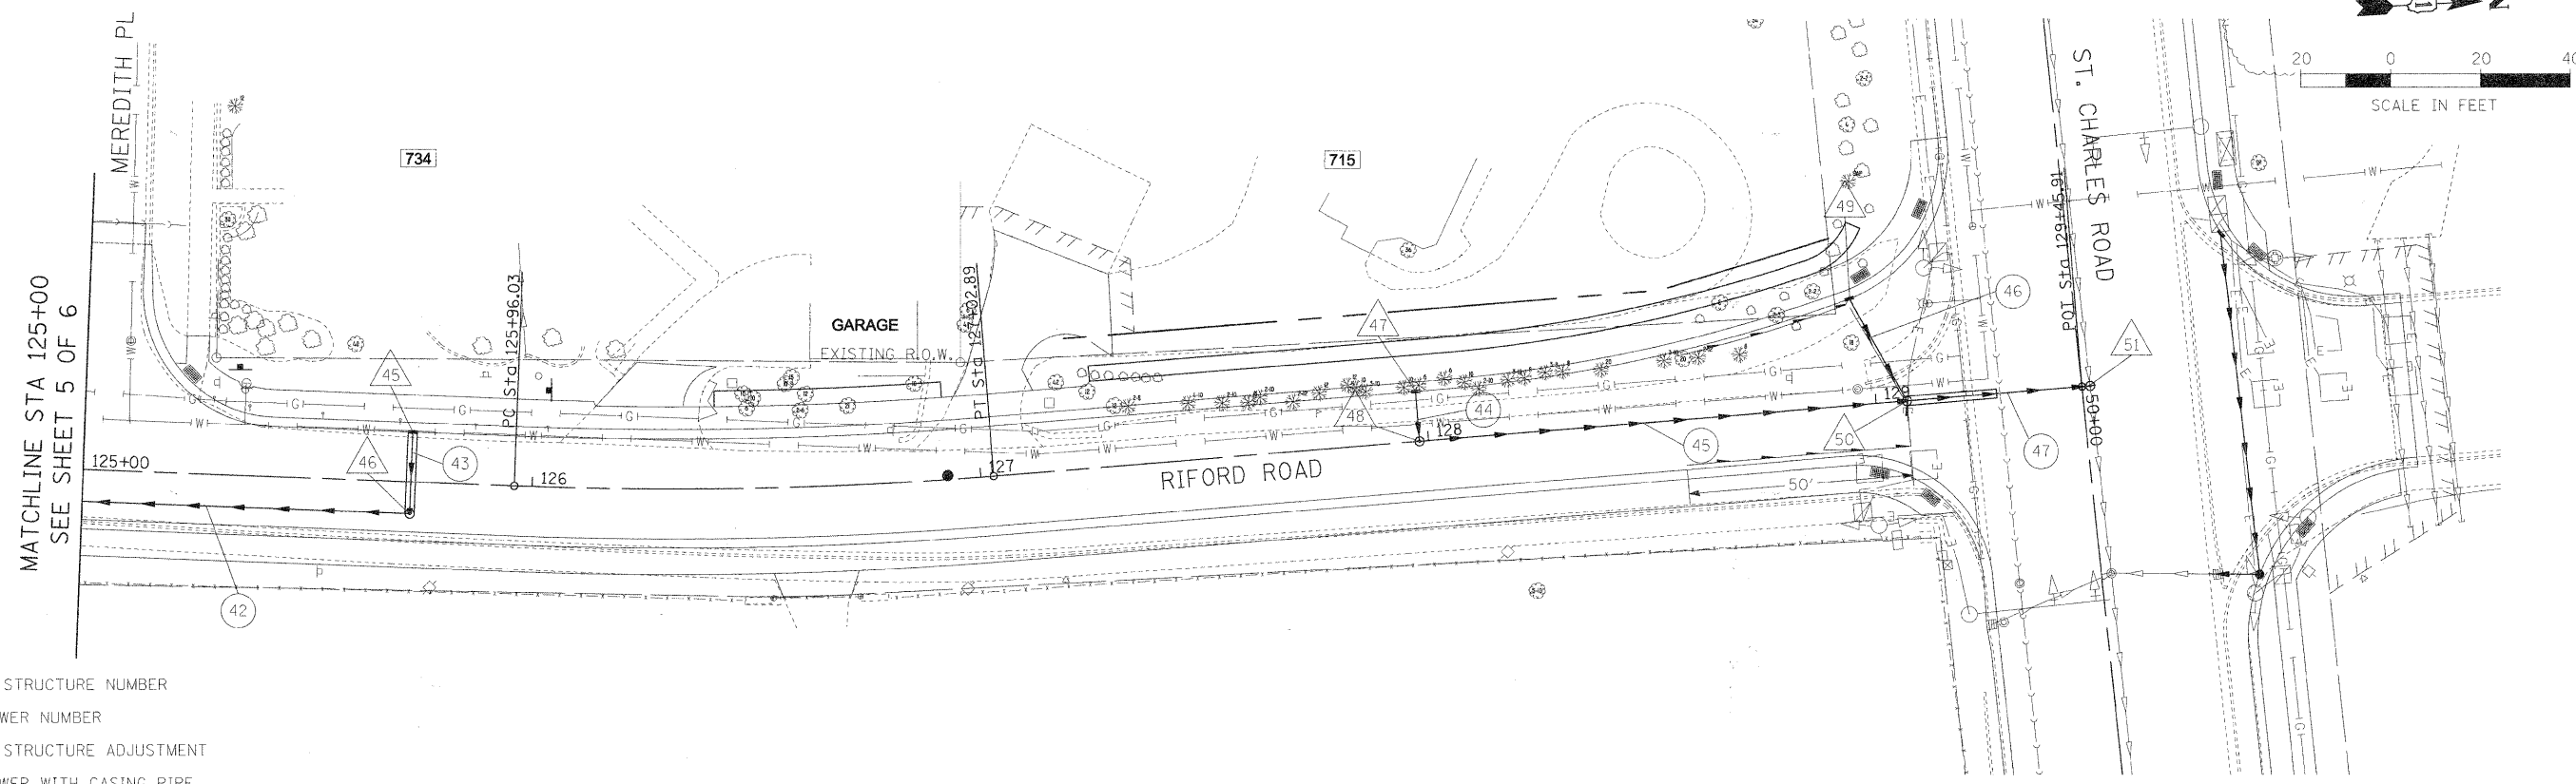

- DRAINAGE LEGEND:**
- △ XX DRAINAGE STRUCTURE NUMBER
 - XX STORM SEWER NUMBER
 - ADJ DRAINAGE STRUCTURE ADJUSTMENT
 - STORM SEWER WITH CASING PIPE
 - 4" PIPE UNDERDRAIN

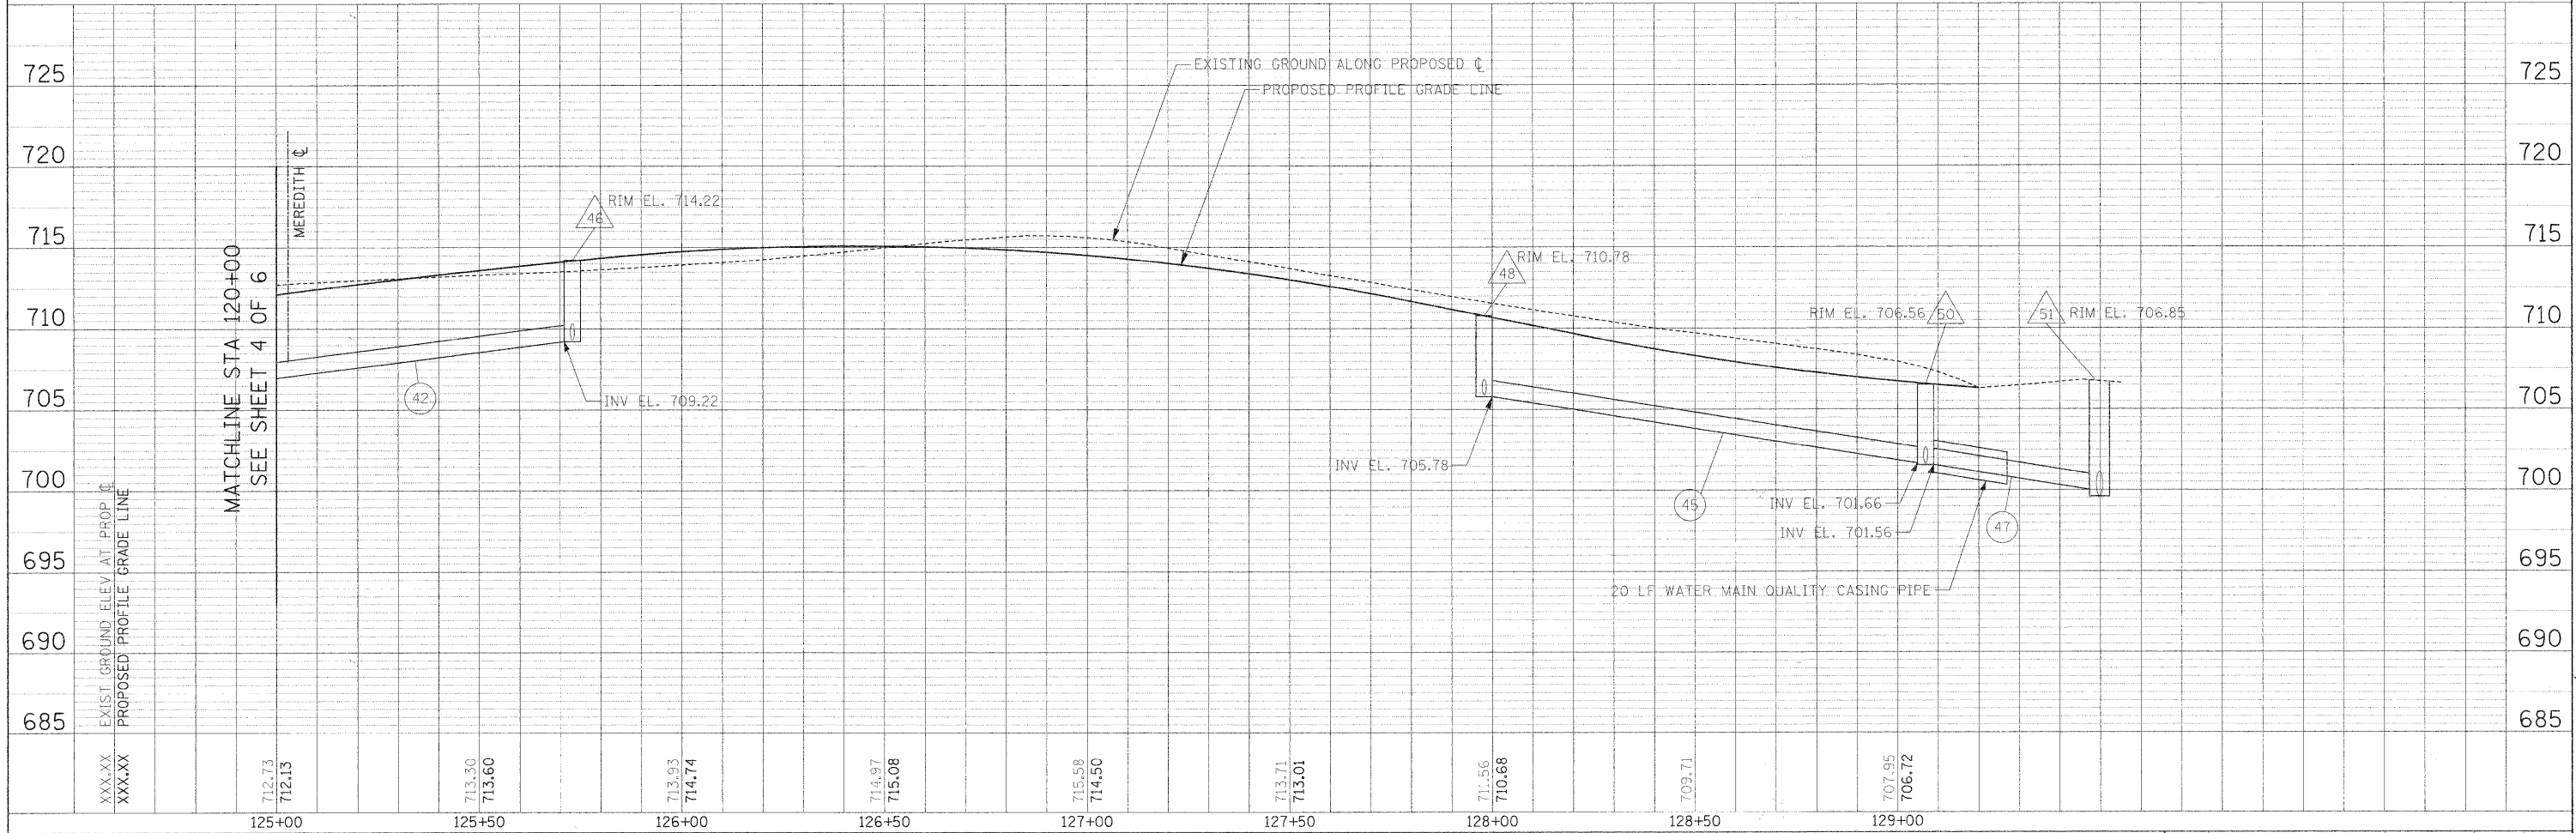

FILE NAME =	USER NAME = #USER#	DESIGNED - AJB	REVISED -	STATE OF ILLINOIS DEPARTMENT OF TRANSPORTATION	RIFORD ROAD DRAINAGE PLAN AND PROFILE	F.A.U. RTE. 215	SECTION 05-00068-00-FP	COUNTY DUPAGE	TOTAL SHEETS 141	SHEET NO. 54
#FILE#	PLOT SCALE = \$SCALE#	CHECKED - DEB	REVISED -			RIFORD ROAD RECONSTRUCTION	CONTRACT NO. 63092			
	PLOT DATE = \$DATE#	DATE - 12/01/2009	REVISED -			FED. ROAD DIST. NO. 1 ILLINOIS	FED. AID PROJECT			
						SCALE: 1"=20'	SHEET NO. 6 OF 6 SHEETS	STA. 125+00.00 TO STA. 129+44.85		