


CONTRACT No. 63353

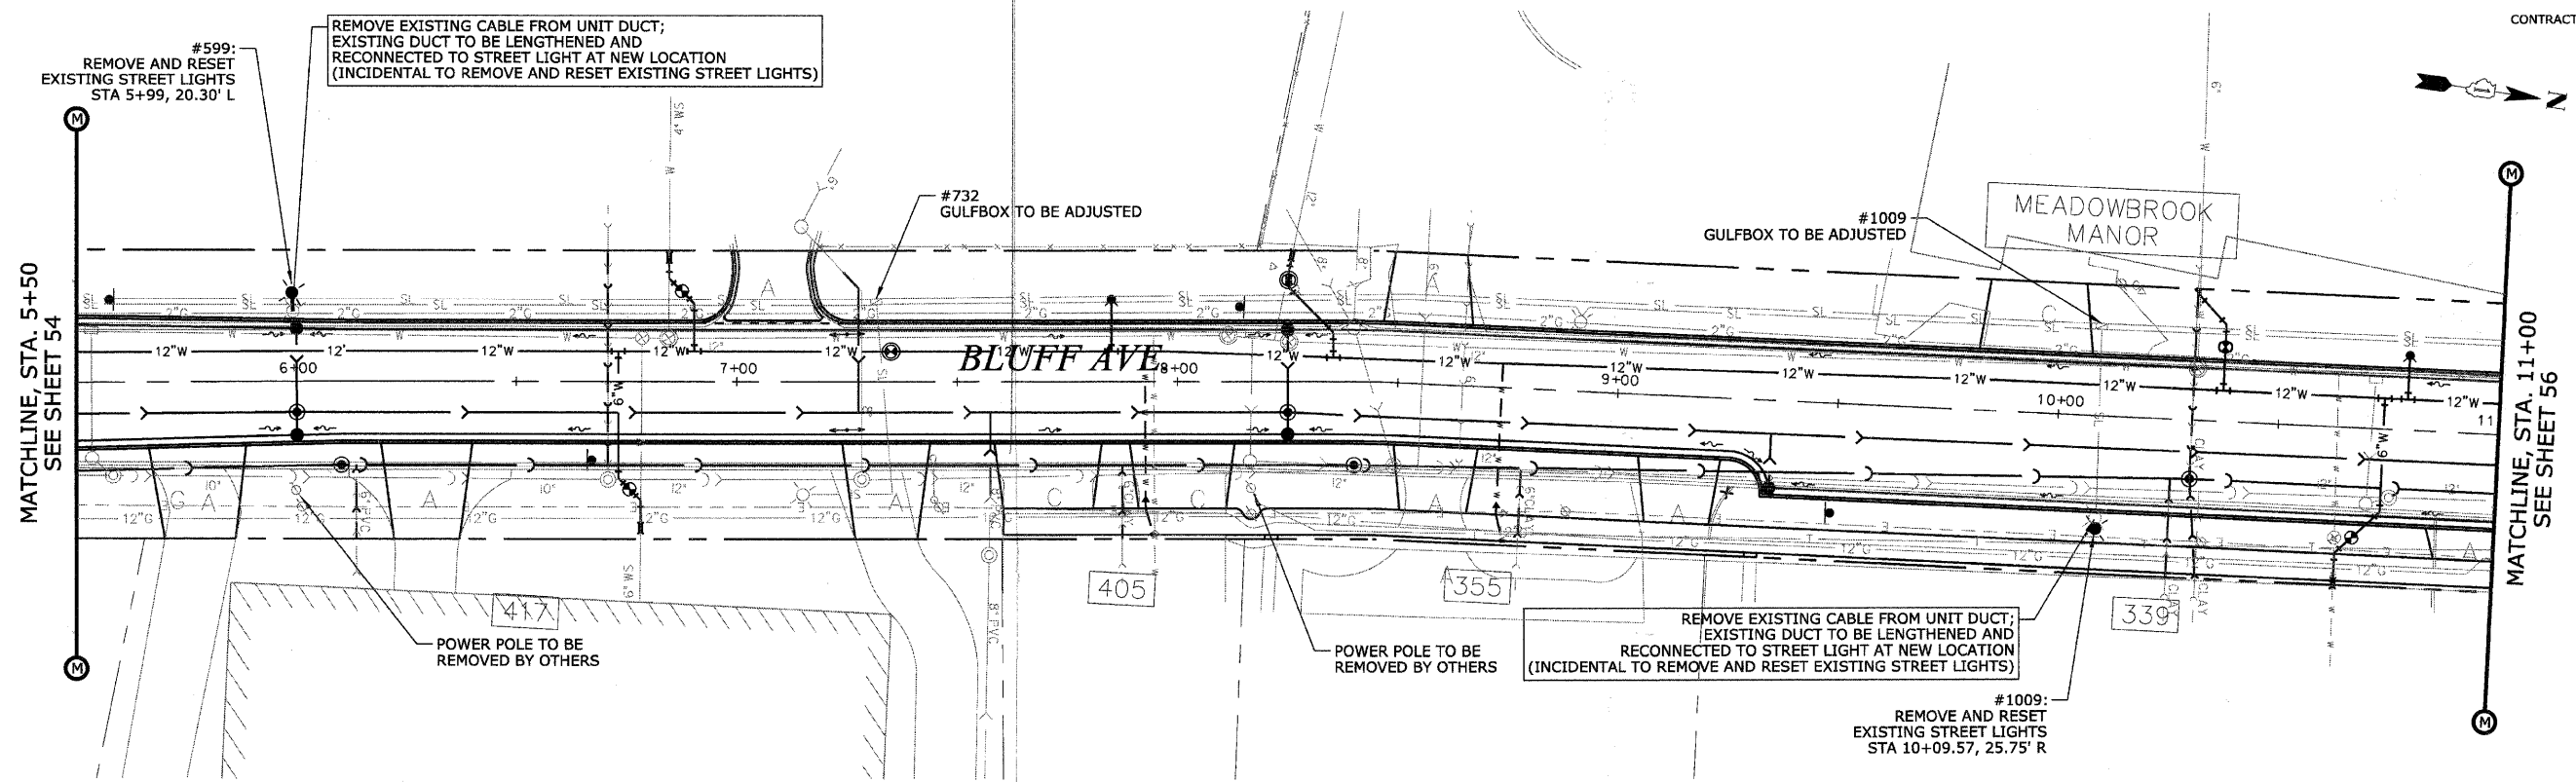

PLAN	REVISIONS	DATE
NO.	BY	
	PLOTTED	
	ALIGNED CHECKED	
	CADD FILE NAME	

PROFILE	REVISIONS	DATE
NO.	BY	
	PLOTTED	
	GRADES CHECKED	
	STRUCTURE NOTATIONS CHECKED	

REVISIONS	
NAME	DATE

ILLINOIS DEPARTMENT OF TRANSPORTATION
BLUFF AVENUE IMPROVEMENTS
STAGE 3

ELECTRICAL/STREETLIGHTING PLAN

SCALE: 1" = 20' H (Full Size)
 1" = 44' H (Tabloid)

DATE 11/30/2009

DRAWN BY H&A
 CHECKED BY JRH