


CONTRACT No. 63353

PLAN	DATE
SUBMITTED	
PLOTTED	
ALIGNED	
CHECKED	
NO. _____	
DATE _____	

PROFILE	DATE
SUBMITTED	
PLOTTED	
GRADES CHECKED	
STRUCTURE NOTATIONS CHKD	
NO. _____	
DATE _____	

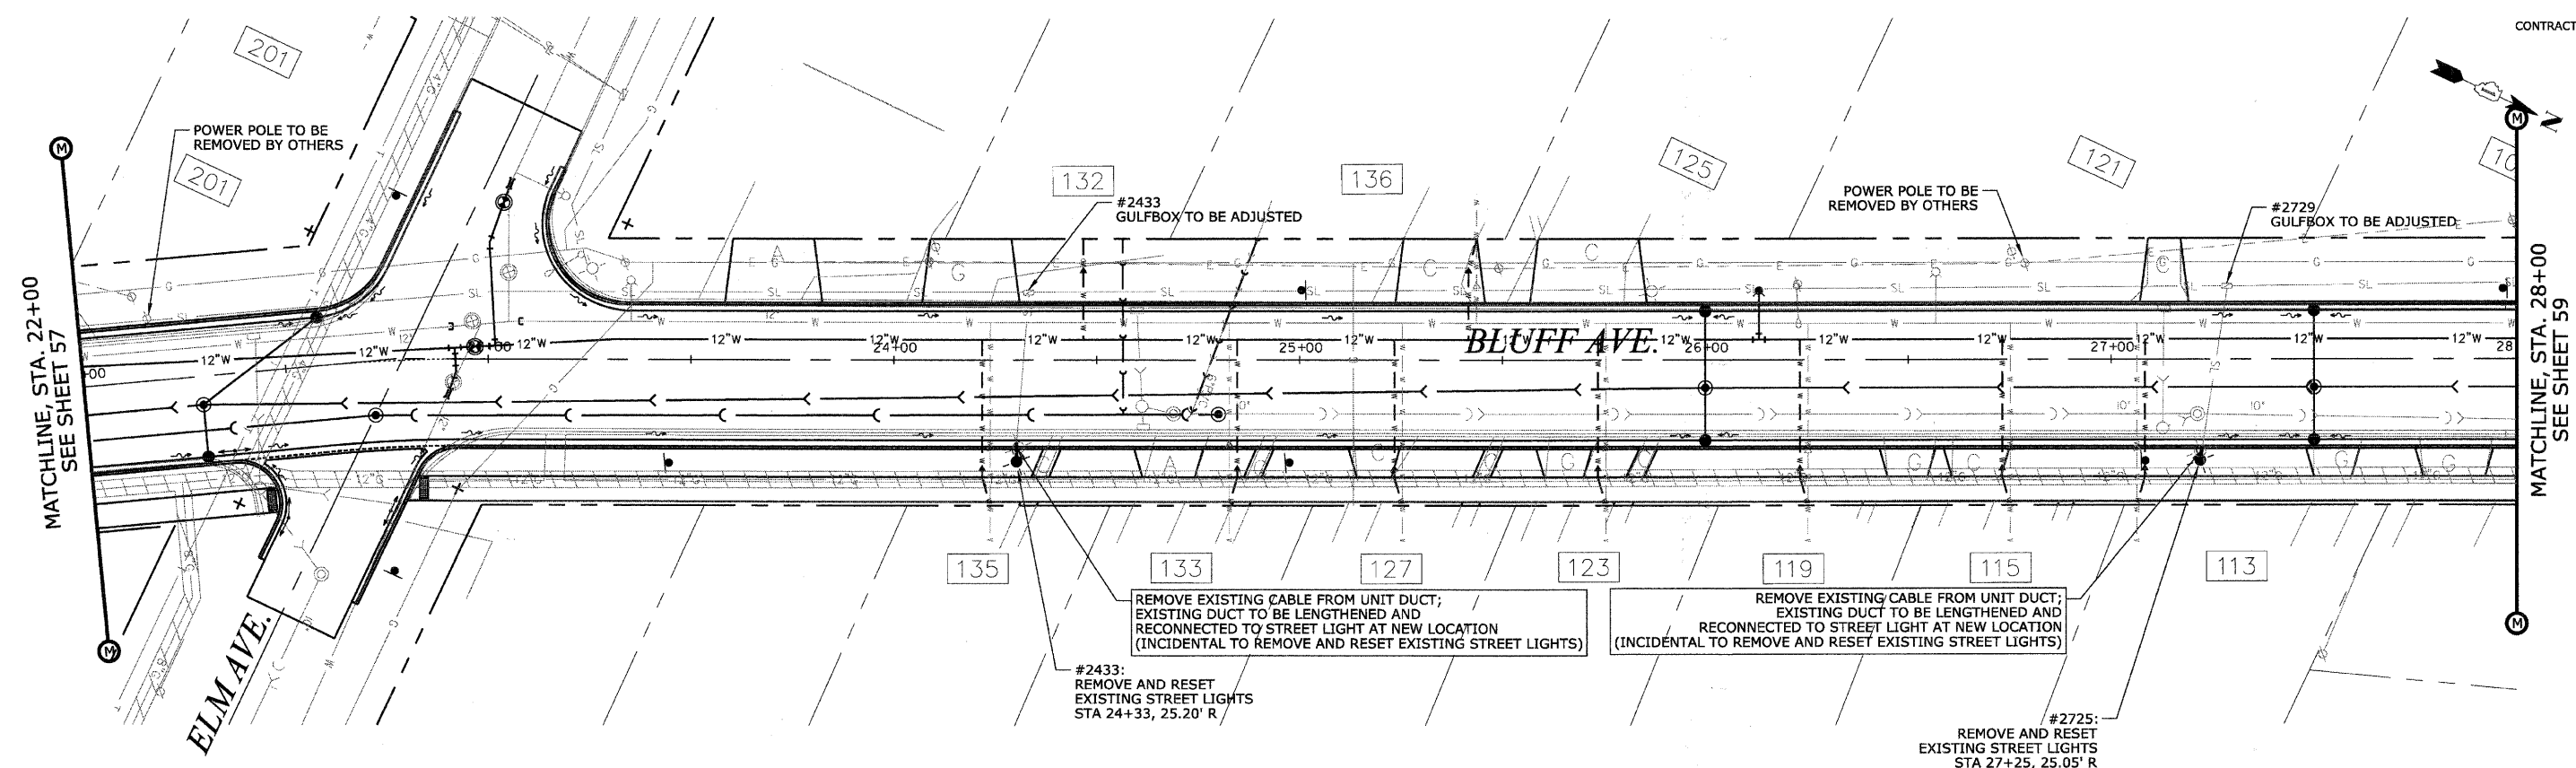

REVISIONS	
NAME	DATE

ILLINOIS DEPARTMENT OF TRANSPORTATION
BLUFF AVENUE IMPROVEMENTS
STAGE 3
ELECTRICAL/STREETLIGHTING PLAN
 SCALE: 1" = 20' H (Full Size)
 = 44' H (Tabloid)
 DATE 11/30/2009
 DRAWN BY H&A
 CHECKED BY JRH