



TYPICAL SPLICE DETAIL
N.T.S.

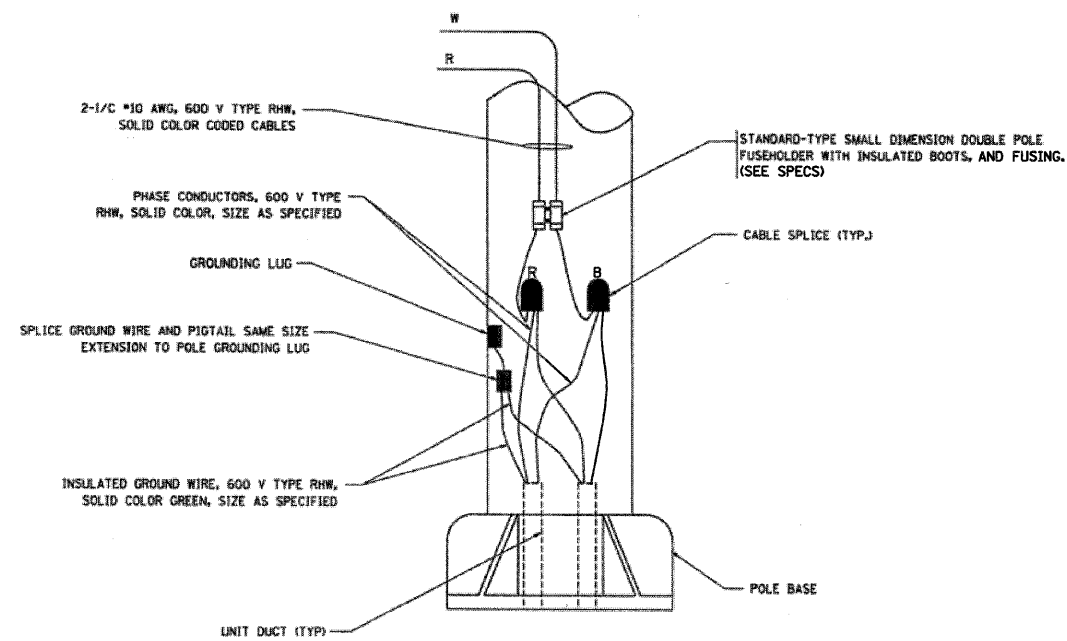

POLE WIRING DETAIL
N.T.S.

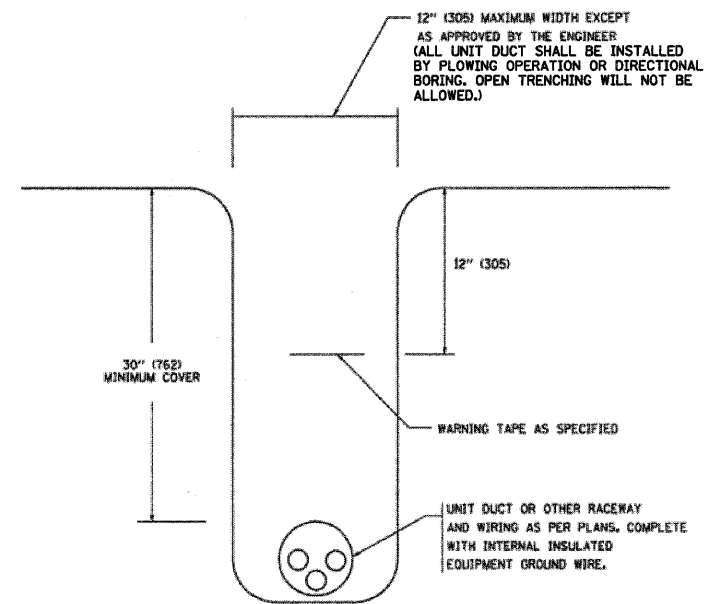

TYPICAL WIRING IN TRENCH DETAIL
N.T.S.

J:\258\10pm\Sheet\Electrical\09033807-sht-Hgplan.dwg
 DATE#

FILE NAME =	USER NAME = #USER#	DESIGNED - AM	REVISED -
#FILES#		DRAWN - AM	REVISED -
	PLOT SCALE = #SCALE#	CHECKED - GR	REVISED -
	PLOT DATE = #DATE#	DATE - 12/01/2009	REVISED -

STATE OF ILLINOIS
DEPARTMENT OF TRANSPORTATION

EVANSTON LAKE FROM PATH
MISC ELECTRICAL DETAILS

SCALE: NTS SHEET NO. OF SHEETS STA. 97+00 TO STA. 106+83

C-91-338-07				
F.A. RTE.	SECTION	COUNTY	TOTAL SHEETS	SHEET NO.
	07-00246-00-BT	COOK	81	53
ITEP NO. 102121		CONTRACT NO. 63423		
FED. ROAD DIST. NO. ILLINOIS FED. AID PROJECT				

SINGH 300 W. ADAMS ST.
CHICAGO, IL 60606
SINGH & ASSOCIATES, INC. TEL: (312) 629-0240
CONSULTING ENGINEERS FAX: (312) 629-8449