
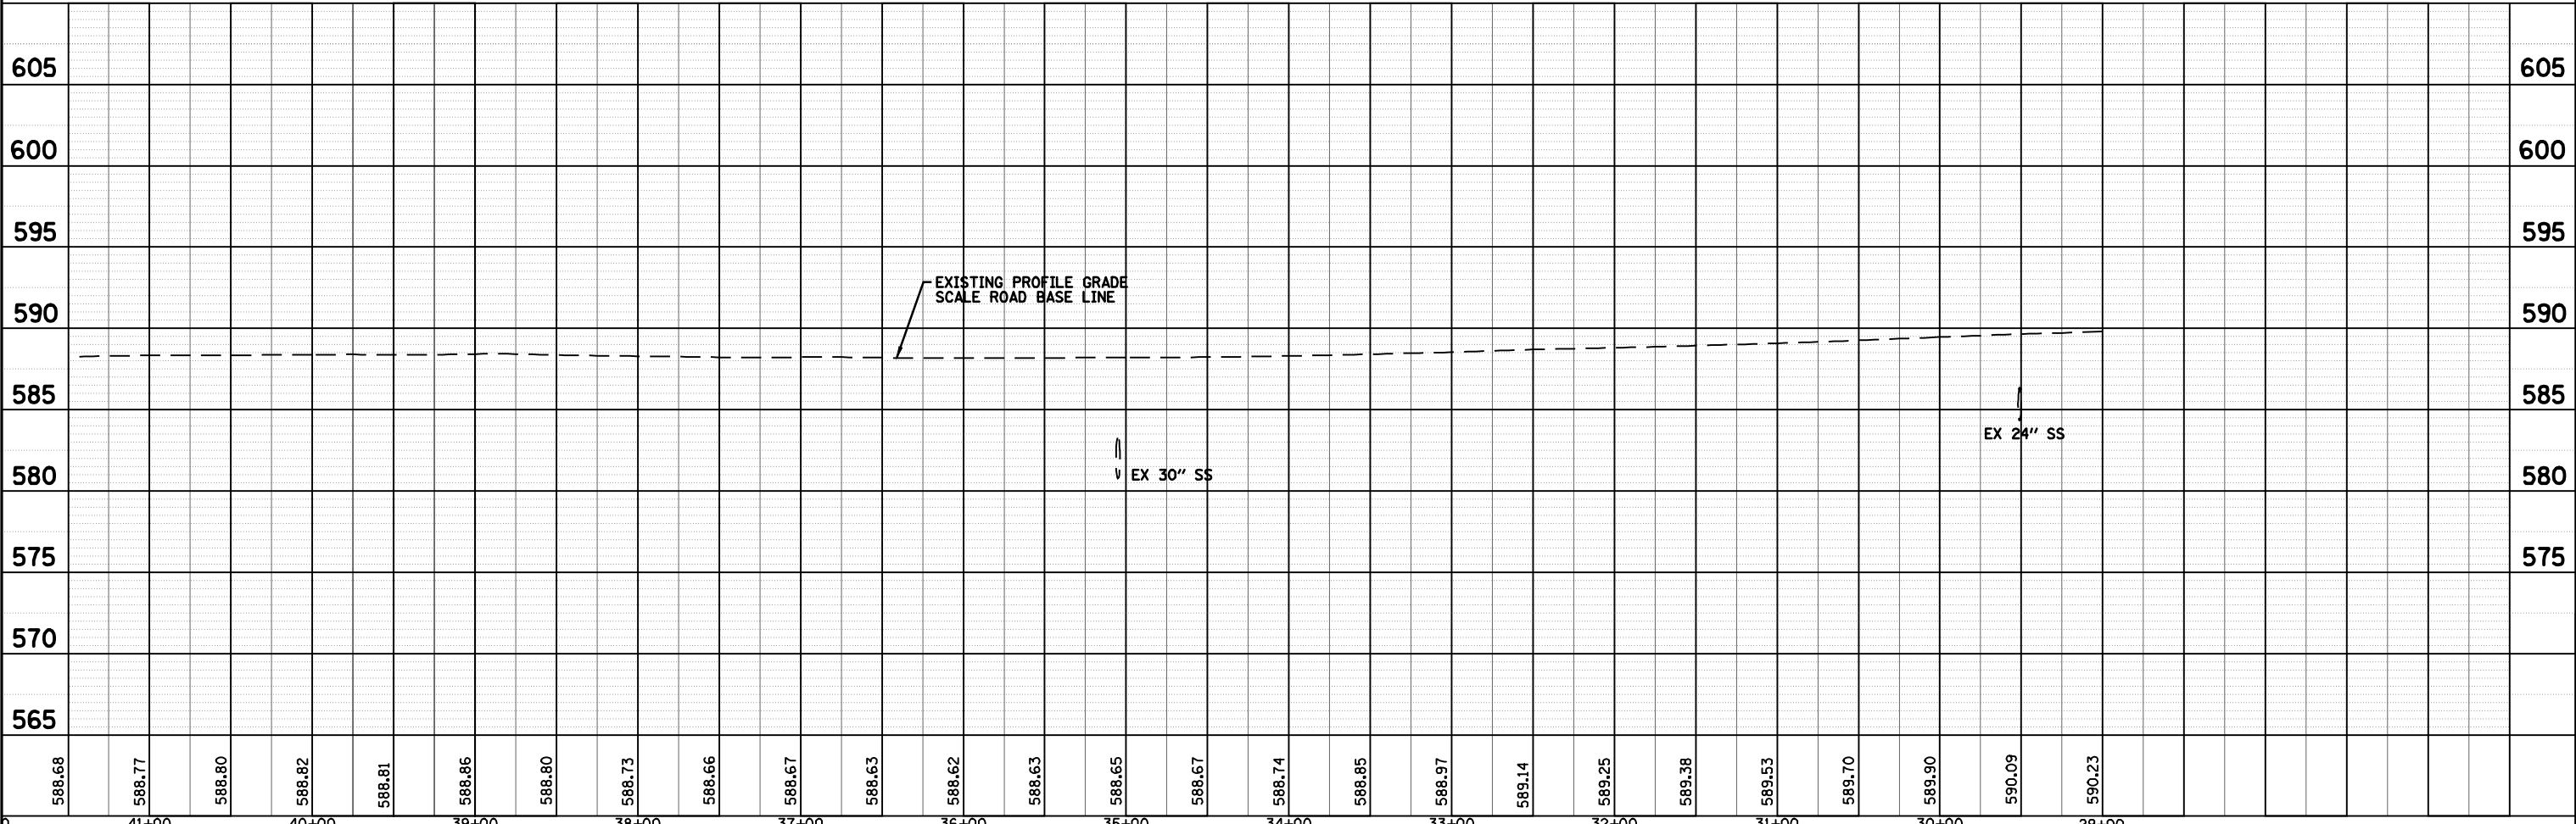
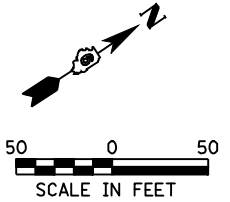


PLAN	SURVEYED	BY	DATE
	ALIGNED		
	CHECKED		
	NO. _____		
	NOTE BOOK		
	NO. _____		
	CADD FILE NAME		

PROFILE	SURVEYED	BY	DATE
	GRADES CHECKED		
	STRUCTURE NOTATIONS OK'D		
	NO. _____		
	NOTE BOOK		
	NO. _____		

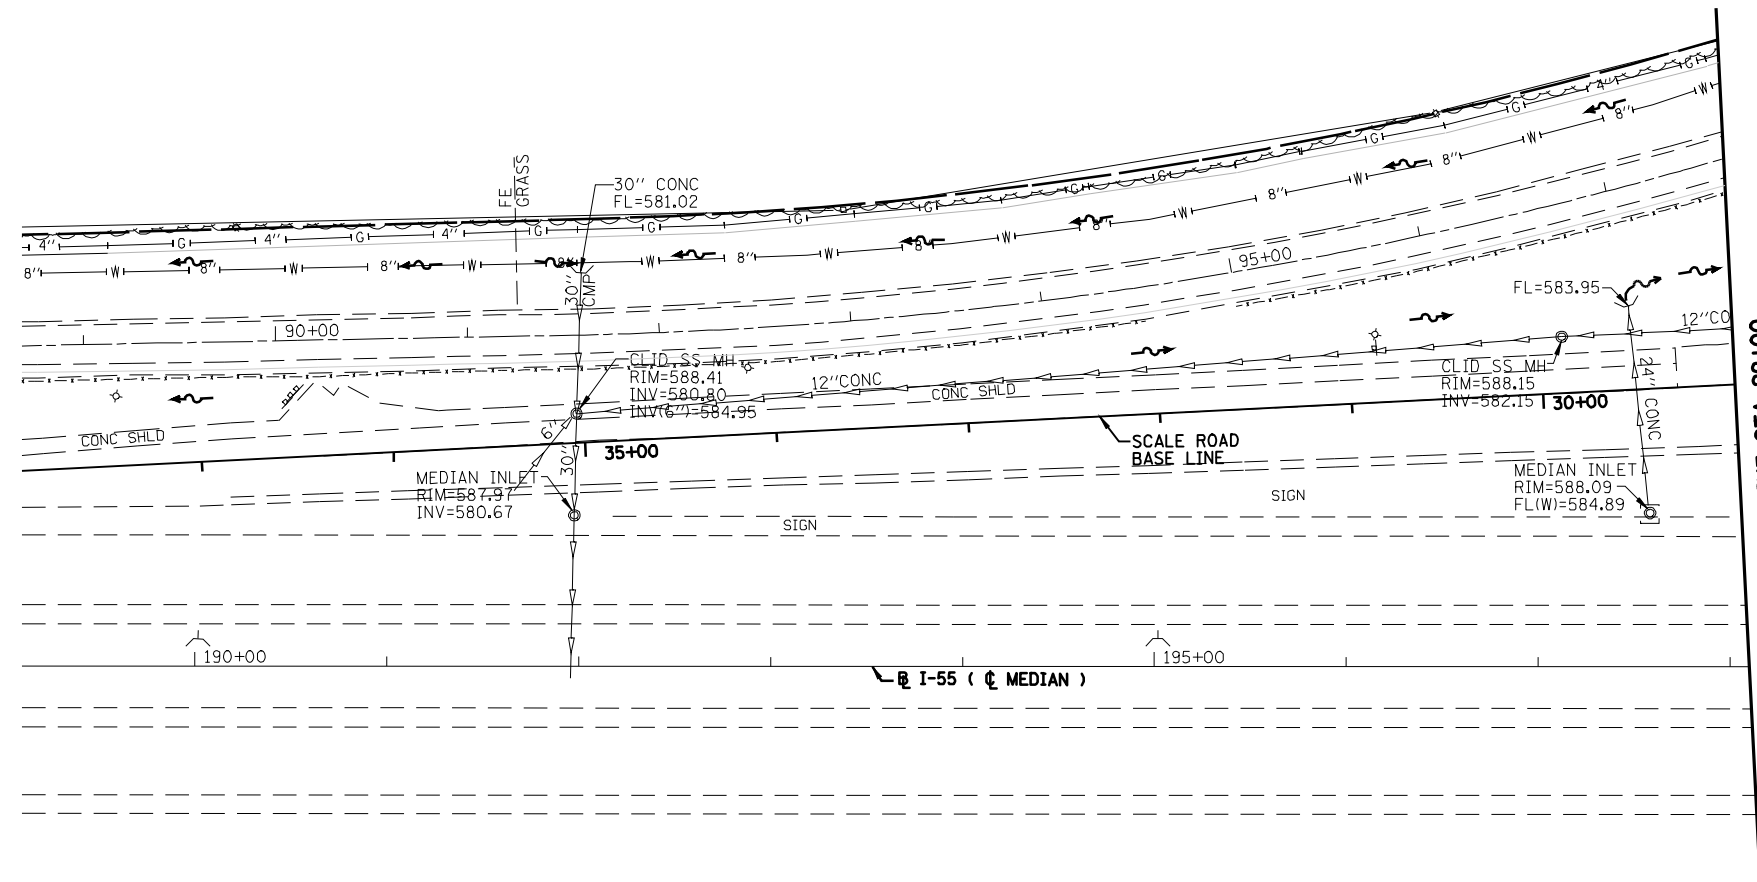

588.59

FILE NAME =	USER NAME = laughlinr1	DESIGNED - ERB	REVISED - DRR 02/22/10	STATE OF ILLINOIS DEPARTMENT OF TRANSPORTATION	DRAINAGE PLAN		F.A.I. RTE.	SECTION	COUNTY	TOTAL SHEETS	SHEET NO.
c:\pwwork\pwwid0t\LAUGHLINRL\0187096\13_4-D102681_DRAINAGE.dgn		DRAWN - JJ	REVISED -		55	84-1-2WS-4	SANGAMON	36	14	CONTRACT NO. 72D58	
PLOT SCALE = 100.0000' / IN.		CHECKED - PJM	REVISED -		SCALE:	SHEET NO. 14 OF 36 SHEETS	STA.	TO STA.	ILLINOIS FED. AID PROJECT		
PLOT DATE = Feb-23-2010 11:34:53AM		DATE - 11/27/06	REVISED -								