



PLAN	SURVEYED	DATE
	PLOTTED	
	CHECKED	
	BY	
	NO.	
	NOTE BOOK	
	NO.	
	FILE NAME	

PROFILE	SURVEYED	DATE
	PLOTTED	
	CHECKED	
	BY	
	NO.	
	NOTE BOOK	
	NO.	
	FILE NAME	

10-14-2009 16:18:58 BONDHJUD C:\IC-WORKSPACE\BONDHJUD\N-FS-004\JD-TRANS.07-2292-28866-001\CIVIL\CA0\99 ALL CONTRACTS\CONV\SHEET'S CONTRACT 03\DRN\11-1700.DGN

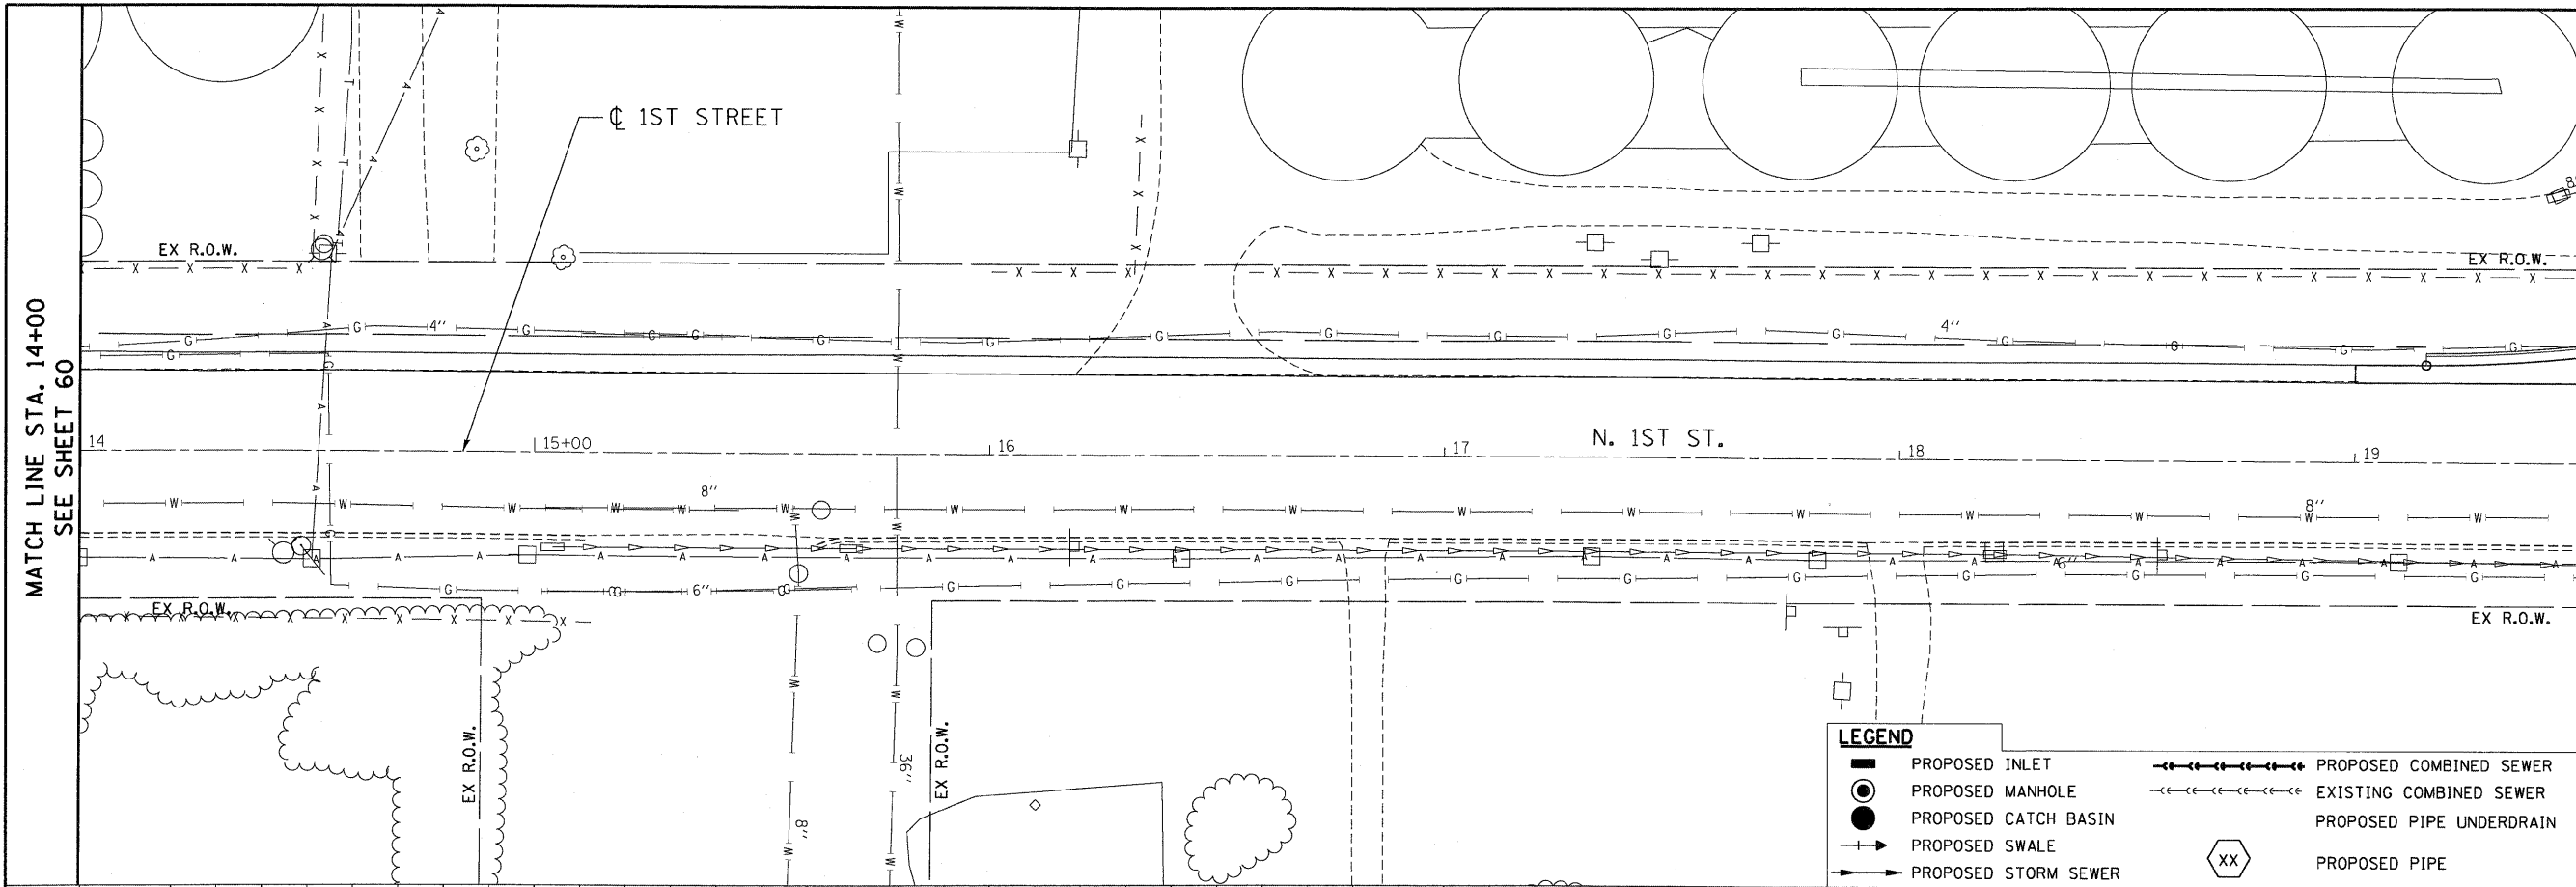

LEGEND	
	PROPOSED INLET
	PROPOSED MANHOLE
	PROPOSED CATCH BASIN
	PROPOSED SWALE
	PROPOSED STORM SEWER
	PROPOSED COMBINED SEWER
	EXISTING COMBINED SEWER
	PROPOSED PIPE UNDERDRAIN
	PROPOSED PIPE
	PROPOSED STRUCTURE
	EXISTING MANHOLE
	EDS = EX. DRAINAGE STUCT.
	DS = PROP. DRAINAGE STUCT.
	CS = COMBINED SEWER

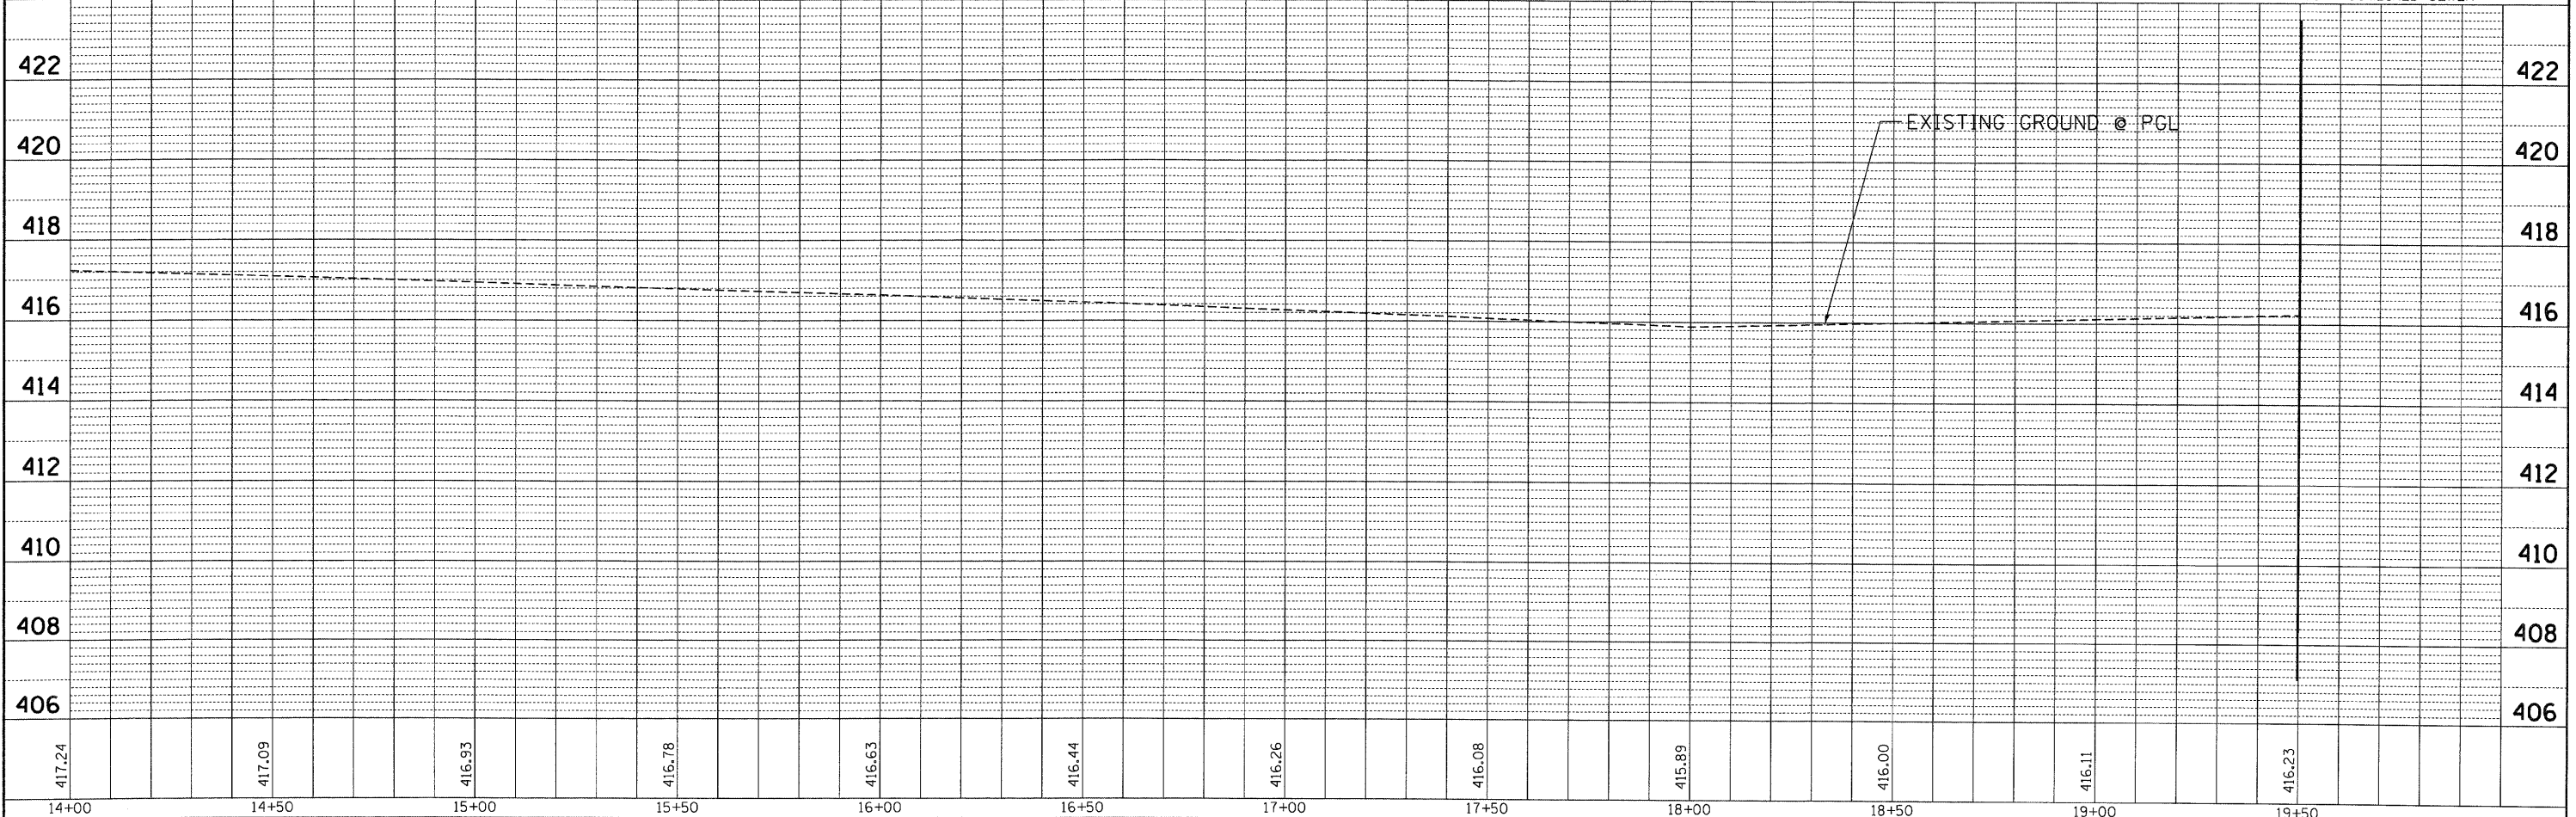

FILE NAME =	USER NAME = #USER#	DESIGNED - JB	REVISED -	<b>STATE OF ILLINOIS</b> <b>DEPARTMENT OF TRANSPORTATION</b> I-70 CONNECTION	<b>PROPOSED DRAINAGE PLAN &amp; PROFILE</b> <b>1ST STREET</b> <b>STA. 14 + 00.00 TO STA. 19 + 50.00</b>	F.A.P. RTE.	SECTION	COUNTY	TOTAL SHEETS	SHEET NO.
#FILEL#	DRAWN - JB	REVISED -	9153			82-1K	ST. CLAIR	107	61	
PLOT SCALE = #SCALE#	CHECKED - ACL	REVISED -	FED. ROAD DIST. NO. ILLINOIS FED. AID PROJECT							
PLOT DATE = #DATE#	DATE - 10/09/09	REVISED -								



SCALE: HORIZ. 1"=20' VERT. 1"=2' STA. TO STA.