
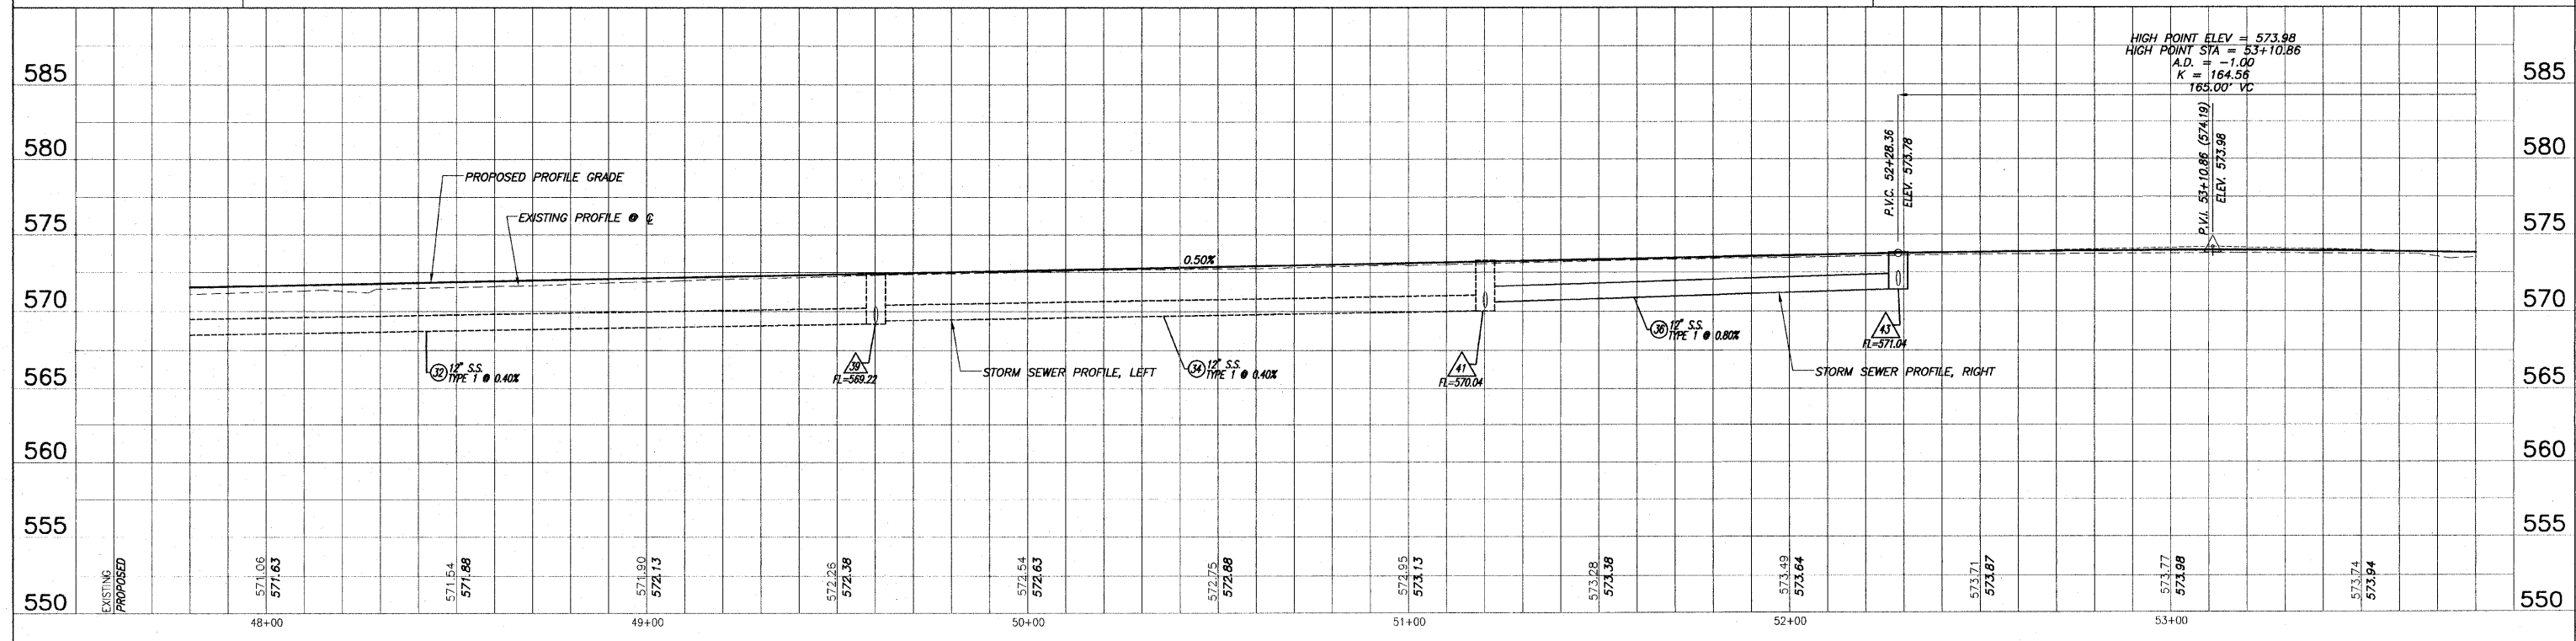


F.A.U. ROUTE	SECTION	COUNTY	TOTAL SHEETS	SHEET NUMBER
9168	05-00035-00-FP 05-00056-00-FP	ST. CLAIR	60	12
STA 24+17.37 TO		STA. 79+10.00		
FEDERAL AID PROJECT		CONTRACT 97360		

- LEGEND**
- (T) TREE
 - (S) SHRUB
 - (M) MAILBOX
 - (SI) STORM INLET
 - (C) CULVERT
 - (TP) TELEPHONE PEDESTAL
 - (CTV) CABLE TV PEDESTAL
 - (EP) ELECTRIC PEDESTAL
 - (GV) GAS VALVE
 - (S) SIGN
 - (SS) STREET SIGN
 - (RT) ROADWAY/TRAFFIC SIGN
 - (PP) POWER POLE
 - (GW) GUY WIRE
 - (WM) WATER METER
 - (WV) WATER VALVE
 - (FOWP) FIBER OPTIC WARNING POST
 - (F) FENCE
 - (SFL) SWALE FLOWLINE
 - (EP) EDGE OF PAVEMENT
 - (OE) OVERHEAD ELECTRIC
 - (UE) UNDERGROUND ELECTRIC
 - (FO) UNDERGROUND FIBER OPTIC
 - (T) UNDERGROUND TELEPHONE
 - (G) UNDERGROUND GAS MAIN
 - (W) WATER MAIN
 - (SAN) SANITARY SEWER

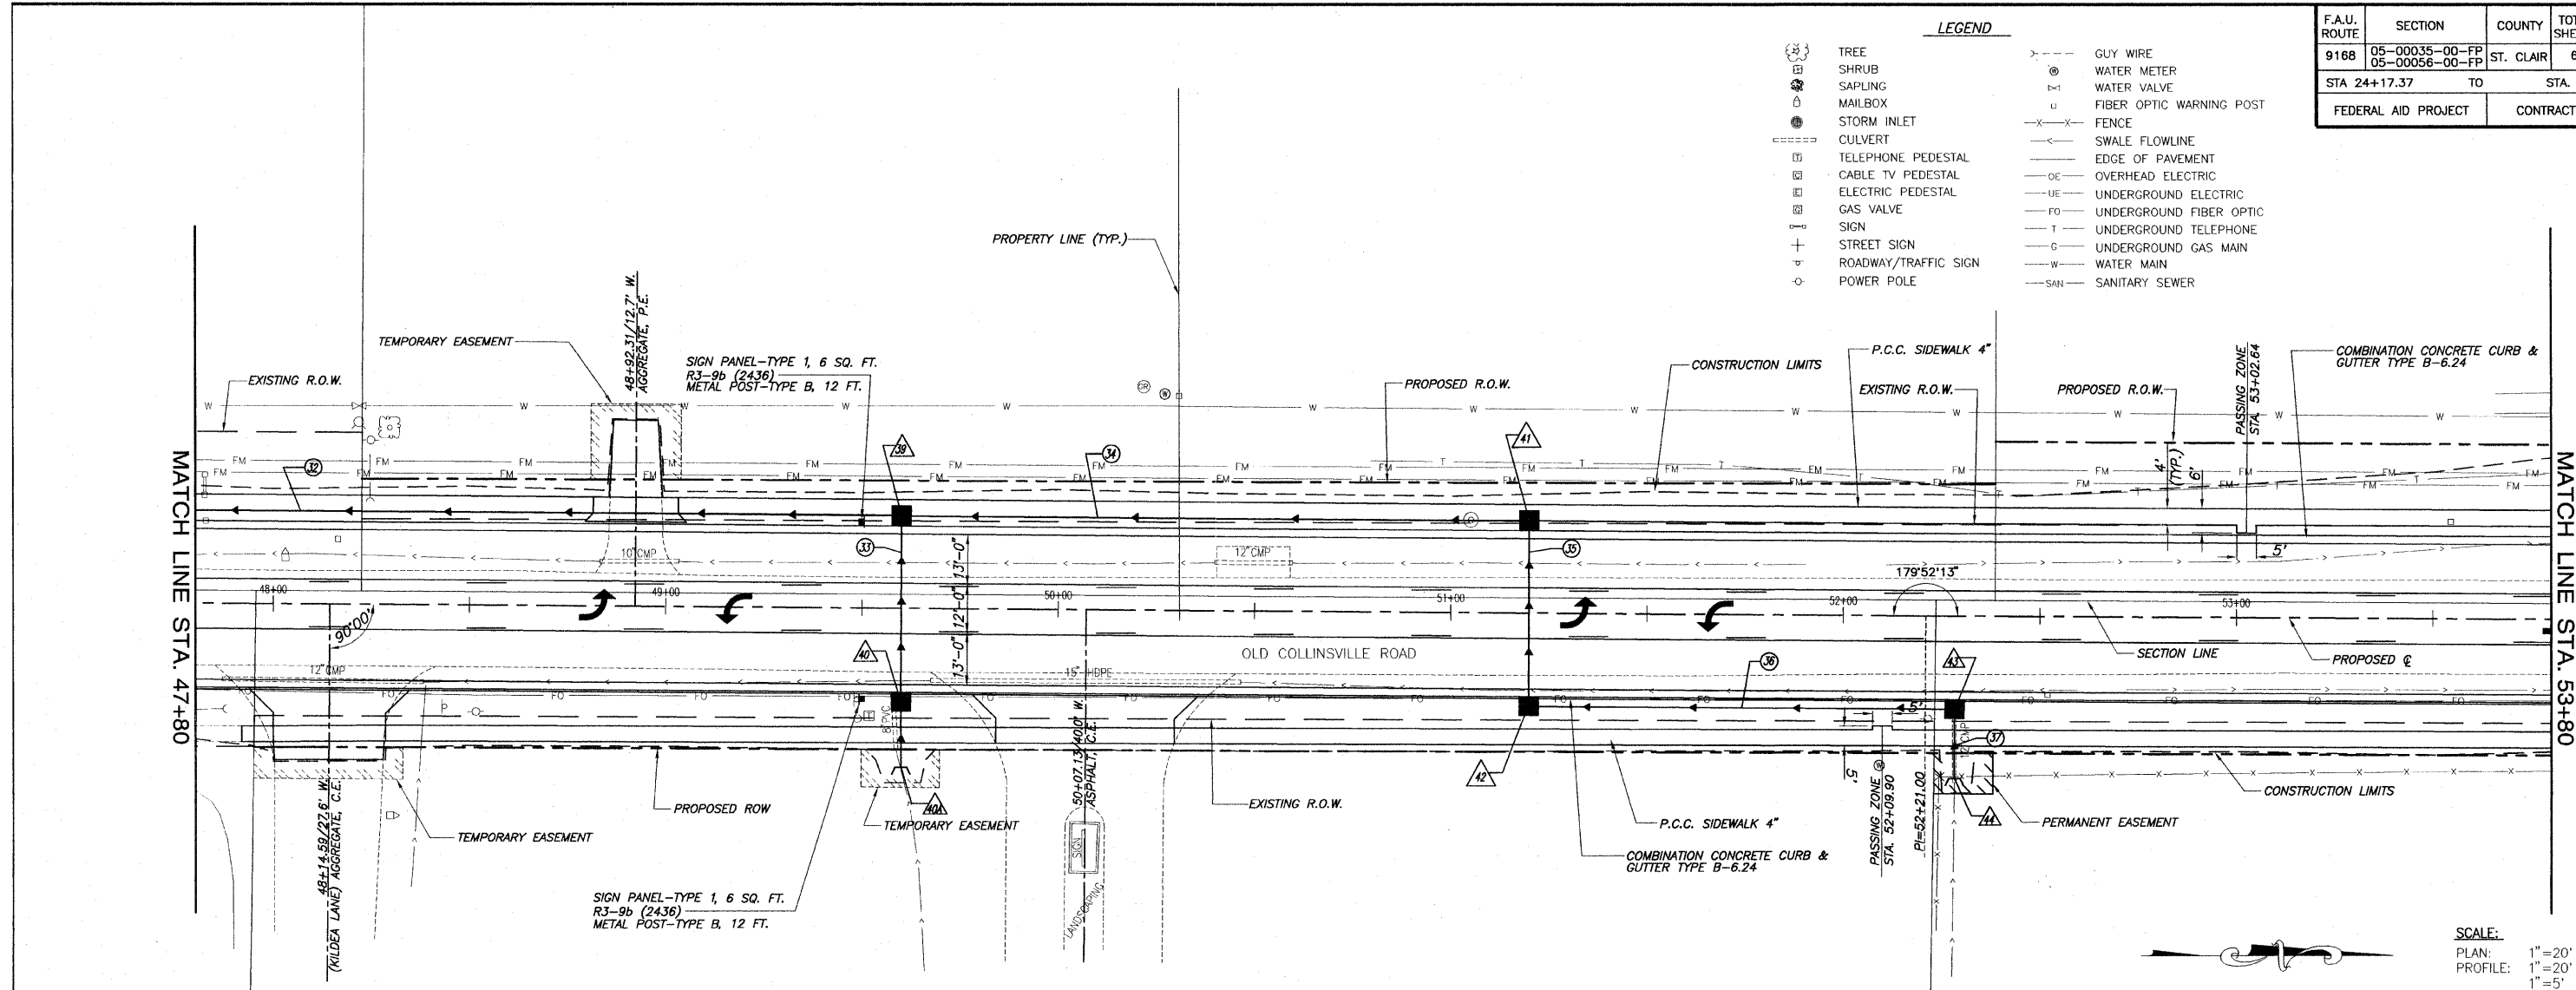

ROADWAY PLAN AND PROFILE OLD COLLINSVILLE ROAD IMPROVEMENTS
SECTION 05-00035-00-FP & 05-00056-00-FP ST. CLAIR COUNTY, ILLINOIS

E:\11205 - Option - Old Collinsville Roadway\12_27_09\11205.dwg, 4/11/2010 1:02:13 PM, Printed by H.A.L.