


F.A. RTE.	SECTION	COUNTY	TOTAL SHEETS	SHEET NO.
9173	04-00080-06-PV	ST. CLAIR	144	56
STA. 165+00		TO STA. 180+00		
FED. ROAD DIST. NO.		ILLINOIS	FED. AID PROJECT	
STORM SEWER & DRAINAGE PLAN				
CONTRACT NO: 97418				

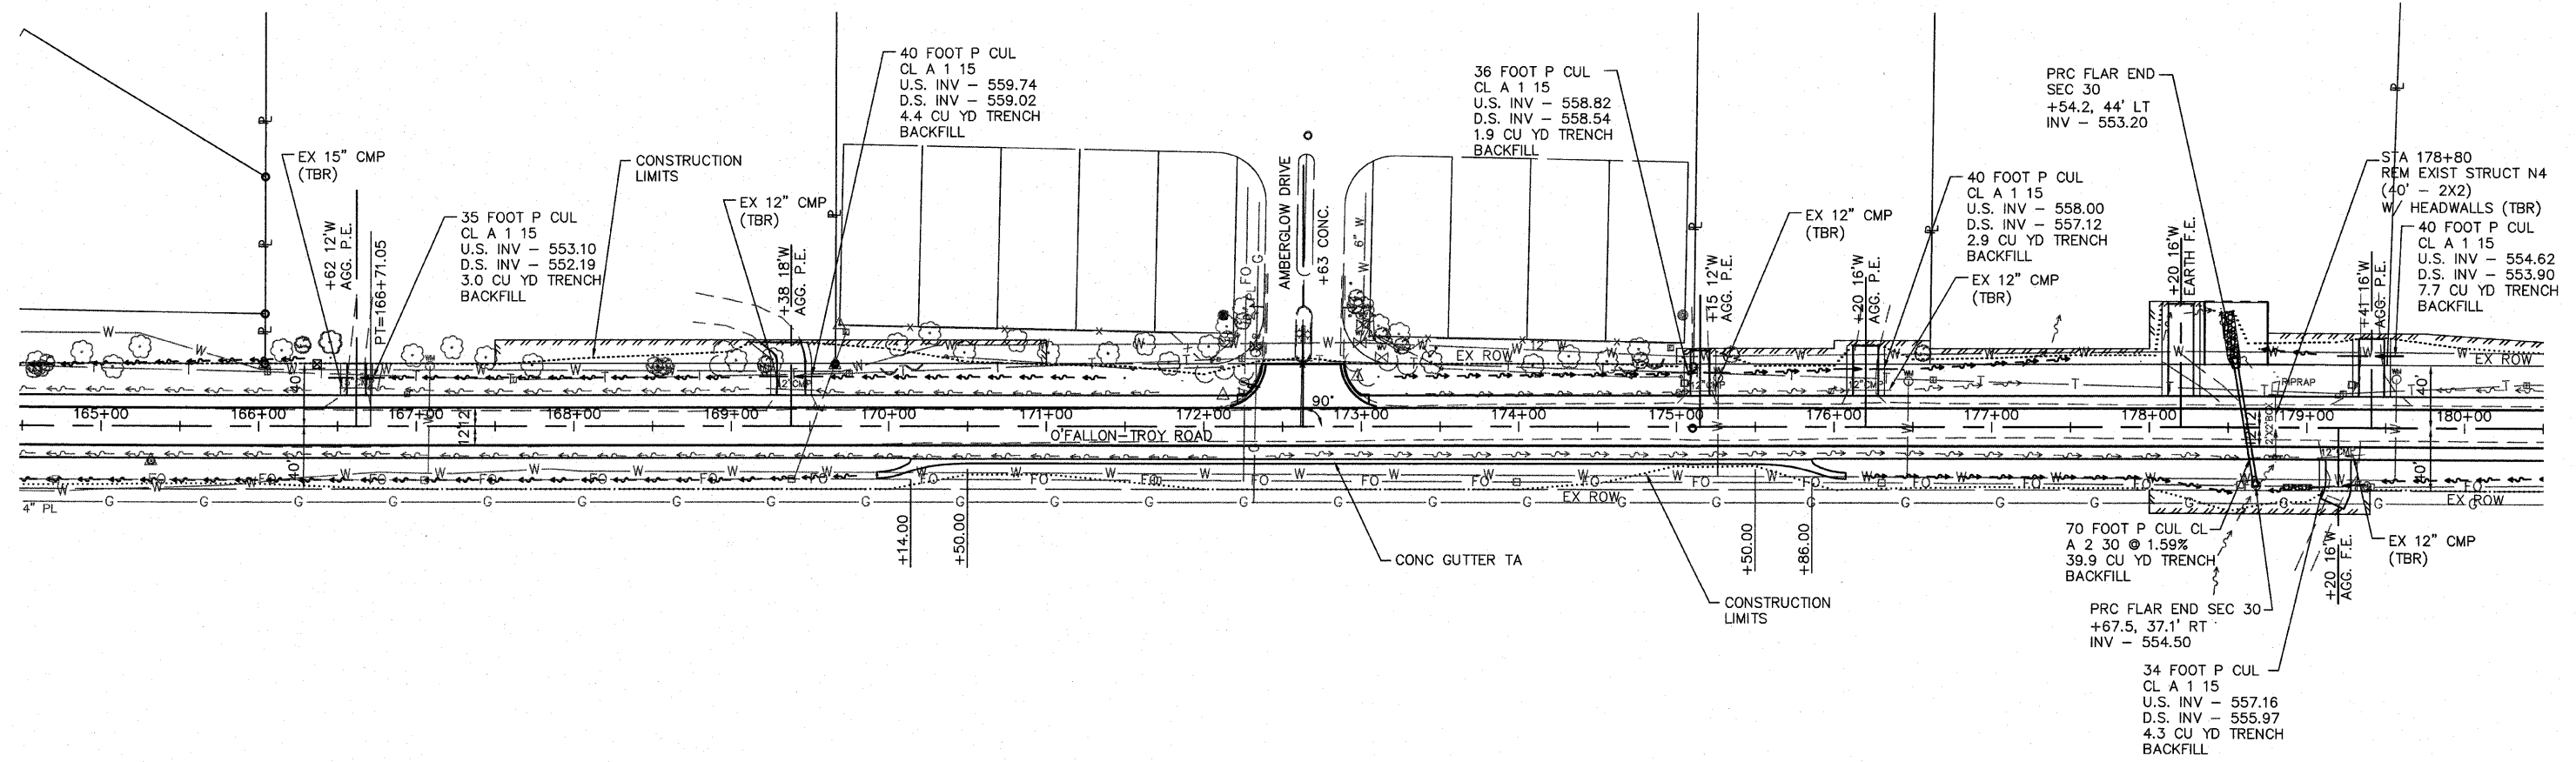

CP #14768 - IRON PIPE
 STA. 169+65.91, 39.31' LT.
 ELEV. 574.27

CP #1157 - IRON PIPE
 STA. 172+12.34, 20.13' LT
 ELEV. 562.48

CP #1419 - IRON PIPE
 STA. 172+97.65, 32.09' LT
 ELEV. 561.73

