


F.A. RTE.	SECTION	COUNTY	TOTAL SHEETS	SHEET NO.
9173	04-00080-06-PV	ST. CLAIR	144	60
STA. 195+00		TO STA. 210+00		
FED. ROAD DIST. NO.		ILLINOIS	FED. AID PROJECT	
STORM SEWER & DRAINAGE PLAN				
CONTRACT NO: 97418				

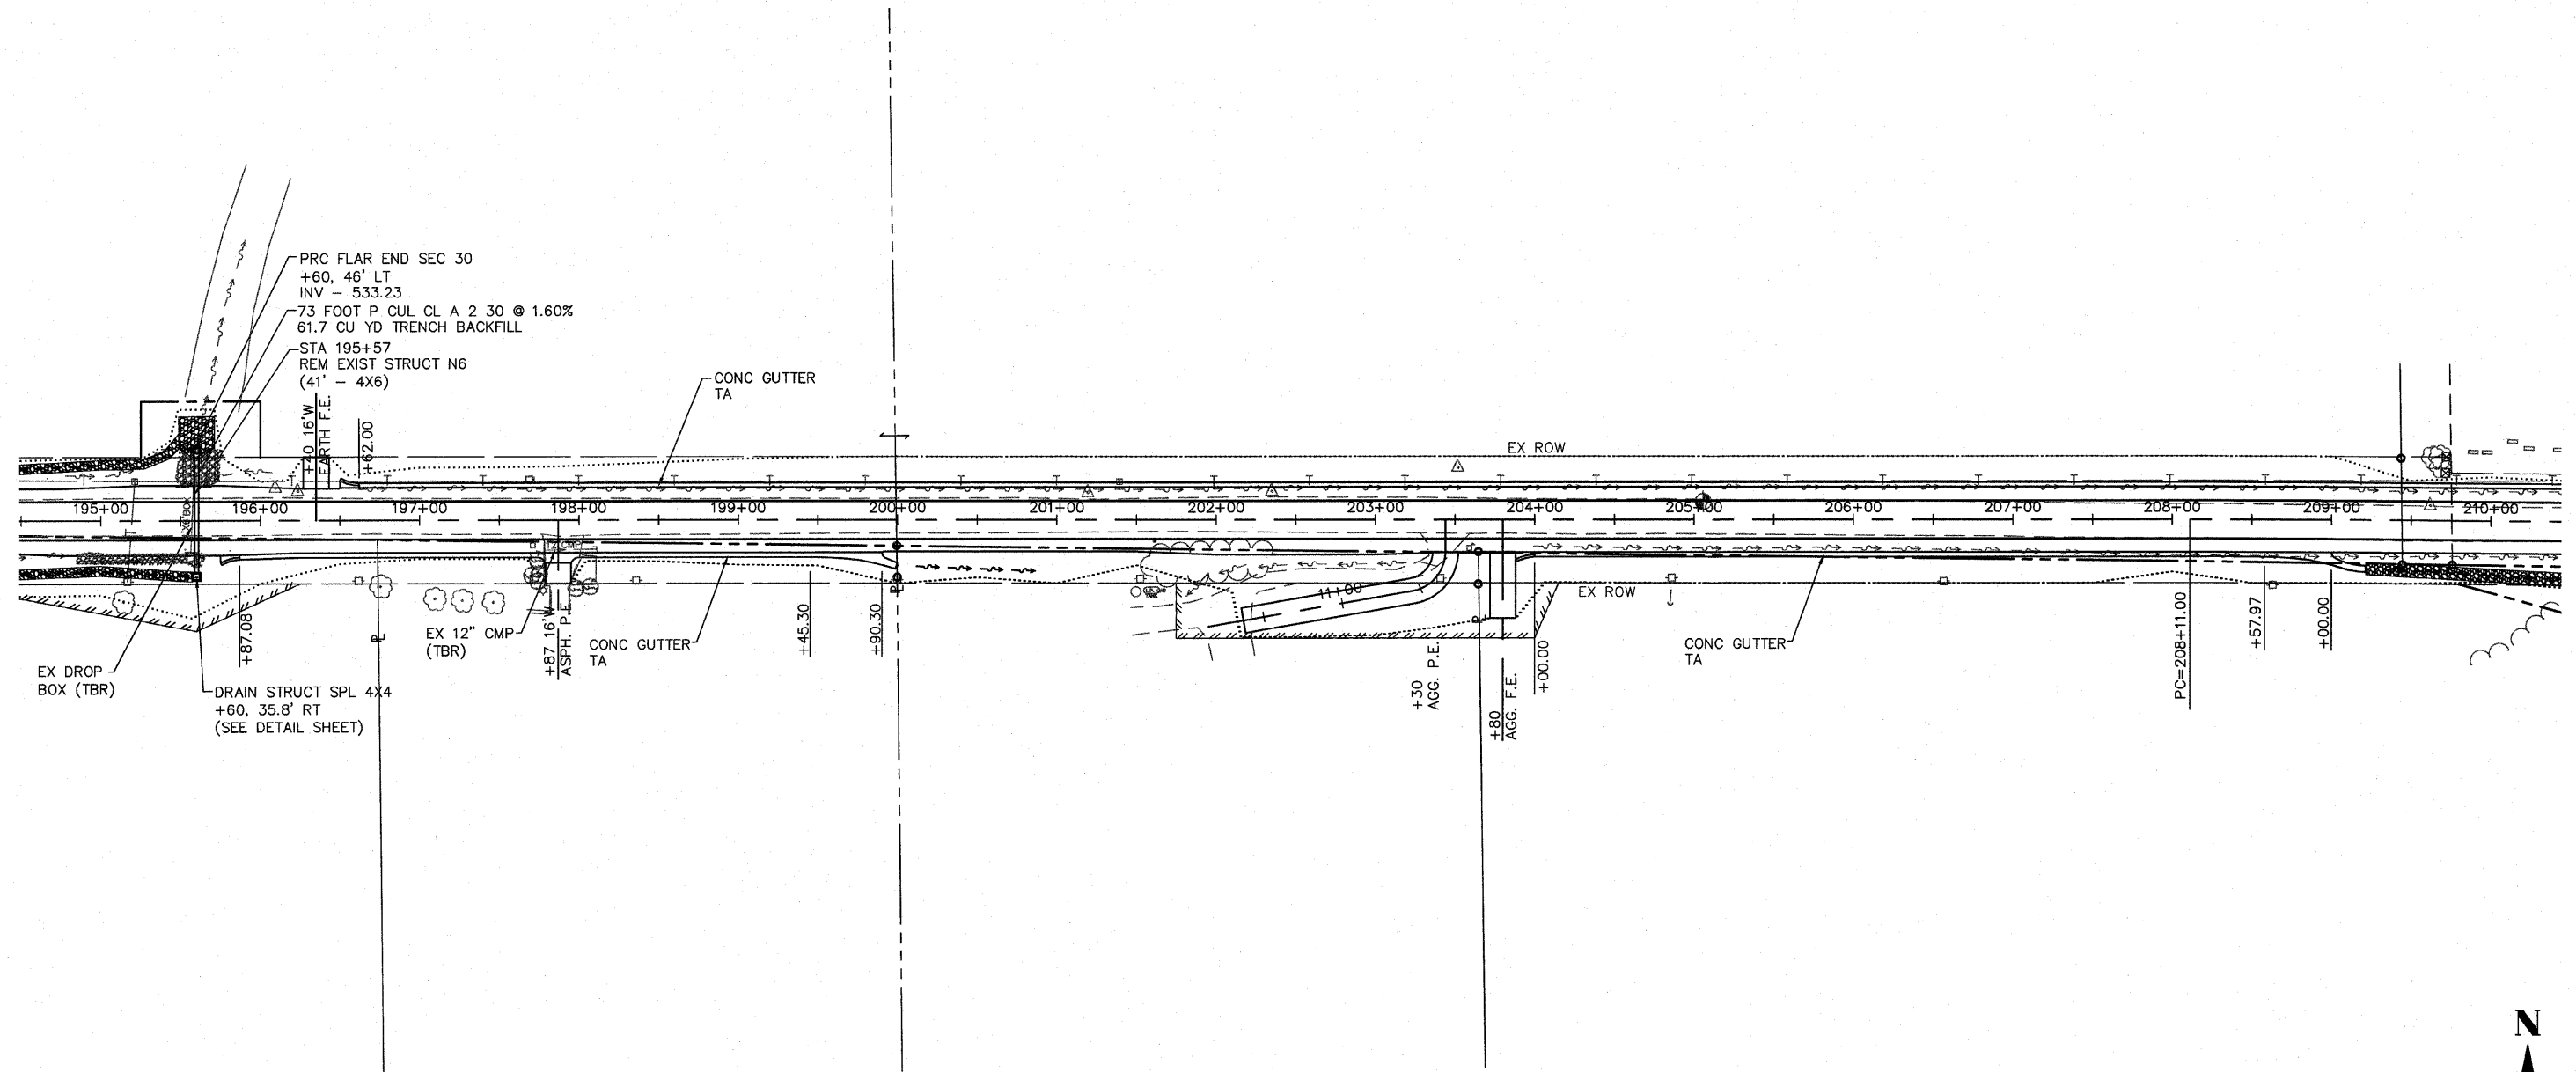

CP #1888 - IRON PIPE
 STA. 196+23.62, 18.42' LT.
 ELEV. 540.95

CP #1889 - IRON PIPE
 STA. 203+51.85, 33.01' LT
 ELEV. 525.93

