


F.A. RTE.	SECTION	COUNTY	TOTAL SHEETS	SHEET NO.
351	3277R	COOK	541	356
STA.		TO STA.		
FED. ROAD DIST. NO.		ILLINOIS FED. AID PROJECT		
CONTRACT NO. 60774				

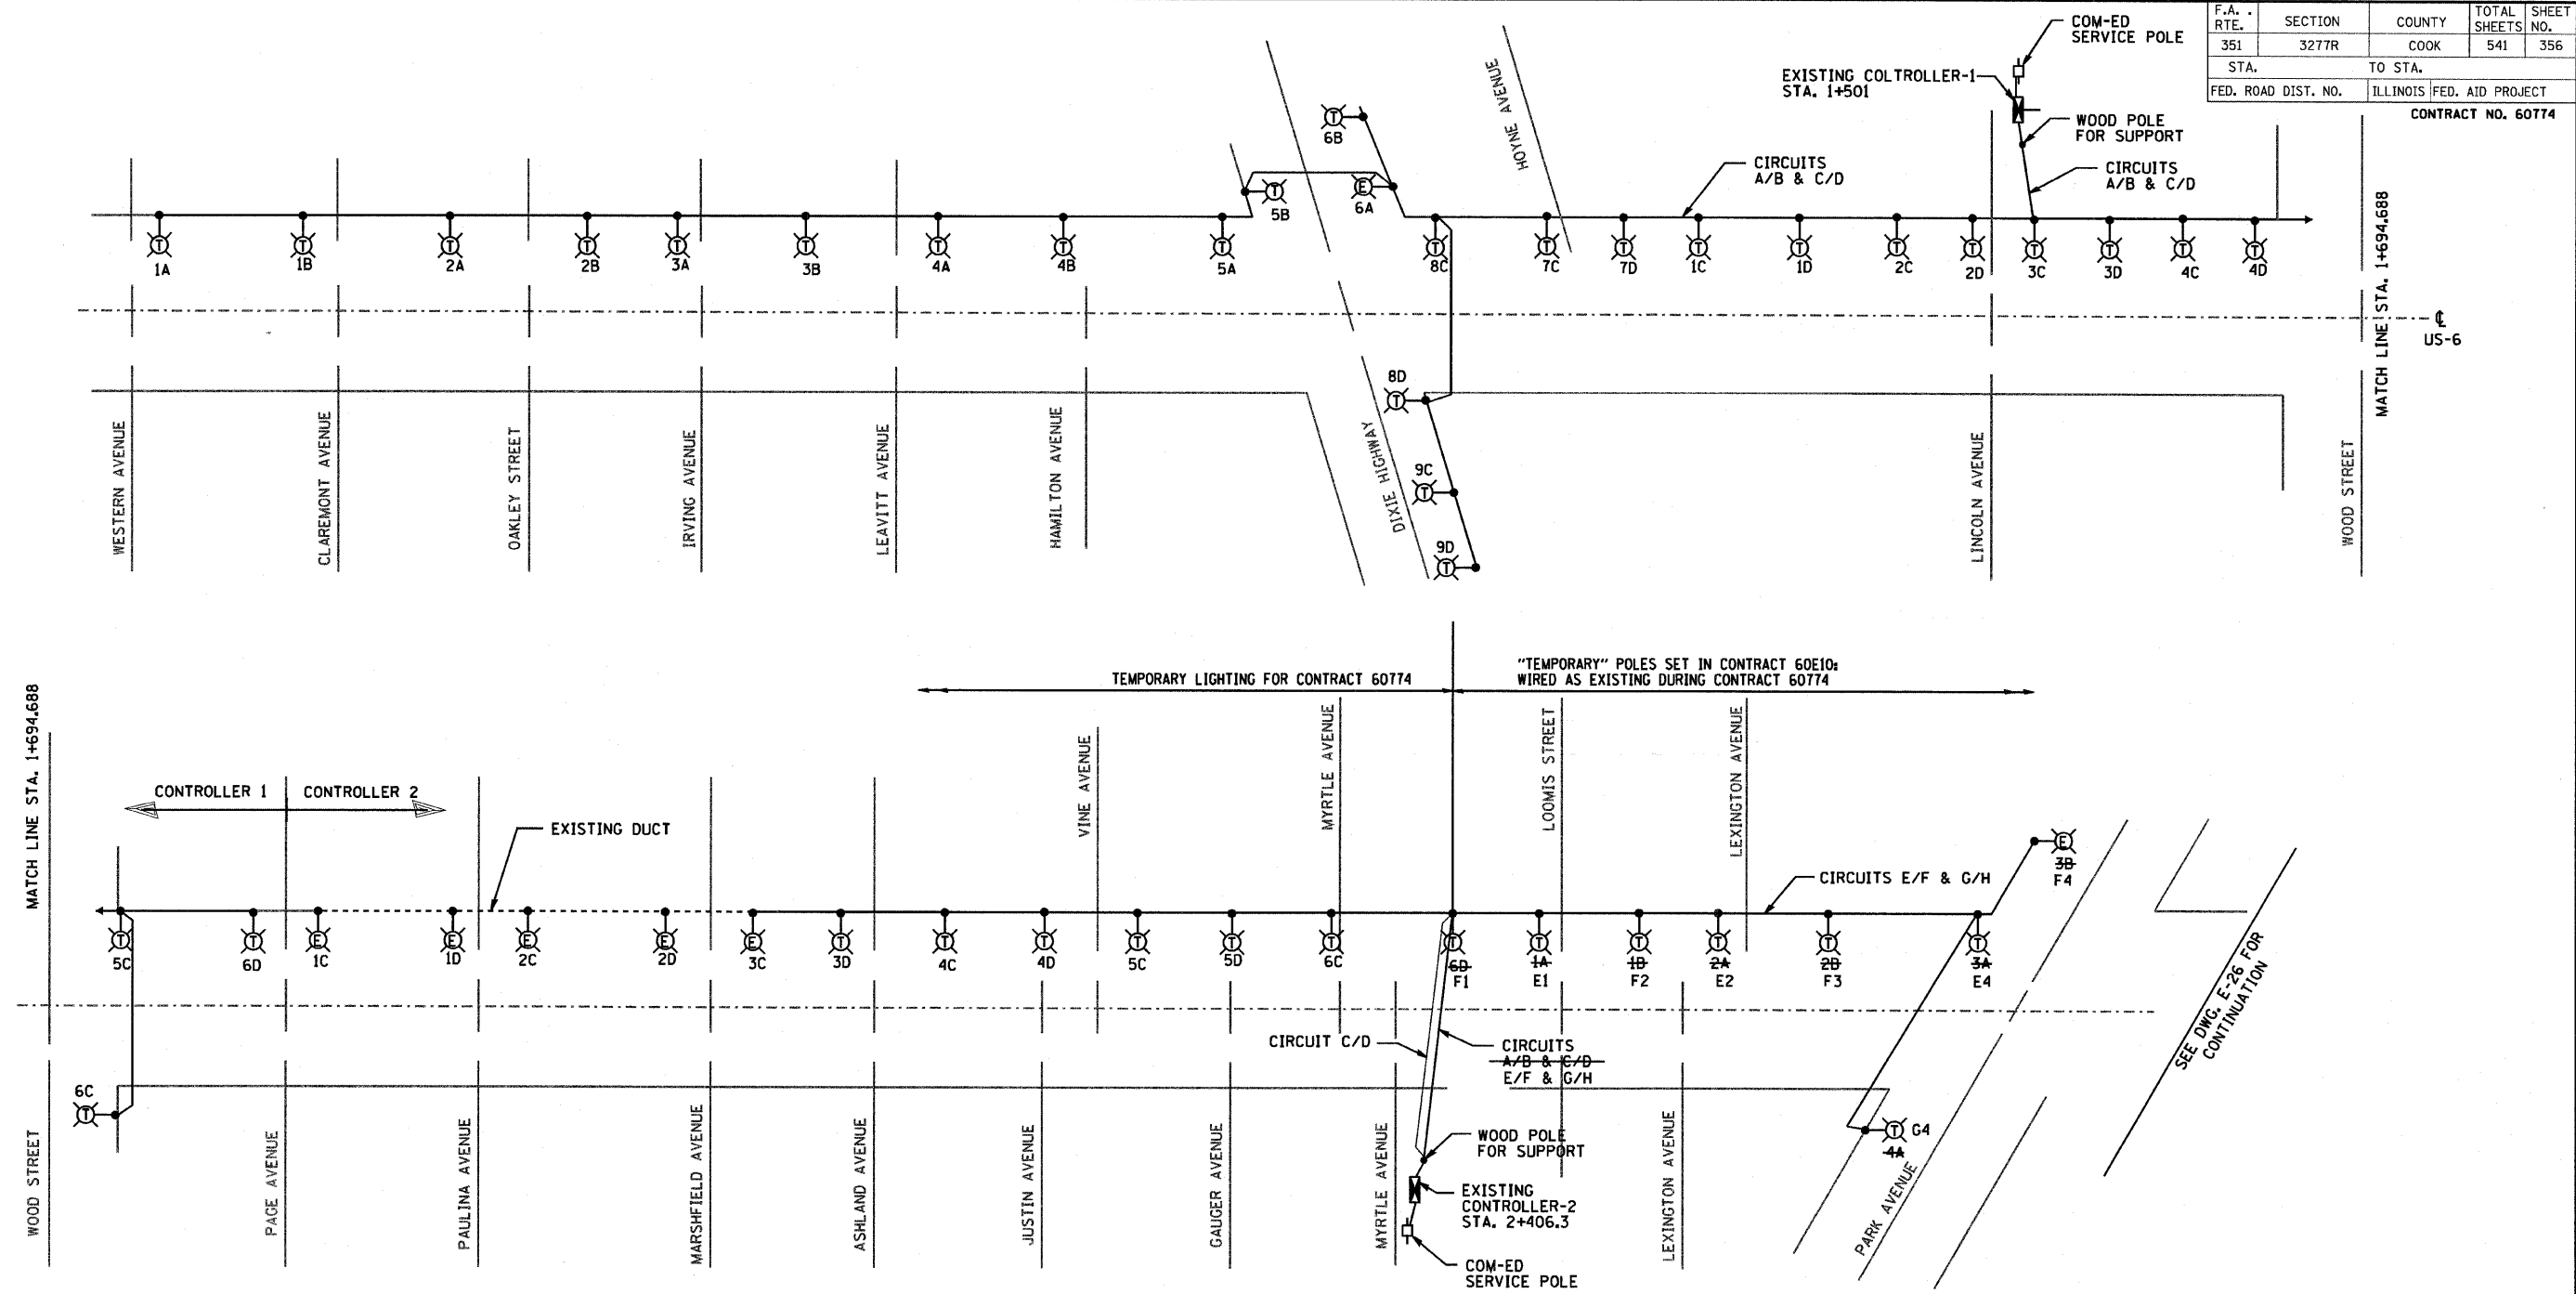

LOAD TABLE

CONTROLLER 1		
CIRCUIT NO.	LOAD	CURRENT
A	2740W	11.41A
B	2800W	11.66A
C	4640W	19.33
D	4165W	17.35A

CONTROLLER 2		
CIRCUIT NO.	LOAD	CURRENT
A	1900W	7.91A
B	1425W	5.93A
C	2520W	10.5A
D	3105W	12.93A

LEGEND:

- ⊕ LIGHT POLE, WOOD, WITH 14.5 M MAST ARM
- ⊕ EXISTING LIGHT POLE
- ⊕ EXISTING LIGHTING CONTROLLER
- ⊕ ComEd SERVICE POLE
- LIGHT POLE, WOOD, FOR SUPPORT

REVISIONS	
NAME	DATE

DRAWING No. E-27

ILLINOIS DEPARTMENT OF TRANSPORTATION
 US RTE 6 FROM I-294 TO IL RTE 1
 SINGLE LINE DIAGRAM
 TEMPORARY LIGHTING
 SHEET '1' OF '2'