
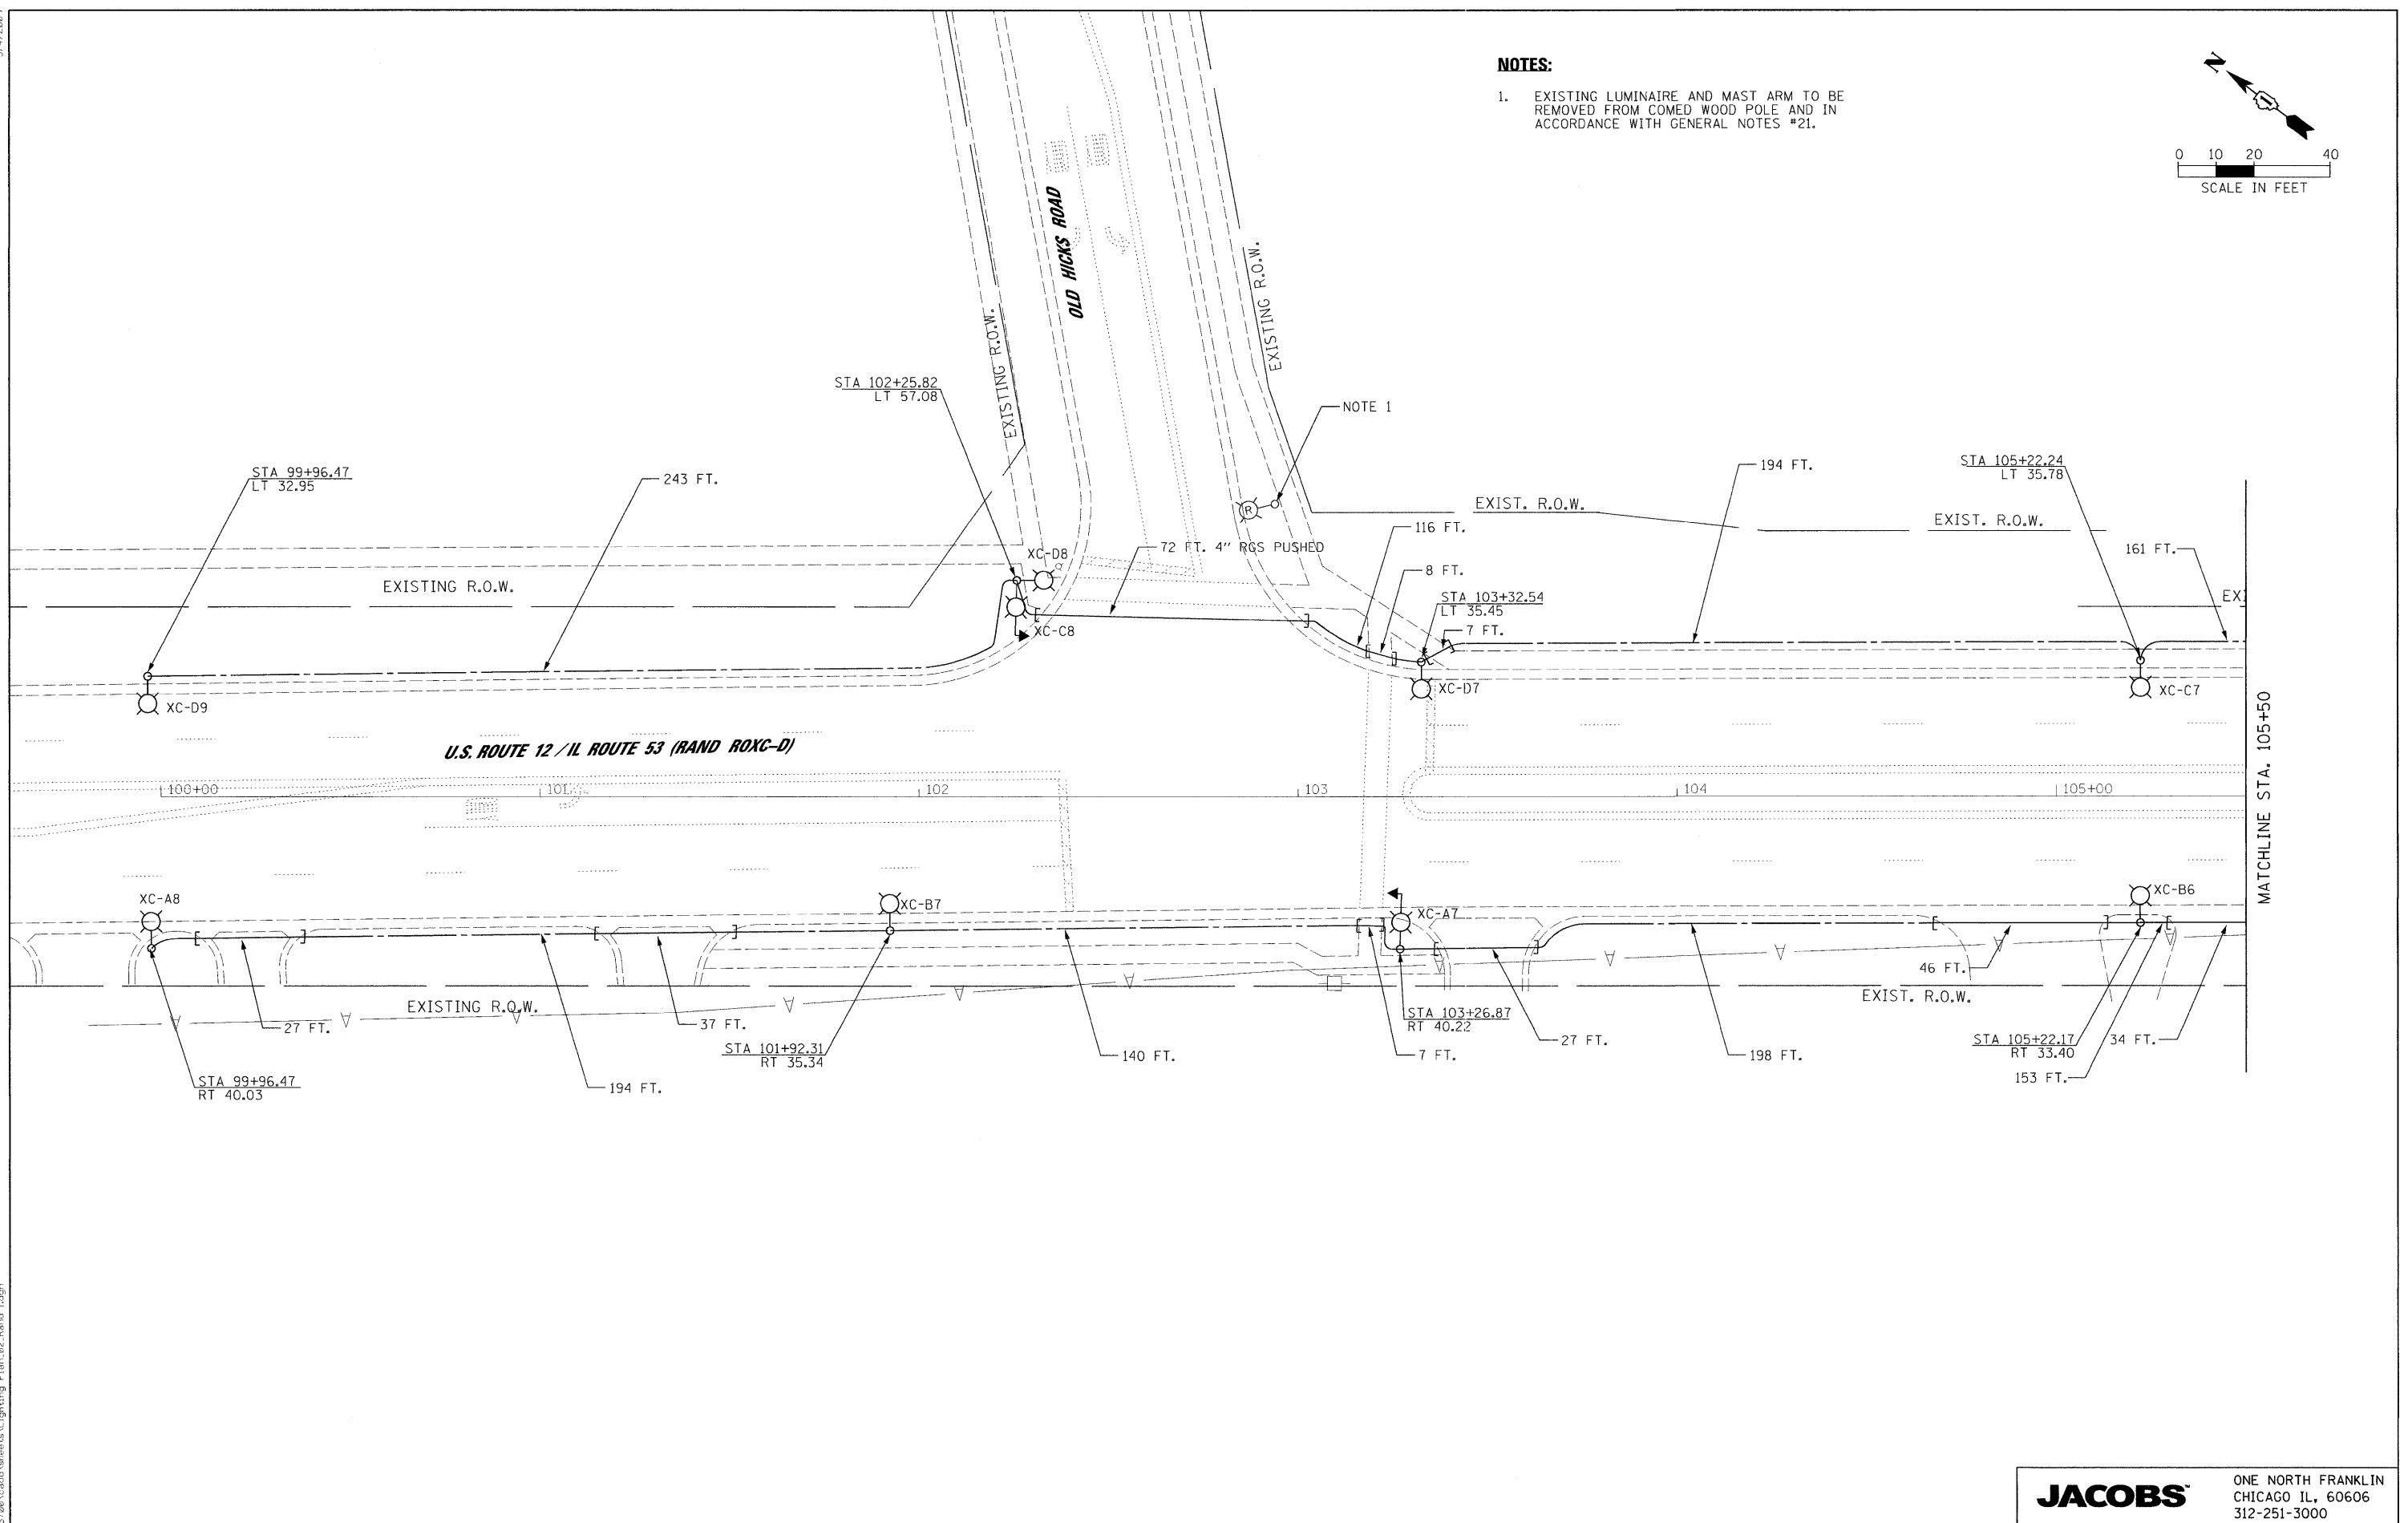


3/4/2009

NOTES:

- 1. EXISTING LUMINAIRE AND MAST ARM TO BE REMOVED FROM COMED WOOD POLE AND IN ACCORDANCE WITH GENERAL NOTES #21.

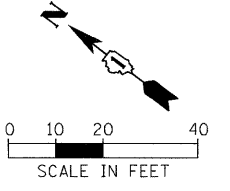

FILE NAME = Lighting Plan_02_Rand 1.dgn	USER NAME = #USER#	DESIGNED - HS	REVISED -
		DRAWN - MJO	REVISED -
		CHECKED - CDS	REVISED -
		DATE - 1/22/2009	REVISED -

PLOT SCALE = #SCALE#	DATE - 1/22/2009	DESIGNED - HS	REVISED -
		DRAWN - MJO	REVISED -
		CHECKED - CDS	REVISED -
		DATE - 1/22/2009	REVISED -

**STATE OF ILLINOIS
DEPARTMENT OF TRANSPORTATION**

PROPOSED LIGHTING PLAN			
SCALE: 1"=20'	SHEET NO.	OF SHEETS	STA. 100+00 TO STA. 105+00

JACOBS		ONE NORTH FRANKLIN CHICAGO IL, 60606 312-251-3000		
F.A.P. RTE. 334	SECTION 2008-08-31	COUNTY COOK	TOTAL SHEETS 81	SHEET NO. 46
FED. ROAD DIST. NO.		ILLINOIS FED. AID PROJECT		
CONTRACT NO. 60F87				

pr_2009\cadd\plans\Lighting Plan_02_Rand 1.dgn