
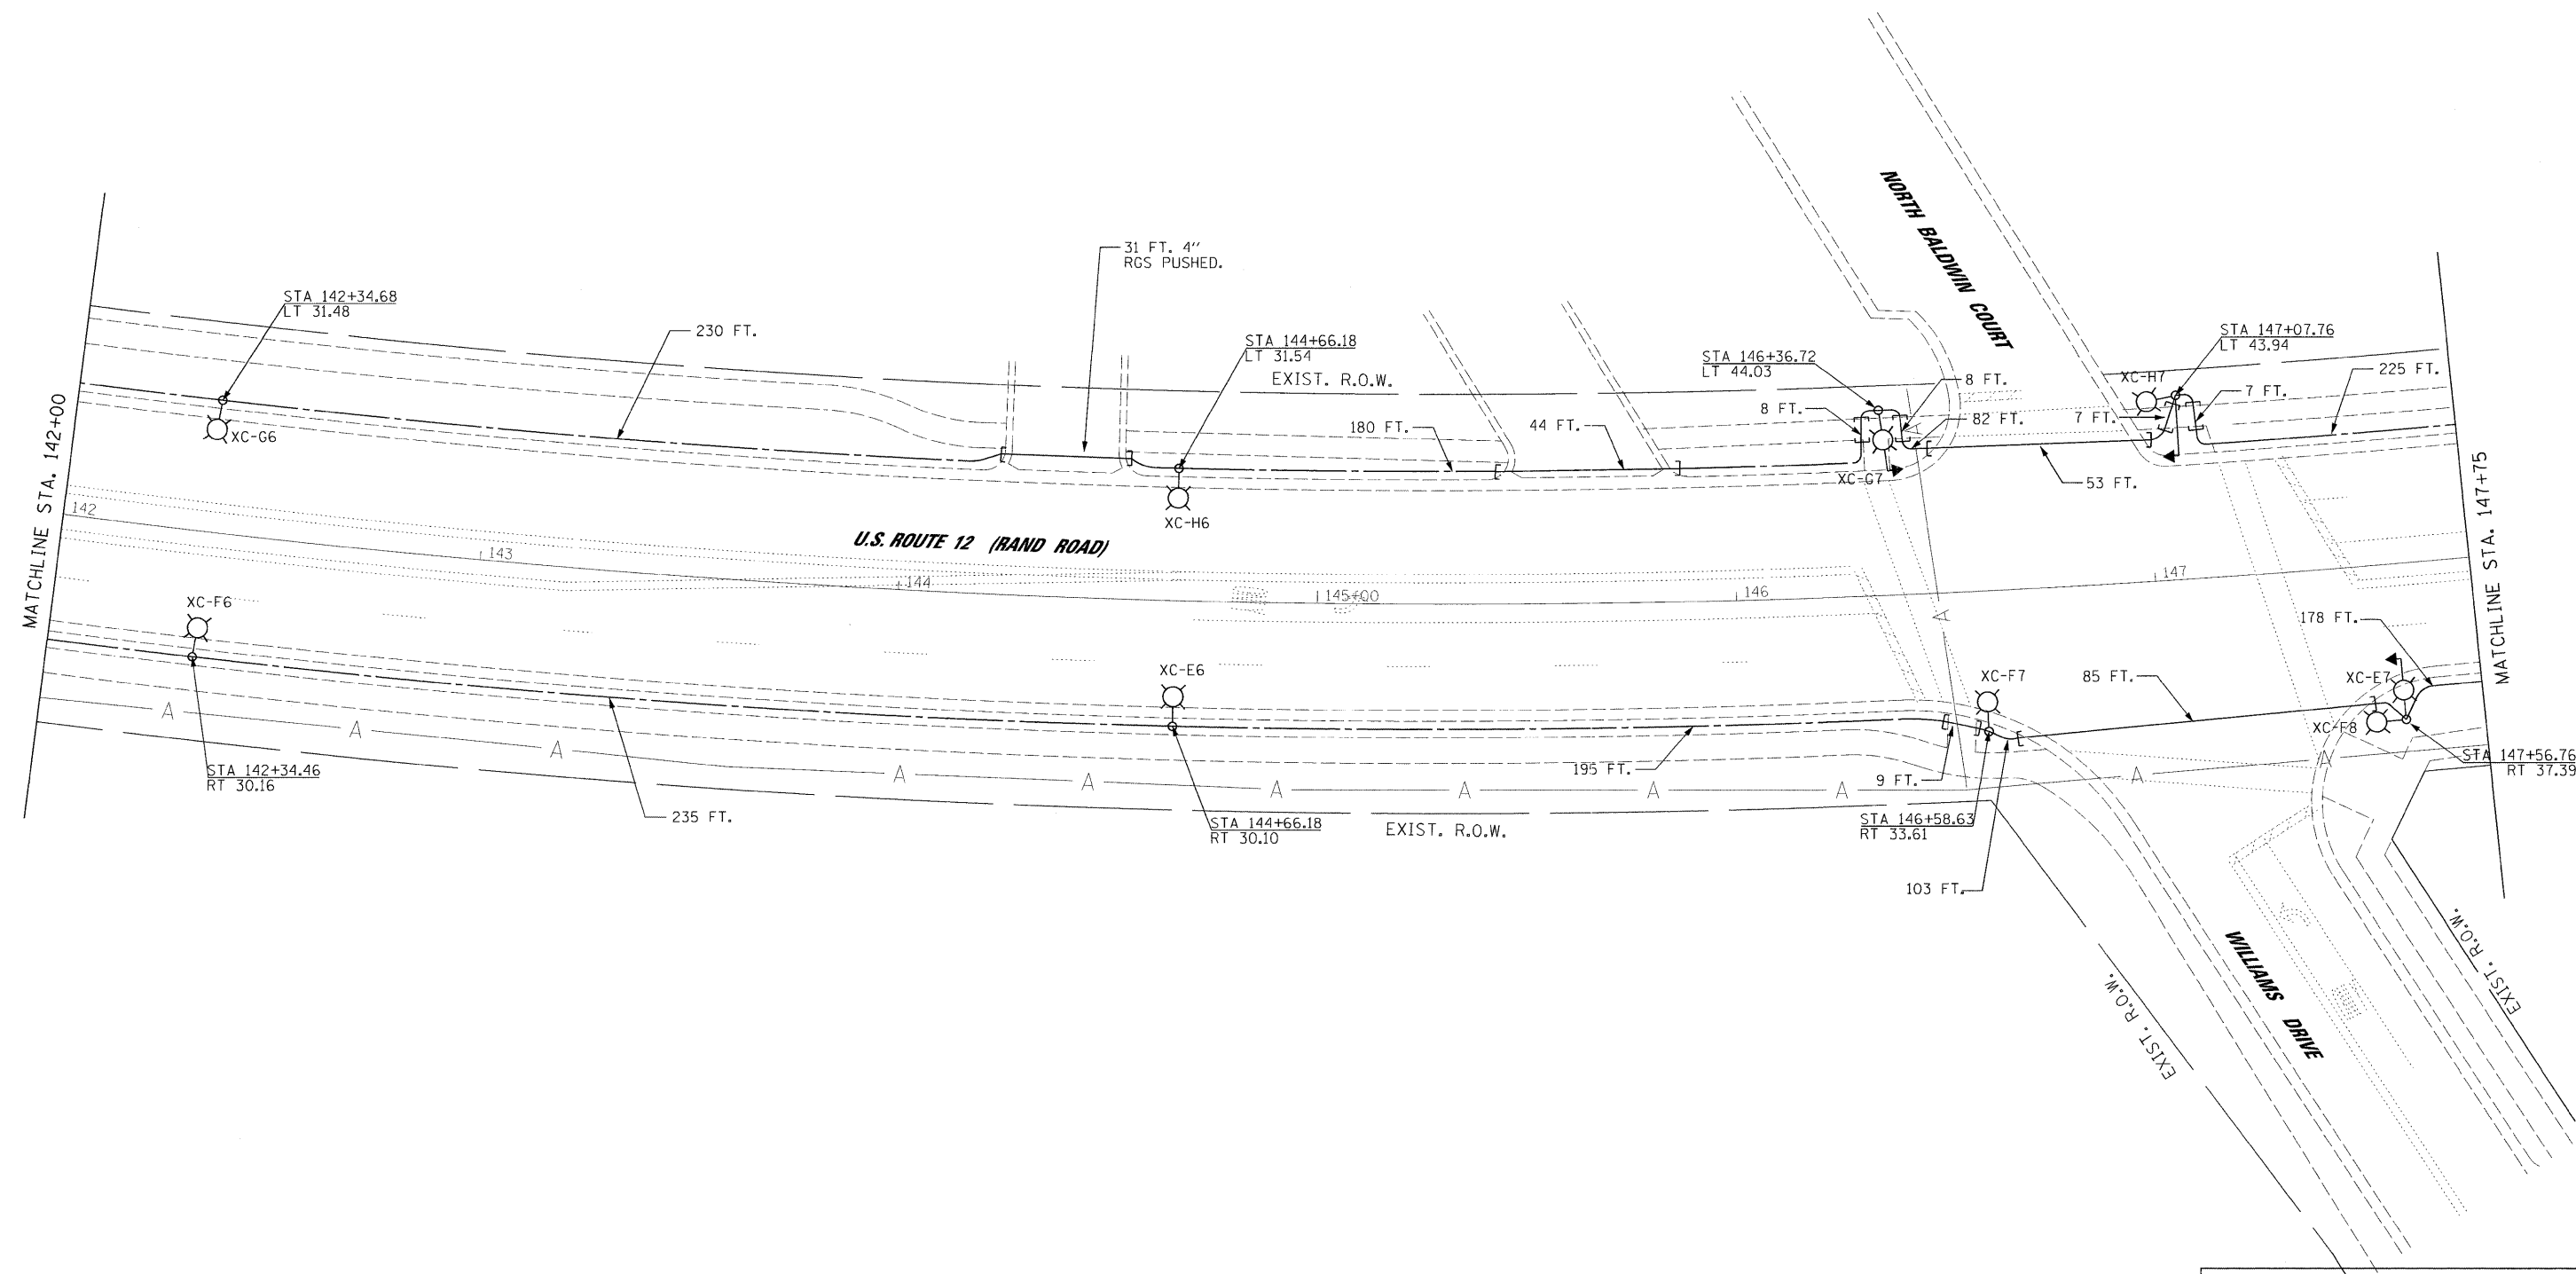


3/4/2009

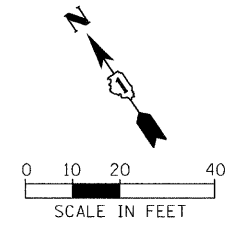

px\_2009\09\03\20\Acadd\Sheets\Lighting Plan\_10\_Rand 9.dgn

FILE NAME =  
Lighting Plan\_10\_Rand 9.dgn

USER NAME = \*USER\*  
PLOT SCALE = \*SCALE\*  
PLOT DATE = 3/4/2009

DESIGNED - HS  
DRAWN - MJO  
CHECKED - CDS  
DATE - 1/22/2009

REVISED -  
REVISED -  
REVISED -  
REVISED -

**STATE OF ILLINOIS  
DEPARTMENT OF TRANSPORTATION**

**PROPOSED LIGHTING PLAN**

SCALE: 1"=20'    SHEET NO.    OF    SHEETS    STA. 142+00    TO    STA. 147+75

<b>JACOBS</b>		ONE NORTH FRANKLIN CHICAGO IL, 60606 312-251-3000		
F.A.P. RTE. 334	SECTION 2008-08-31	COUNTY COOK	TOTAL SHEETS 81	SHEET NO. 54
FED. ROAD DIST. NO.		ILLINOIS	FED. AID PROJECT	CONTRACT NO. 60F87