
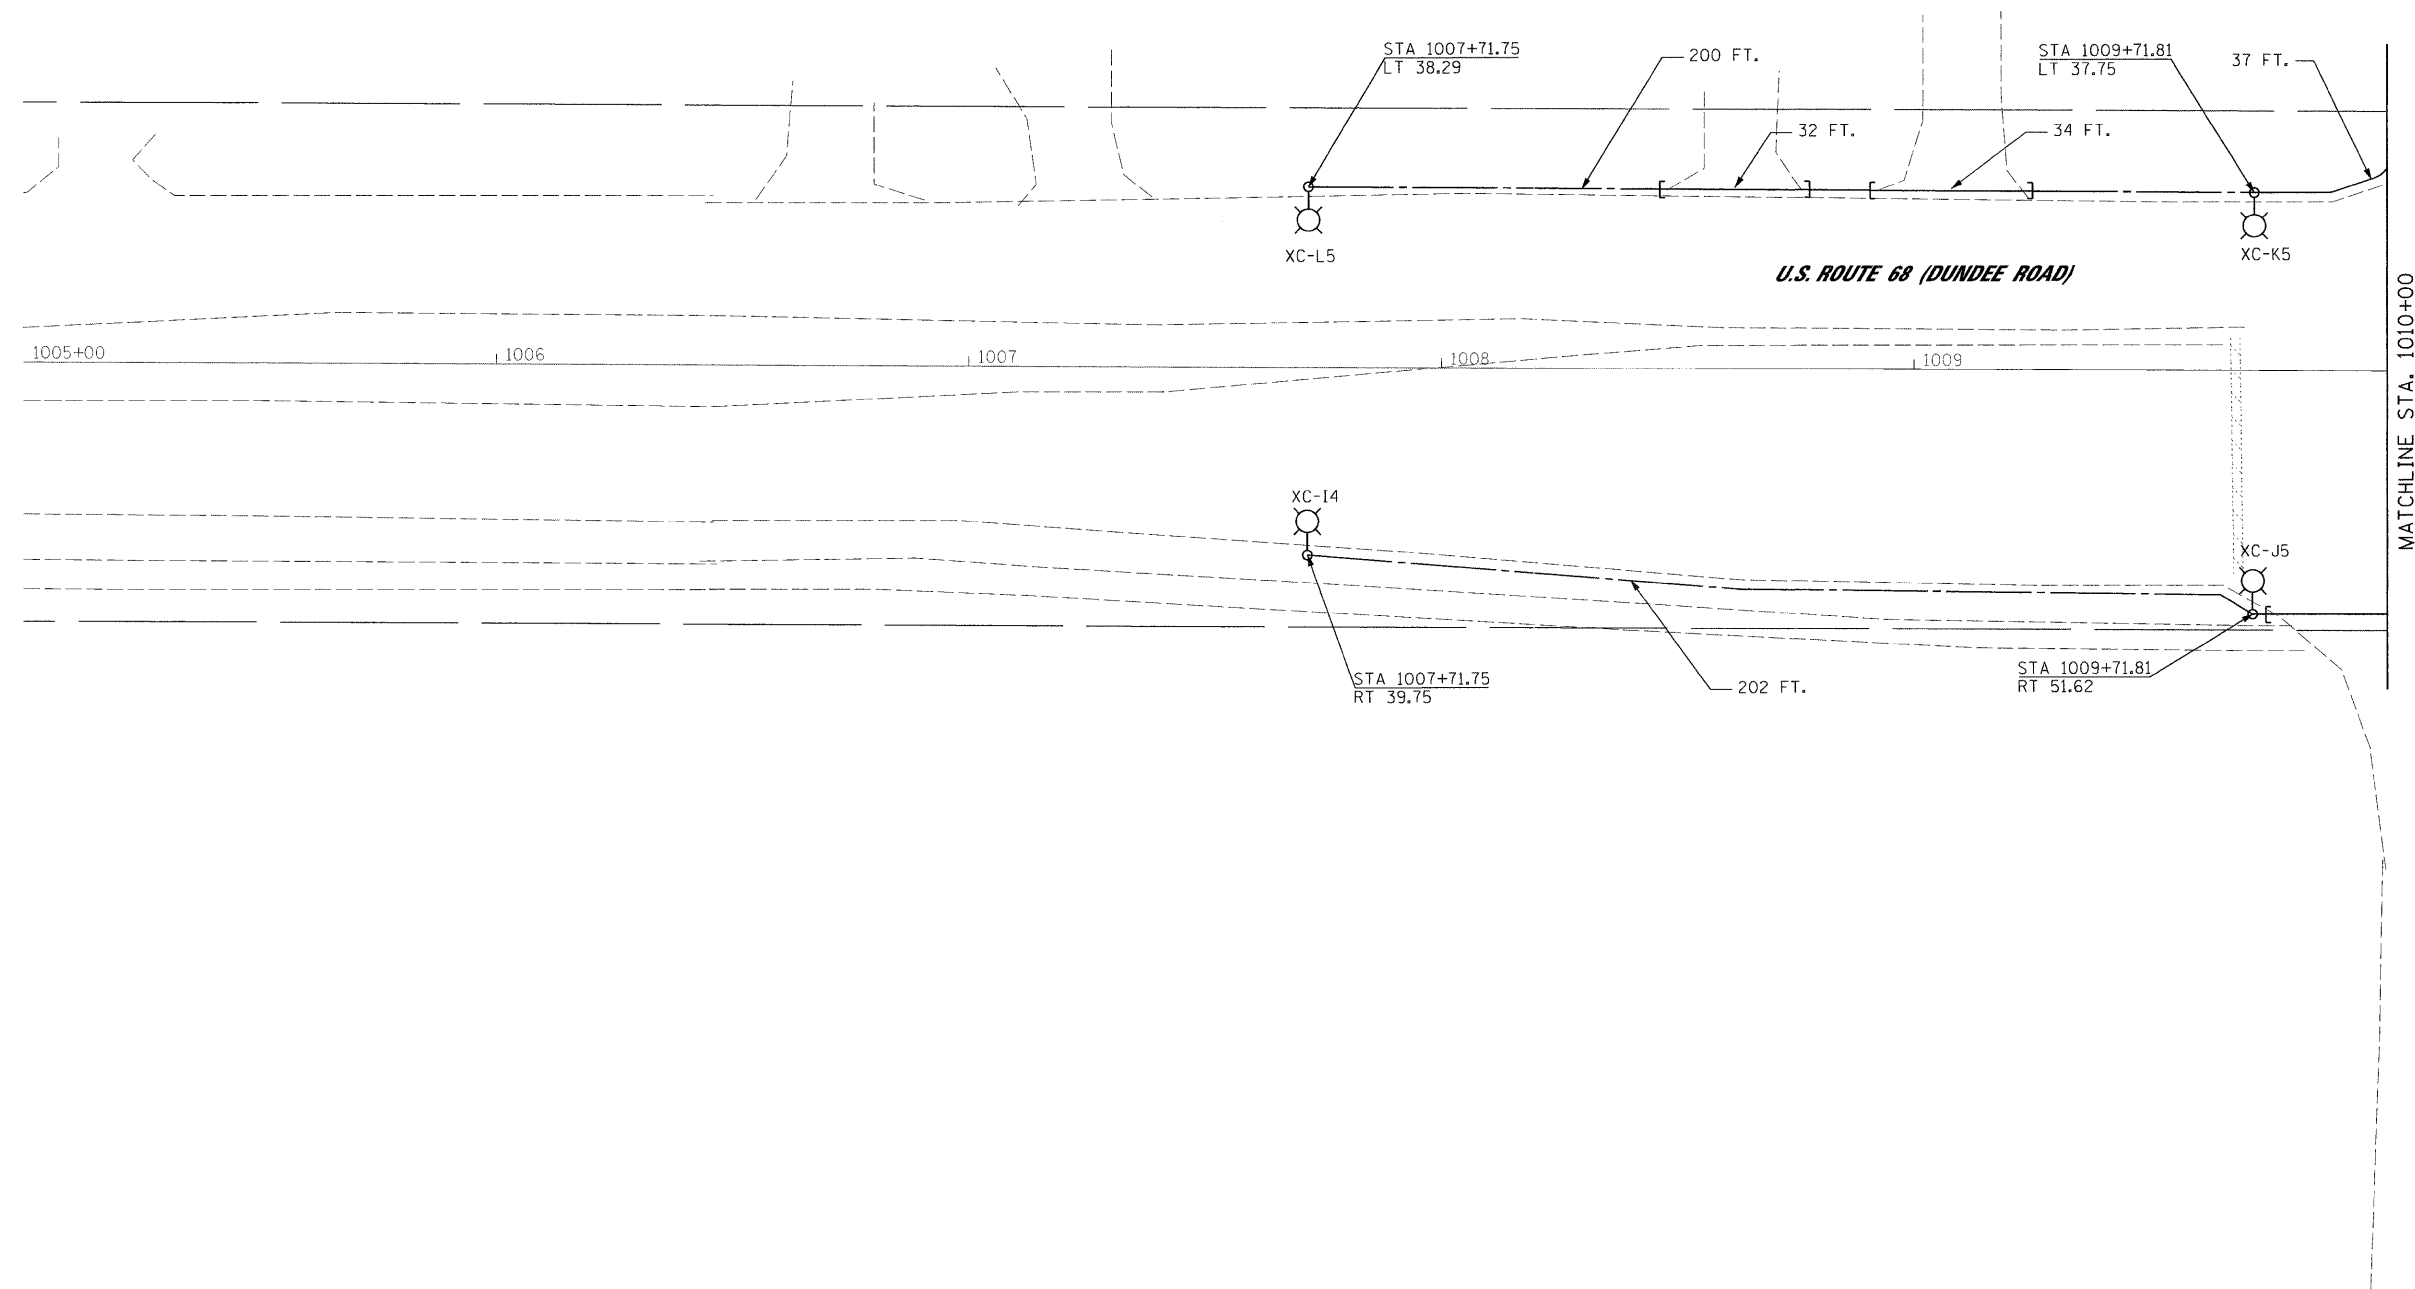


3/4/2009

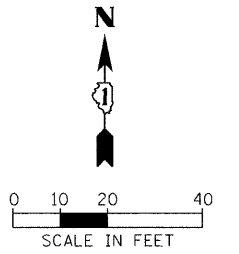

p:\2009\93700\cadd\sheet\Lighting Plan\_15\_Dundee 1.dgn

FILE NAME = Lighting Plan_15_Dundee 1.dgn	USER NAME = #USER#	DESIGNED - HS	REVISED -
	PLOT SCALE = #SCALE#	DRAWN - MJO	REVISED -
	PLOT DATE = 3/4/2009	CHECKED - CDS	REVISED -
		DATE - 1/22/2009	REVISED -

STATE OF ILLINOIS DEPARTMENT OF TRANSPORTATION	PROPOSED LIGHTING PLAN
---	------------------------

SCALE: 1"=20'	SHEET NO. OF SHEETS	STA. 1005+00 TO STA. 1010+00
---------------	---------------------	------------------------------

<b>JACOBS</b>		ONE NORTH FRANKLIN CHICAGO IL. 60606 312-251-3000	
F.A.P. RTE. 334	SECTION 2008-08-31	COUNTY COOK	TOTAL SHEETS NO. 81
CONTRACT NO. 60F87		TOTAL SHEETS NO. 59	
FED. ROAD DIST. NO. ILLINOIS FED. AID PROJECT			