
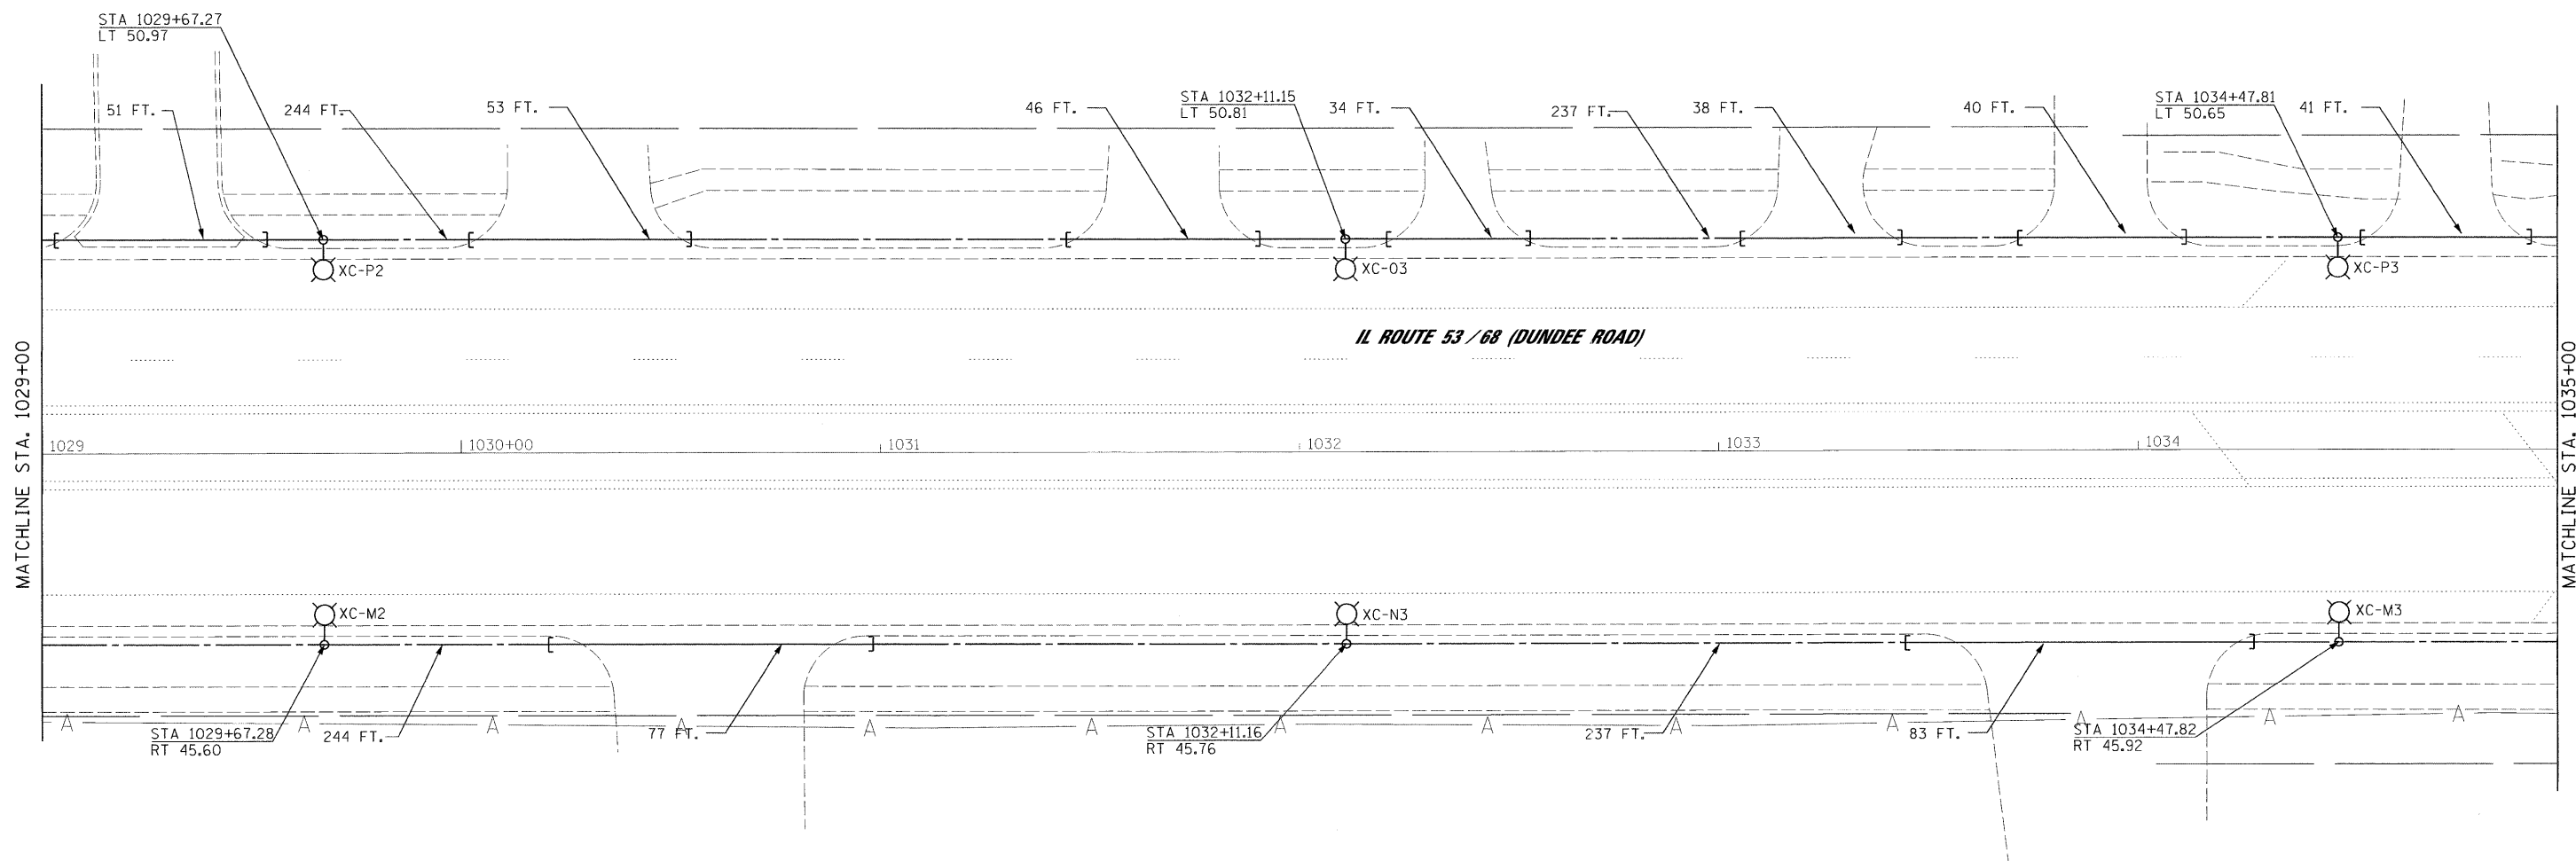


3/4/2009

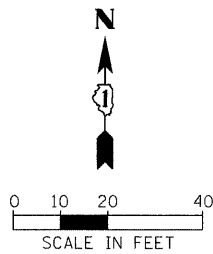

p:\2009\09\03706\cadd\sheets\Lighting Plan\19_Dundee 6.dgn

FILE NAME = Lighting Plan_19_Dundee 6.dgn

USER NAME = #USER#
PLOT SCALE = #SCALE#
PLOT DATE = 3/4/2009

DESIGNED - HS
DRAWN - MJO
CHECKED - CDS
DATE - 1/22/2009

REVISED -
REVISED -
REVISED -
REVISED -

**STATE OF ILLINOIS
DEPARTMENT OF TRANSPORTATION**

PROPOSED LIGHTING PLAN
SCALE: 1"=20' SHEET NO. OF SHEETS STA. 1030+00 TO STA. 1035+00

JACOBS		ONE NORTH FRANKLIN CHICAGO IL. 60606 312-251-3000	
F.A.P. RTE. 334	SECTION 2008-08-31	COUNTY COOK	TOTAL SHEETS 81
		SHEET NO. 63	
		CONTRACT NO. 60F87	
FED. ROAD DIST. NO.		ILLINOIS FED. AID PROJECT	