
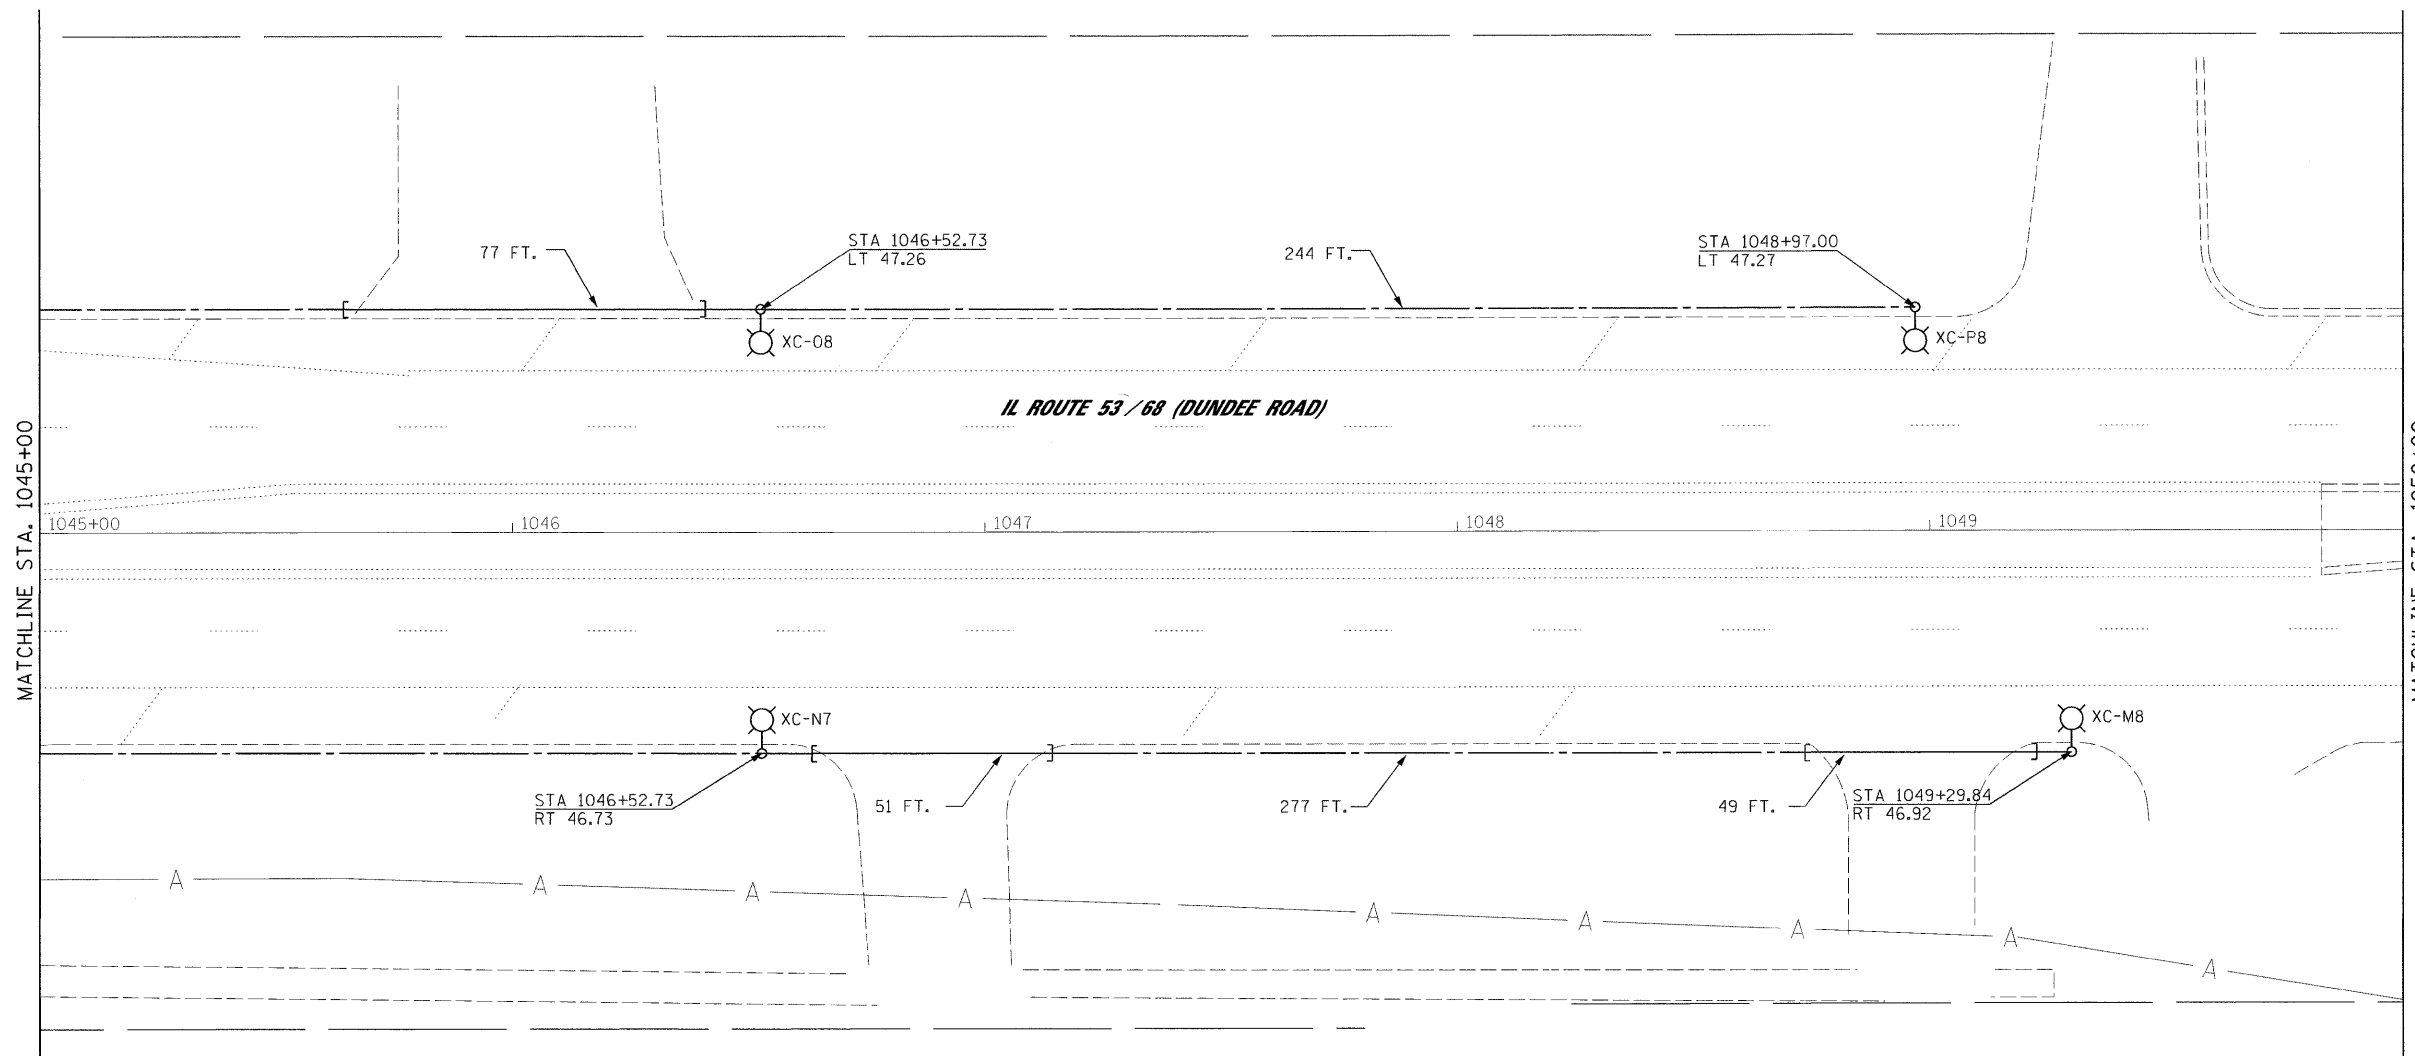


3/4/2009

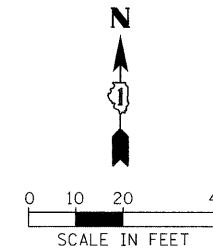

pt:\2008\c\k\3200\cadd\plans\Lighting Plan\_22\_Dundee 9.dgn

FILE NAME = Lighting Plan_22_Dundee 9.dgn
--

USER NAME = #USER#
PLOT SCALE = #SCALE#
PLOT DATE = 3/4/2009

DESIGNED - HS
DRAWN - MJO
CHECKED - CDS
DATE - 1/22/2009

REVISED -
REVISED -
REVISED -
REVISED -

**STATE OF ILLINOIS  
DEPARTMENT OF TRANSPORTATION**

<b>PROPOSED LIGHTING PLAN</b>			
SCALE: 1"=20'	SHEET NO.	OF	SHEETS
			STA. 1045+00 TO STA. 1050+00

<b>JACOBS</b>				ONE NORTH FRANKLIN CHICAGO IL, 60606 312-251-3000	
F.A.P. RTE. 334	SECTION 2008-08-31	COUNTY COOK	TOTAL SHEETS 81	SHEET NO. 66	CONTRACT NO. 60F87
FED. ROAD DIST. NO.		ILLINOIS FED. AID PROJECT			