


RECORD DRAWING  
 APPROVED  
 VIRGIL COOK & SON, INC.  
 BY *Larry A. Carlson*  
 DATE *7/25/96*


SECTION	COUNTY	TOTAL SHEETS
L-005-1	KANE	28
SHEET NO. 1203		OF 28 SHEETS

0-91-015-94

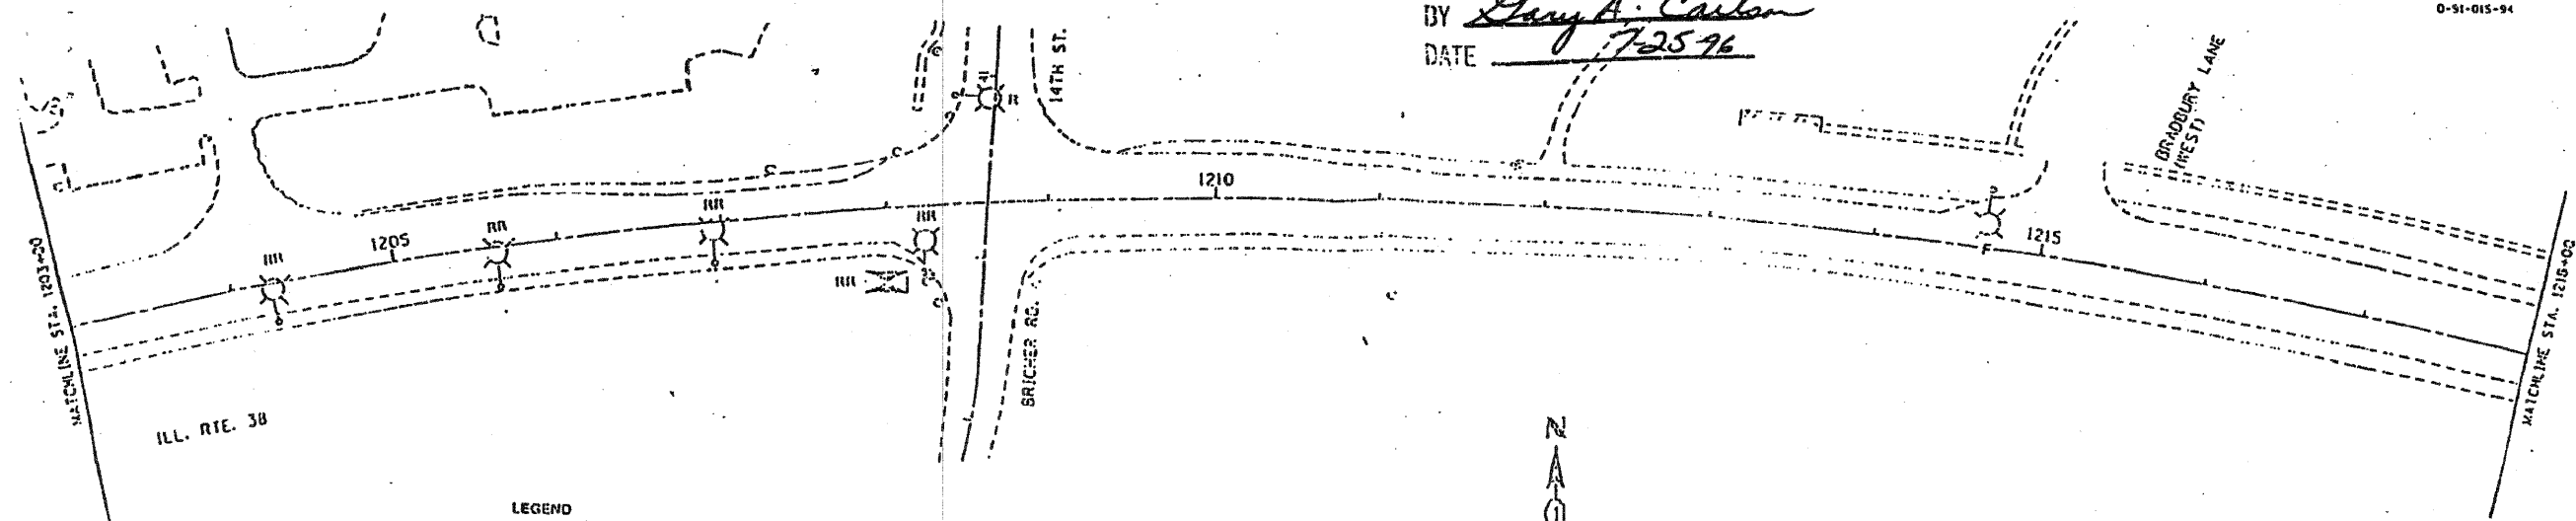

- LEGEND
- F PARTIAL FOUNDATION REMOVAL ONLY.
  - R EXISTING LIGHTING UNIT TO BE REMOVED.
  - RR EXISTING LIGHTING UNIT TO BE REMOVED AND RELOCATED.
  - RRR EXISTING LIGHTING CONTROLLER TO BE REMOVED BY OTHERS.

PREPARED BY:  
**CEMCON, Ltd.**  
 Consulting Engineers, Land Surveyors & Planners  
 2280 White Oak Circle, Suite 100  
 Aurora, Illinois 60504-9675  
 Ph: 630.862.2100 Fax: 630.862.2199  
 E-Mail: cadd@cemcon.com Website: www.cemcon.com

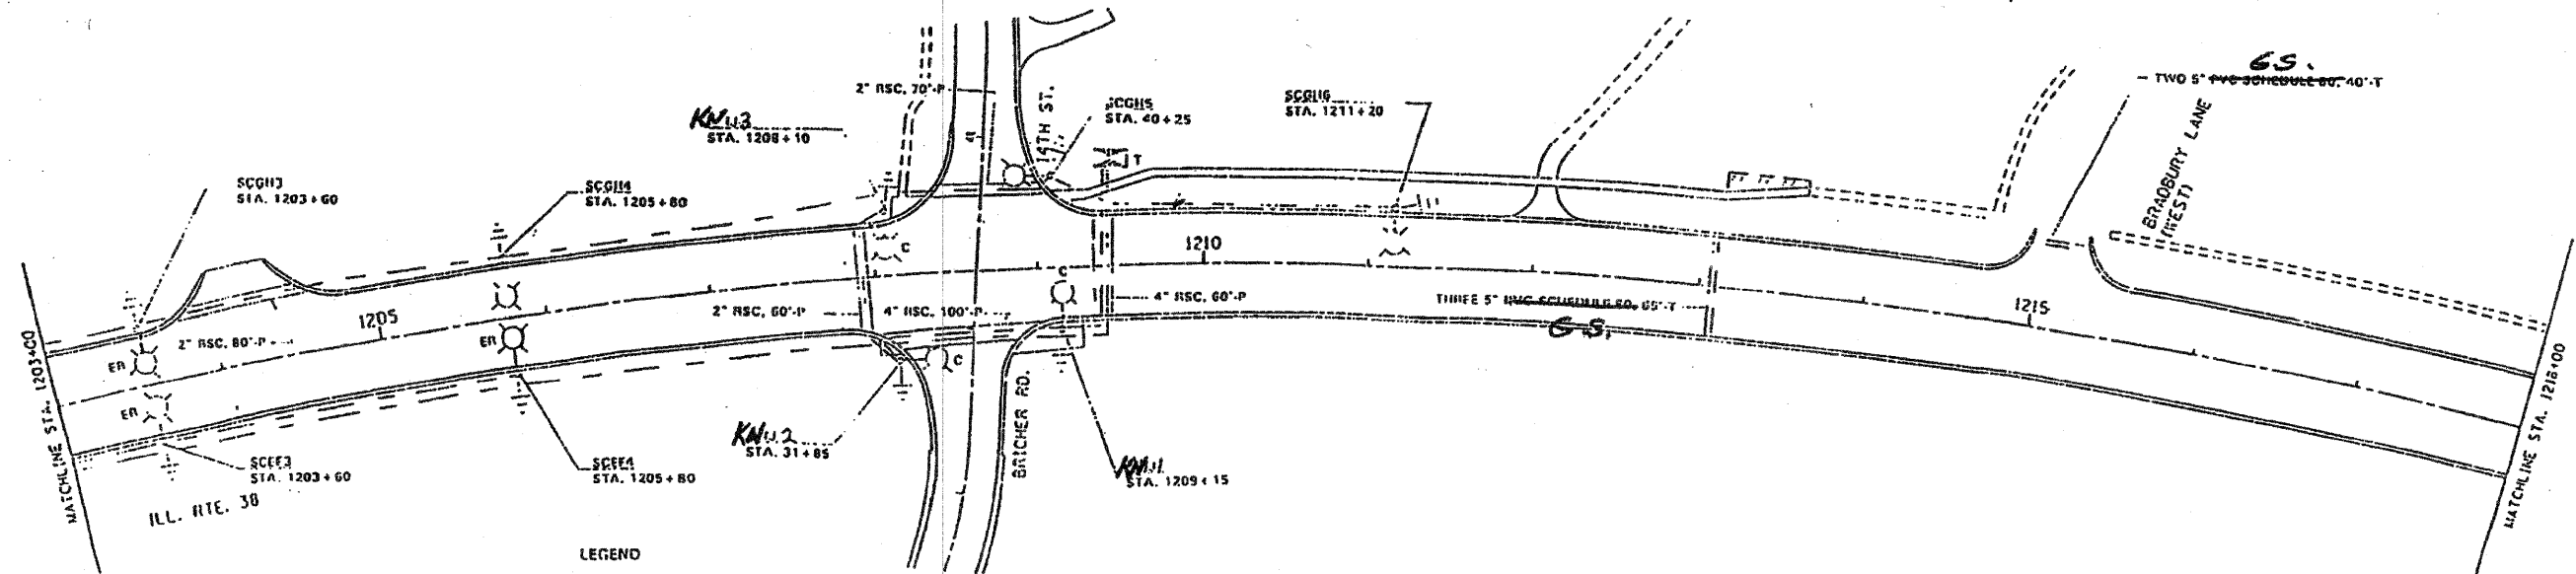

- LEGEND
- PROPOSED ALUMINUM LIGHT POLE, 40 FT M.H., 8 FT MAST ARM, 310W LUMINAIRE WITH 3 FT SET BACK UNLESS OTHERWISE NOTED.
  - ER EXISTING LIGHTING UNIT RELOCATED, 40 FT M.H., 8 FT MAST ARM, NEW 310W LUMINAIRE WITH 3 FT SET BACK UNLESS OTHERWISE NOTED.
  - LC LUMINAIRE MOUNTED ON COMBINATION TRAFFIC SIGNAL/LIGHT POLE, 40 FT M.H., 8 FT MAST ARM, 310W LUMINAIRE.
  - UNIT DUCT WITH 2-1/2" NO. 6 & 1-1/2" NO. 8 GROUND, 600 VOLT (EPR-TYPE RHW) 1 INCH DIA.
  - PROPOSED CONDUIT, GALVANIZED STEEL, TRENCH (T) OR PUSHED (P), UNIT DUCT WITHIN. SIZE AND LENGTH INDICATED ON PLANS.
  - PROPOSED CONDUIT, ~~6.5.~~ ENCASED IN CONCRETE (C). SIZE AND LENGTH INDICATED ON PLANS.
  - PROPOSED TRAFFIC CONTROLLER.
  - GROUND ROD.

REVISIONS	
DATE	BY

ILLINOIS DEPARTMENT OF TRANSPORTATION  
 PROPOSED STREET LIGHTING F.A.P. 347  
 (ILL. RTE. 38 @ 14TH ST.)  
 VERT. SCALE: 1"=50'  
 HORIZ. SCALE: 1"=50'  
 DATE: 10/5/94  
 DRAWN BY: M.S.  
 CHECKED BY: C.B.

**FOR INFORMATION ONLY**

FILE NAME = \MICROST\382069\ 27-REC LIGHTING.DGN	USER NAME = JGC	DESIGNED - KK	REVISED -	STATE OF ILLINOIS DEPARTMENT OF TRANSPORTATION	RECORD LIGHTING PLAN - IL. ROUTE 38 @ 14th STREET KANE COUNTY TRAFFIC SIGNAL MODERNIZATION	F.A.P. RTE.	SECTION	COUNTY	TOTAL SHEETS	SHEET NO.
PLOT SCALE = 1"=20'	CHECKED - BPT	REVISED -	REVISED -			2009-003 TS	KANE	28	27	
PLOT DATE = 01-23-09	DATE - 01-23-09	REVISED -	REVISED -			CONTRACT NO. 60F98				
SCALE: N.T.S.	SHEET NO. OF SHEETS	STA. TO STA.	FED. ROAD DIST. NO.			ILLINOIS FED. AID PROJECT				