

60607

F.A. RTE.	SECTION	COUNTY	TOTAL SHEETS	SHEET NO.
2009-009 TS		COOK	24	1

D-91-322-09

INDEX OF SHEETS

1. TITLE SHEET
2. SUMMARY OF QUANTITIES
3. DISTRICT ONE STANDARD TRAFFIC SIGNAL DESIGN DETAILS - SHEET 1 OF 4
4. DISTRICT ONE STANDARD TRAFFIC SIGNAL DESIGN DETAILS - SHEET 2 OF 4
5. DISTRICT ONE STANDARD TRAFFIC SIGNAL DESIGN DETAILS - SHEET 3 OF 4
6. DISTRICT ONE STANDARD TRAFFIC SIGNAL DESIGN DETAILS - SHEET 4 OF 4
7. ILL RTE 83 AT DIXIE HIGHWAY - EXISTING AND REMOVAL PLAN
8. ILL RTE 83 AT DIXIE HIGHWAY - EXISTING CABLE PLAN
9. ILL RTE 83 AT DIXIE HIGHWAY - PROPOSED TRAFFIC SIGNAL PLAN
10. ILL RTE 83 AT DIXIE HIGHWAY - PROPOSED CABLE PLAN
11. ILL RTE 83 AT DIXIE HIGHWAY - INTERCONNECT PLAN
12. BRAINARD AVENUE AT BURNHAM AVENUE - EXISTING AND REMOVAL PLAN
13. BRAINARD AVENUE AT BURNHAM AVENUE - EXISTING CABLE PLAN
14. BRAINARD AVENUE AT BURNHAM AVENUE - PROPOSED TRAFFIC SIGNAL PLAN
15. BRAINARD AVENUE AT BURNHAM AVENUE - PROPOSED CABLE PLAN
16. BRAINARD AVENUE AT BURNHAM AVENUE - SEQUENCE OF OPERATION AND RAILROAD PREEMPTION SEQUENCE OF OPERATION
17. JOE ORR ROAD AT CHICAGO ROAD - EXISTING AND REMOVAL PLAN
18. JOE ORR ROAD AT CHICAGO ROAD - EXISTING CABLE PLAN
19. JOE ORR ROAD AT CHICAGO ROAD - SEQUENCE OF OPERATION AND EMERGENCY VEHICLE SEQUENCE OF OPERATION
20. JOE ORR ROAD AT CHICAGO ROAD - PROPOSED TRAFFIC SIGNAL PLAN
21. JOE ORR ROAD AT CHICAGO ROAD - PROPOSED CABLE PLAN
22. JOE ORR ROAD AT CHICAGO ROAD - SEQUENCE OF OPERATION AND EMERGENCY VEHICLE SEQUENCE OF OPERATION
23. JOE ORR ROAD AT CHICAGO ROAD - INTERCONNECT PLAN (SHEET 1 OF 2)
24. JOE ORR ROAD AT CHICAGO ROAD - INTERCONNECT PLAN (SHEET 2 OF 2)

STATE OF ILLINOIS
DEPARTMENT OF TRANSPORTATION
DIVISION OF HIGHWAYS

PLANS FOR PROPOSED FEDERAL AID HIGHWAY

DISTRICT 1
HIGHWAY SAFETY IMPROVEMENT PROJECT
TRAFFIC SIGNAL MODERNIZATION

↙ 147TH
ILL RTE 83 / (SIBLEY BLVD.) AT DIXIE HIGHWAY
BRAINARD AVENUE AT BURNHAM AVENUE
JOE ORR ROAD AT CHICAGO ROAD
PROJECT: HSIP-0005 (663)
SECTION 2009-009 TS
COOK COUNTY
C-91-322-09




STANDARD DRAWINGS

424001-05	606001-03	805001-01	814001-02	814006-02
857001-01	857006	862001-01	873001-01	876001
877001-03	878001-06	880001	880006-01	886001
701501-05	701601-06	701606-05	701701-06	701801-04
720001	720016-01	780001-01		

NOTE: STANDARD DRAWINGS REQUIRED (CIRCLED)


THORNTON AND BLOOM TOWNSHIP

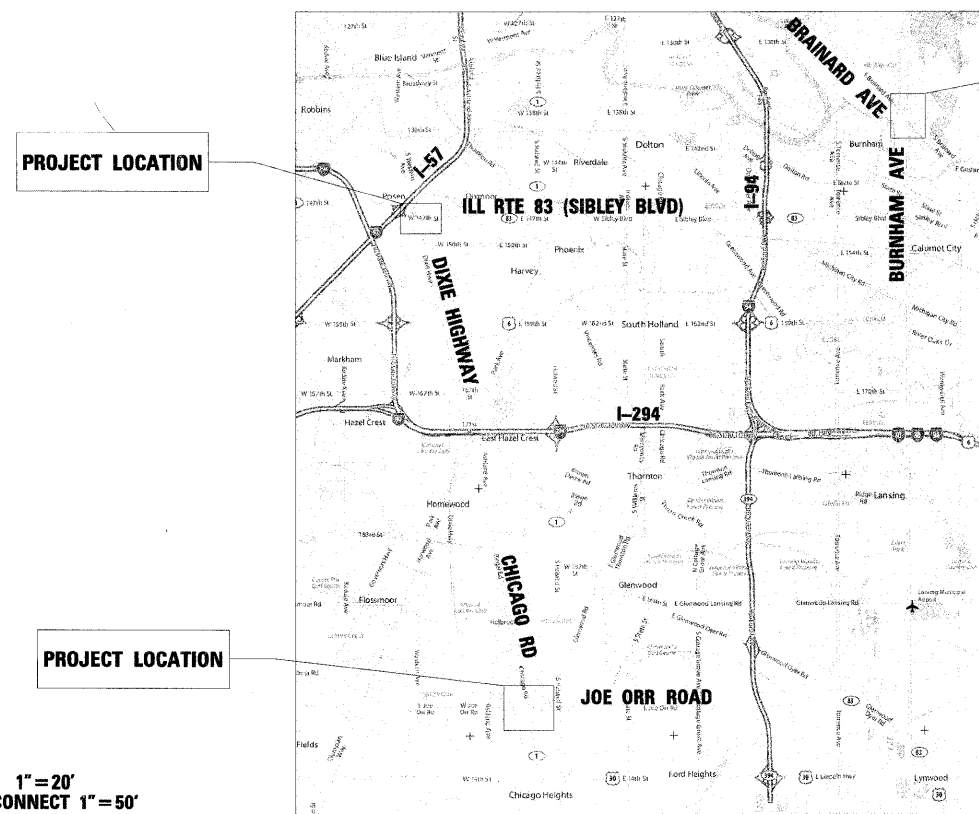

PROJECT LOCATION

PROJECT LOCATION

PROJECT LOCATION

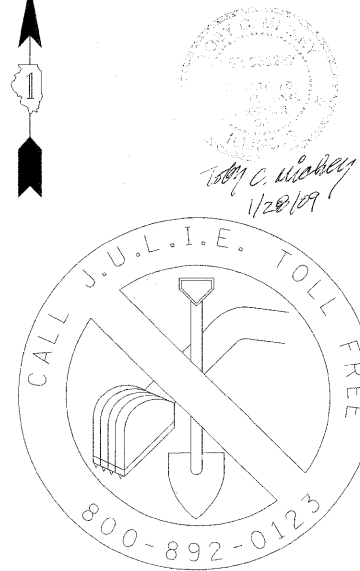

48 - HOURS BEFORE DIGGING

STATE OF ILLINOIS
DEPARTMENT OF TRANSPORTATION
DIVISION OF HIGHWAYS

SUBMITTED Jan 30 20 09

Denise M. O'Neil
DEPUTY DIRECTOR OF HIGHWAYS, REGION ENGINEER

March 27, 20 09
Charles A. Ingersoll
ENGINEER OF DESIGN AND ENVIRONMENT

March 27, 20 09
Christine M. Reed
DIRECTOR OF HIGHWAYS, CHIEF ENGINEER

PREPARED BY Steve Travia
TRAFFIC ENGINEER

Jan 30, 2009
DATE

SCALES { PLAN 1"=20'
INTERCONNECT 1"=50'

LOCATION MAP

**PRINTED BY THE AUTHORITY
OF THE STATE OF ILLINOIS**

CONTRACT NO. 60607

DISTRICT 1 BUREAU OF TRAFFIC: STEPHEN TRAVIA/DARYLE DREW (847) 705-4420