


F.A.P. RTE.	SECTION	COUNTY	TOTAL SHEETS	SHEET NO.
90/94	105'S TIP 29 A	COOK	246	121
STA.	TO STA.			
FED. ROAD DIST. NO.	ILLINOIS FED. AID PROJECT			

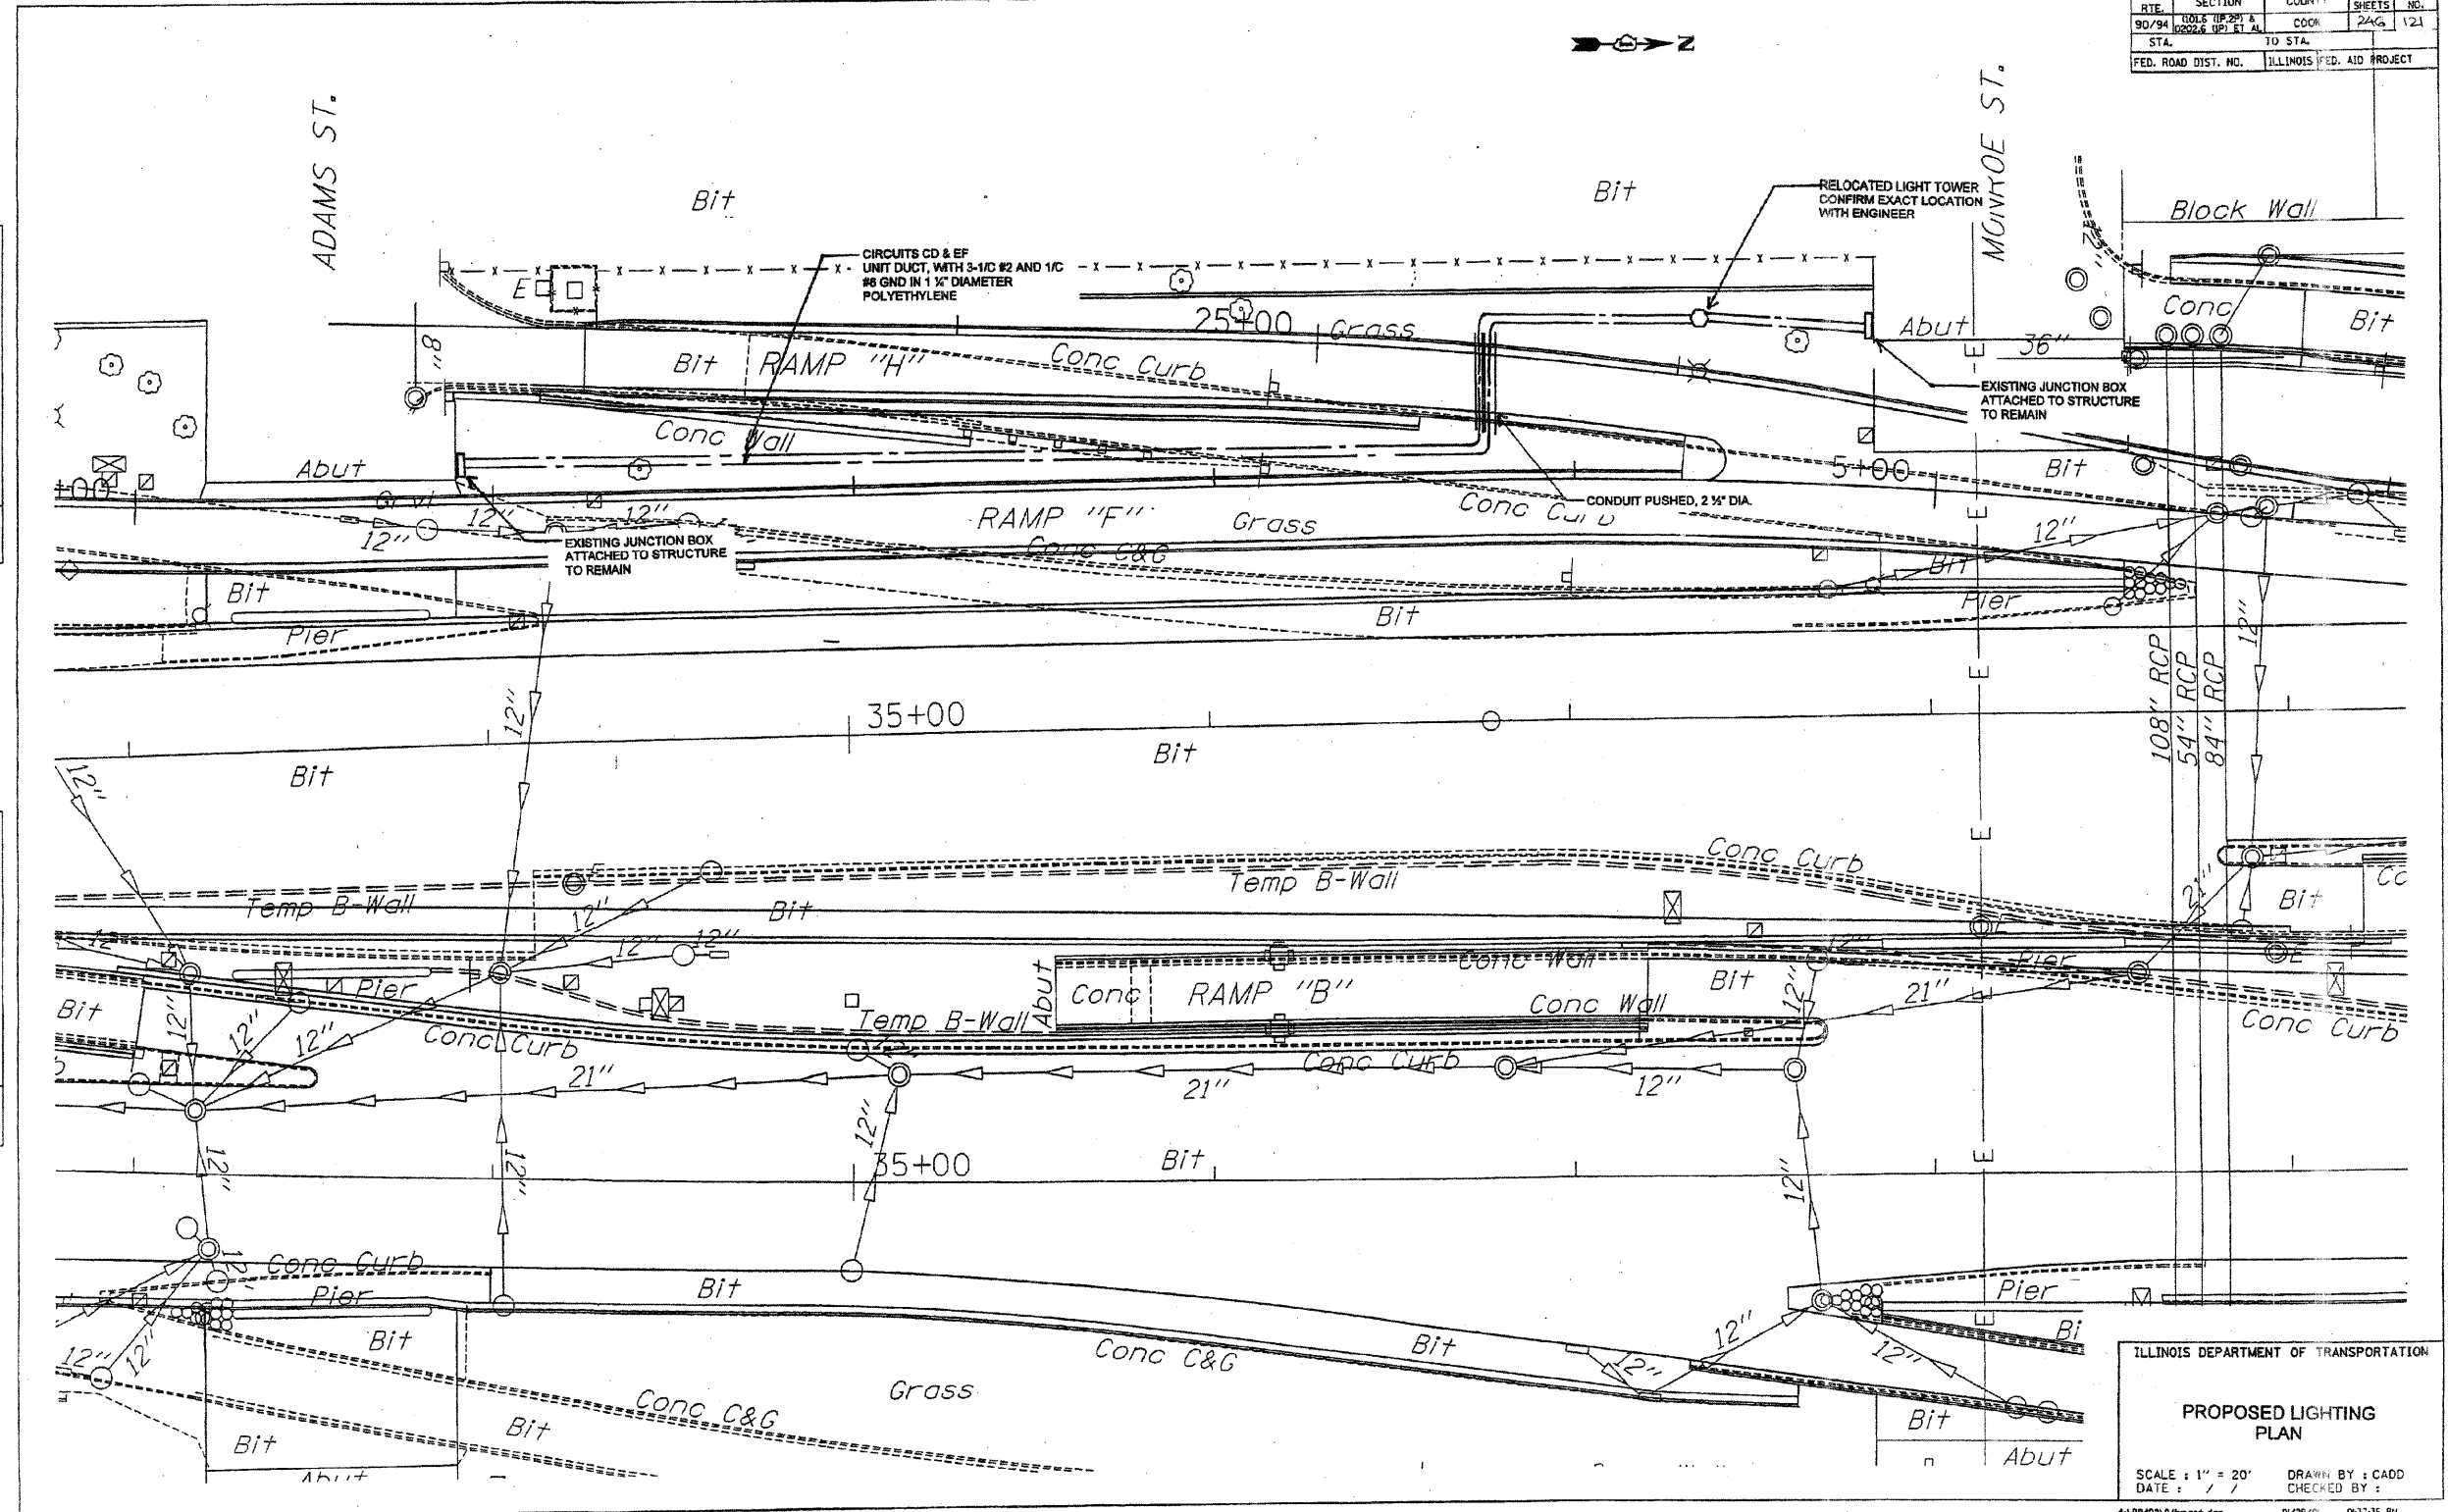

PLAN

DATE	
BY	
CHECKED	
DATE	
BY	
CHECKED	
DATE	
BY	
CHECKED	
DATE	
BY	
CHECKED	
DATE	

PROFILE

DATE	
BY	
CHECKED	
DATE	
BY	
CHECKED	
DATE	
BY	
CHECKED	
DATE	

ILLINOIS DEPARTMENT OF TRANSPORTATION

PROPOSED LIGHTING PLAN

SCALE : 1" = 20'
DATE : / /
DRAWN BY : CAOD
CHECKED BY :

11/18/94 2:54pm east.dgn 01/25/95 06:37:36 PM