


SECTION	COUNTY	TOTAL SHEETS	SHEET NO.
00/04	COOK	246	123
STA.	TO STA.		
FED. ROAD DIST. NO. 1 ILLINOIS		FED. AID PROJECT	
* (101.6(1P.2P) & 0202.6(1P, et al)			

CIRCUITS	PHASE 1 LOAD (AMPS)		PHASE 2 LOAD (AMPS)	
	BLACK	RED	BLACK	RED
A				
B	0.2			
C		17.5		
D	14.0			
E		41.9		
F	38.4			
G		27.2		
H	23.7			
I		22.5		
J	9.0			
TOTAL	108.3	125.8		

CIRCUITS	PHASE 1 LOAD (AMPS)		PHASE 2 LOAD (AMPS)	
	BLACK	RED	BLACK	RED
A				
B	0.0			
C		26.4		
D	26.4			
E		26.4		
F	26.4			
G		25.2		
H	21.7			
I		23.3		
J	20.2			
TOTAL	106.7	116.8		

FOR REFERENCE ONLY

DATE	DATE	DATE	DATE
DATE	DATE	DATE	DATE
DATE	DATE	DATE	DATE
DATE	DATE	DATE	DATE
DATE	DATE	DATE	DATE

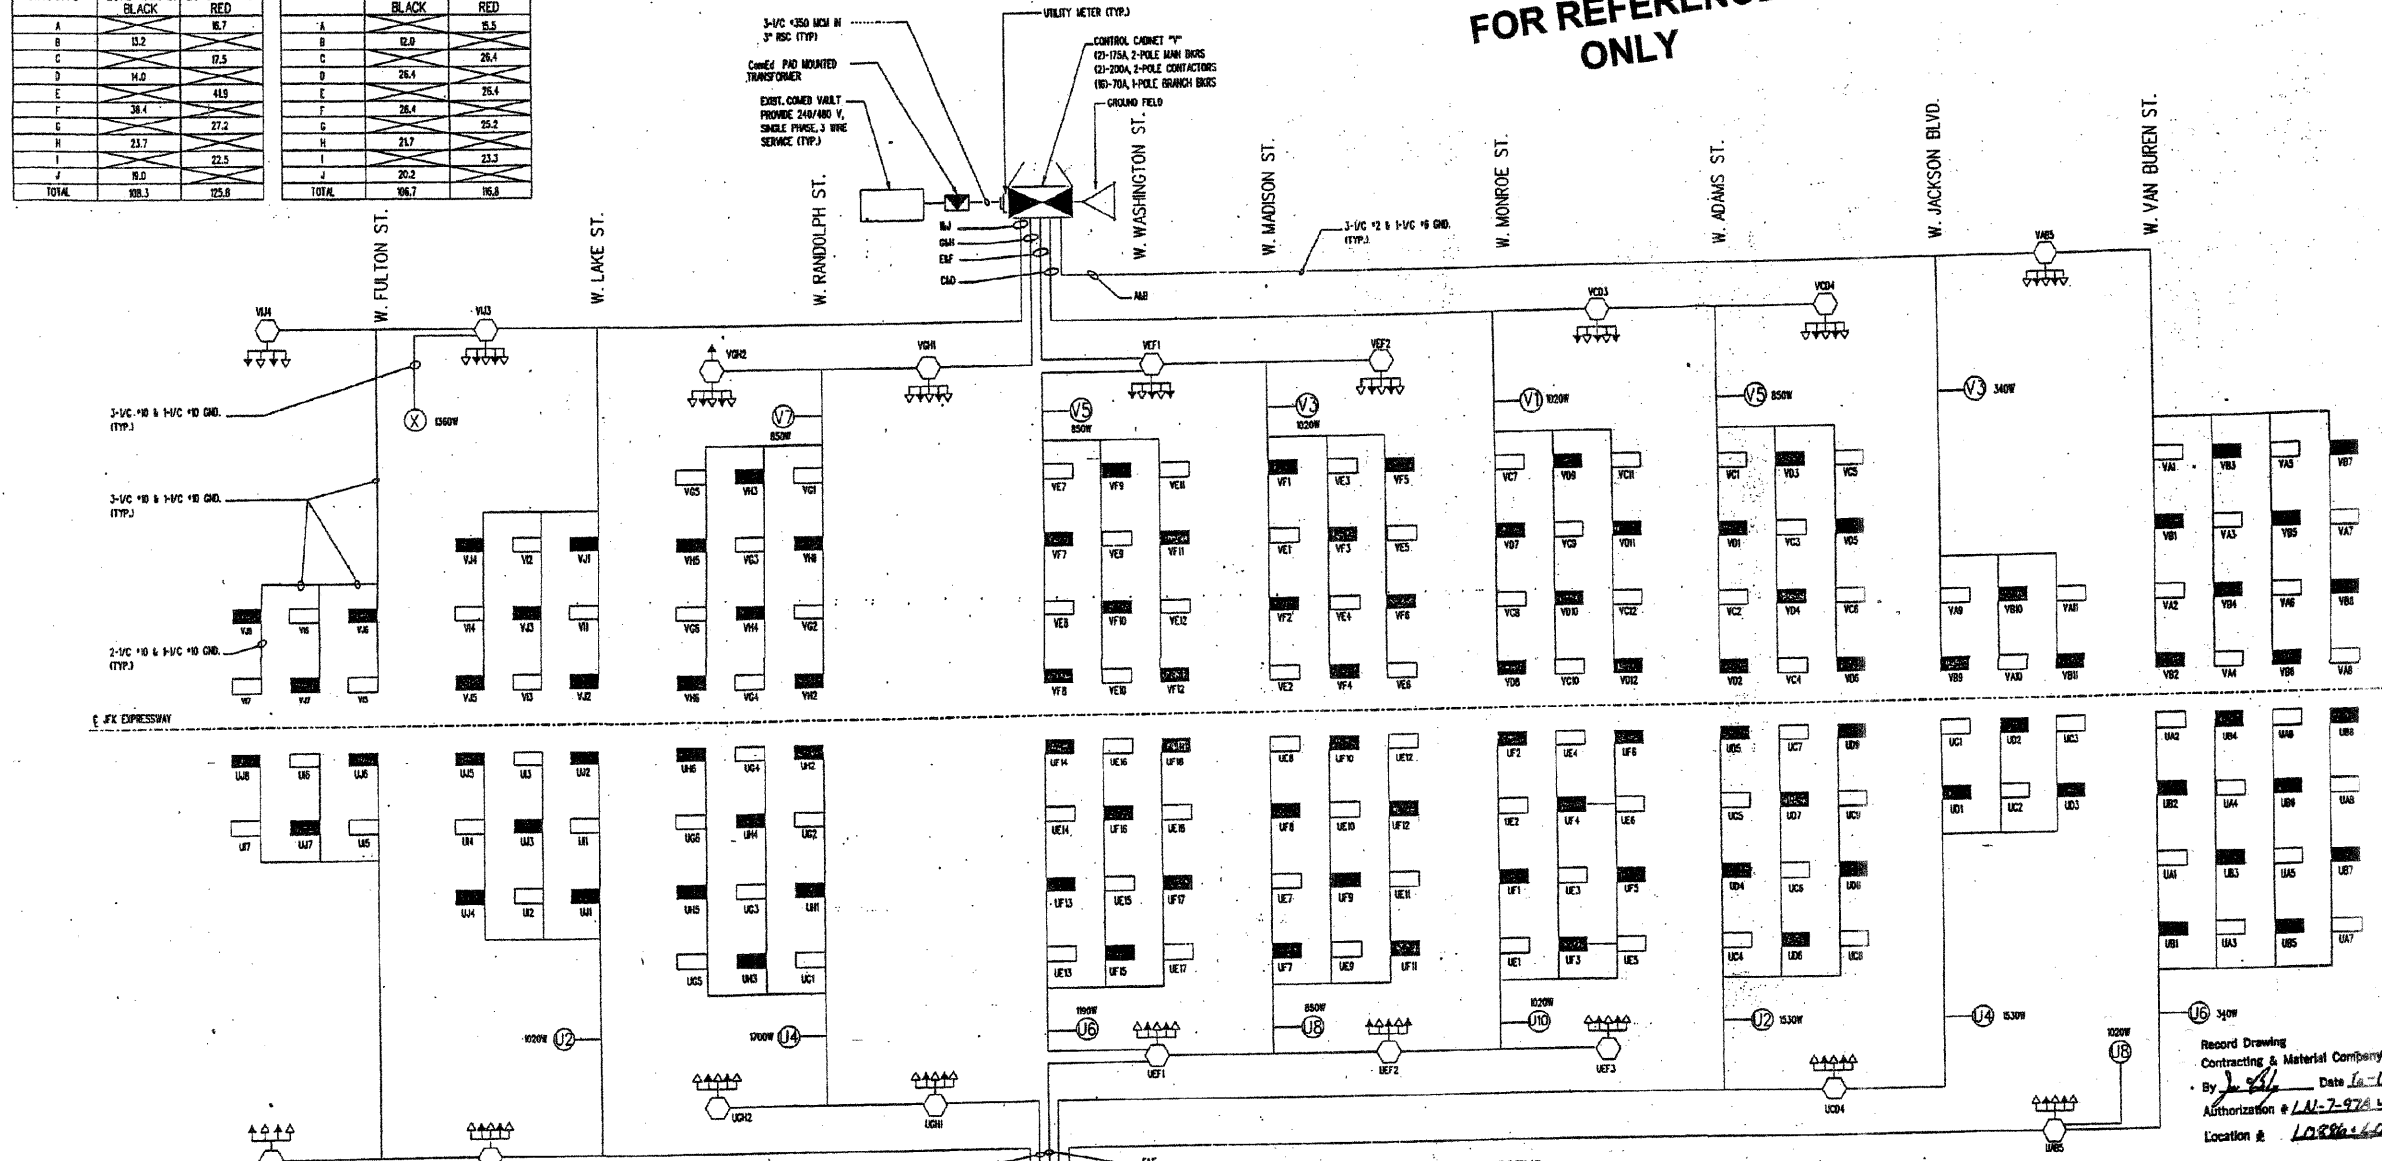

J.F. EXPRESSWAY


NOTES

THE EXISTING LIGHTING SYSTEMS DEPICTED ON THE PLANS ARE INTENDED ONLY TO INDICATE THE GENERAL EQUIPMENT INSTALLATION OF THE SYSTEMS INVOLVED AND SHALL NOT BE CONSTRUED AS AN EXACT REPRESENTATION OF THE FIELD CONDITIONS.

IT REMAINS THE CONTRACTOR'S RESPONSIBILITY TO VISIT THE SITE TO CONFIRM AND ASCERTAIN THE EXACT EXTENT OF THE ELECTRICAL EQUIPMENT AND SYSTEMS TO BE MAINTAINED.

PRIOR TO THE START OF ACTIVITIES AT THE SITE, ELECTRICAL OR OTHER, THE CONTRACTOR MUST SCHEDULE A FORMAL TRANSFER OF MAINTENANCE VIA THE ENGINEER AS SPECIFIED.

- LEGEND**
- ⬆️ HIGH MAST NUMBER OF 750W LPS LAMPHIRES INDICATED BY TRIANGLE
 - ▲ HIGH MAST LAMPHIRE 750W LPS ON BLACK WIRE
 - △ HIGH MAST LAMPHIRE 750W LPS ON RED WIRE
 - Ⓜ️ EXISTING BRIDGE MOUNTED OR TRUSS SIGN DESIGNATION AS INDICATED
 - 50W LPS CONNECTED TO RED WIRE
 - 50W LPS CONNECTED TO BLACK WIRE

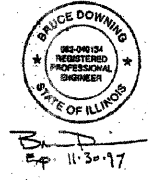

Burns & McDonnell

Record Drawing
Contracting & Material Company.
By *J. J. [Signature]* Date *6-18-96*
Authorization # *1A-7-976-4146-97A*
Location # *108664088E*

SHEET 2 OF 17

NO.	DATE	REVISIONS	BY	APP'D.

ILLINOIS DEPARTMENT OF TRANSPORTATION
**J. F. KENNEDY EXPRESSWAY
LIGHTING PLAN
SINGLE LINE DIAGRAM**

SHEET NO. 2 OF 14 SCALE	APP'D.
DESIGNED: M.W. 7 DETAILER	QUANTITIES
DESIGN: C.K. M.T. J. DETAIL: C.K.	DATE: 6/18/96