


- DRAINAGE LEGEND:**
- △ XX DRAINAGE STRUCTURE NUMBER
 - XX STORM SEWER NUMBER
 - 4" PIPE UNDERDRAIN

PLAN	SURVEYED	DATE
	PLOTTED	
	CHECKED	
	BY	
	NO. OF WAY CHECKED	
	ADD FILE NAME	

PROFILE	SURVEYED	DATE
	PLOTTED	
	CHECKED	
	BY	
	NO. OF WAY CHECKED	
	STRUCTURE NOTATIONS CHECKED	

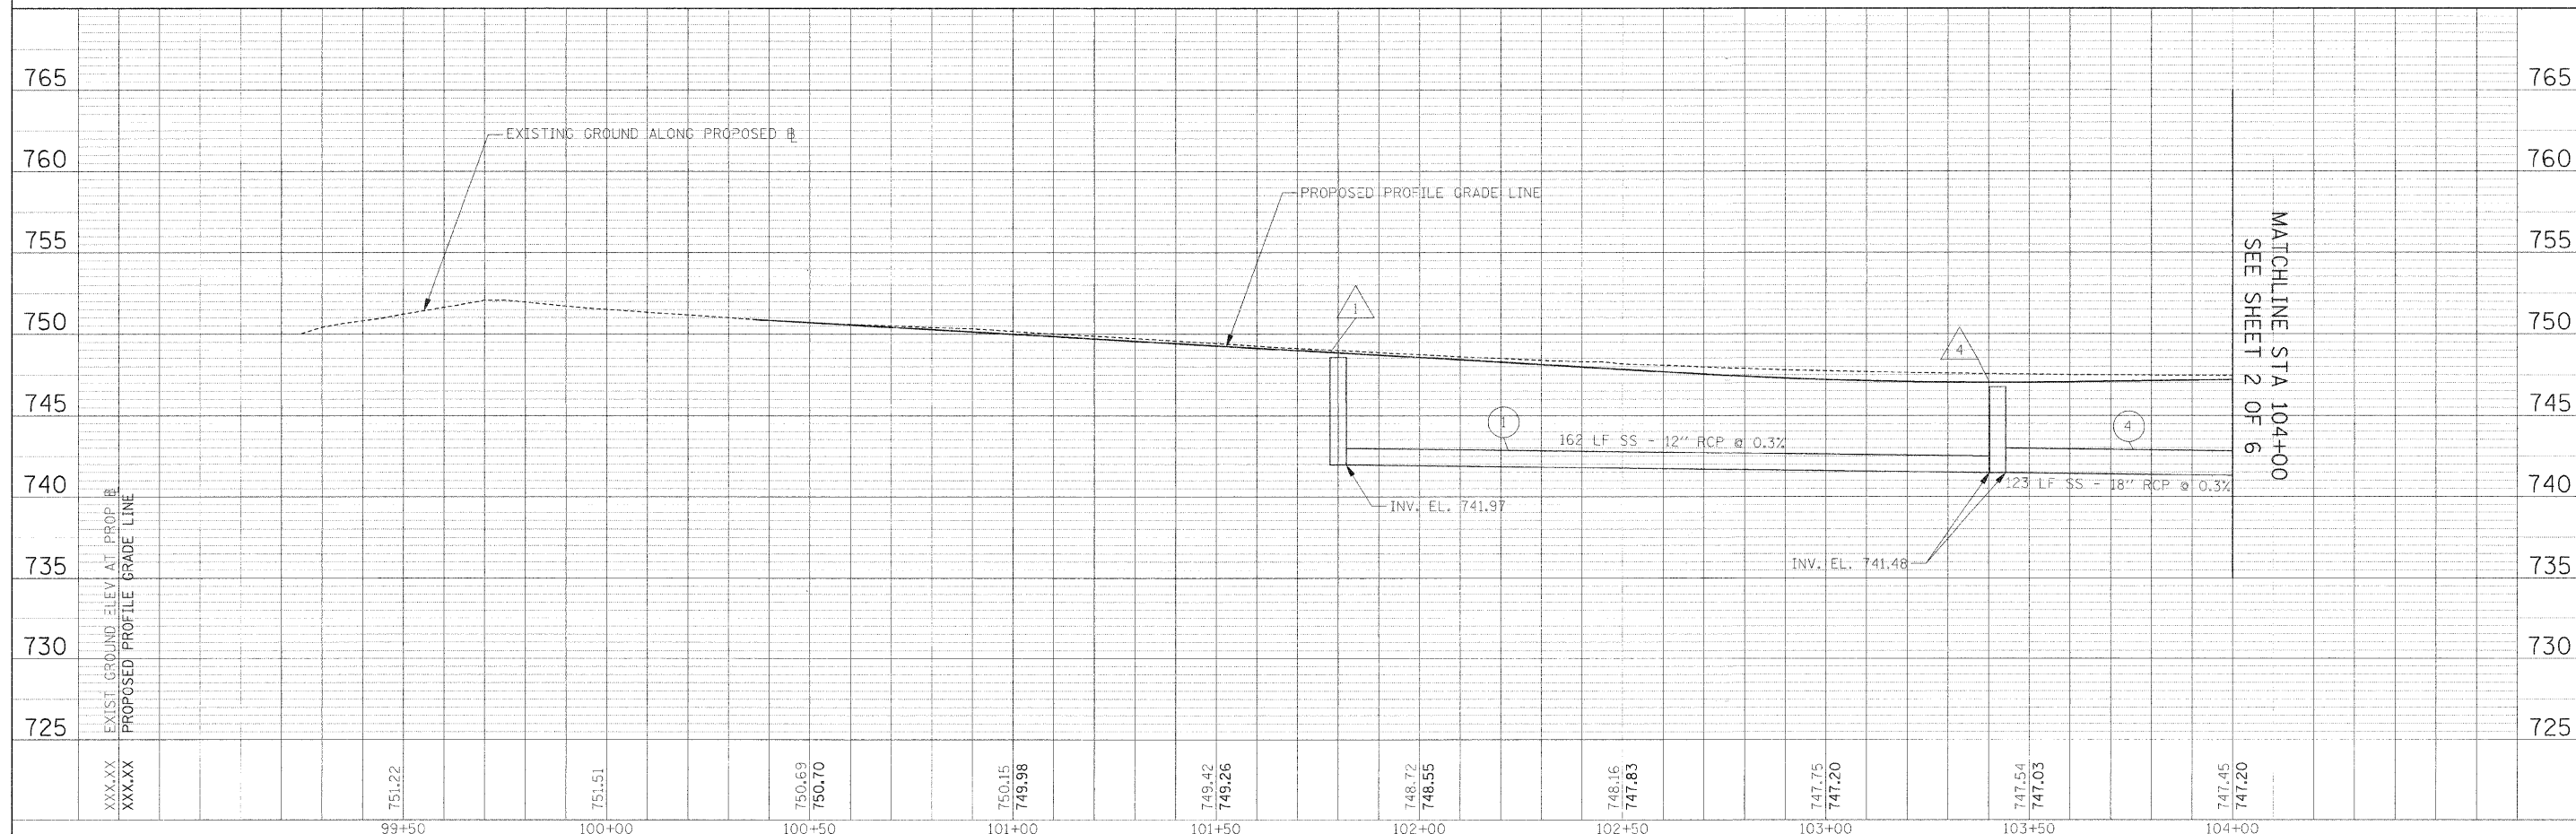

FILE NAME =	USER NAME = #USER*	DESIGNED - AJB	REVISED -	STATE OF ILLINOIS DEPARTMENT OF TRANSPORTATION	DRAINAGE PLAN AND PROFILE	F.A.U. RTE.	SECTION	COUNTY	TOTAL SHEETS	SHEET NO.	
#FILE#	PLOT SCALE = #SCALE*	DRAWN - TMC	REVISED -			3003	00-00084-00-PV	DUPAGE	112	39	
	PLOT DATE = #DATE*	CHECKED - DEB	REVISED -			BLACKHAWK DR RECONSTRUCTION		CONTRACT NO. 63121			
		DATE - 01/02/09	REVISED -			SCALE: 1:20		SHEET NO. 1 OF 6 SHEETS		STA. 99+00.00 TO STA. 104+00.00	

MATCHLINE STA 104+00
SEE SHEET 2 OF 6

MATCHLINE STA 104+00
SEE SHEET 2 OF 6