


MATCHLINE STA 109+00  
SEE SHEET 2 OF 6


MATCHLINE STA 114+00  
SEE SHEET 4 OF 6

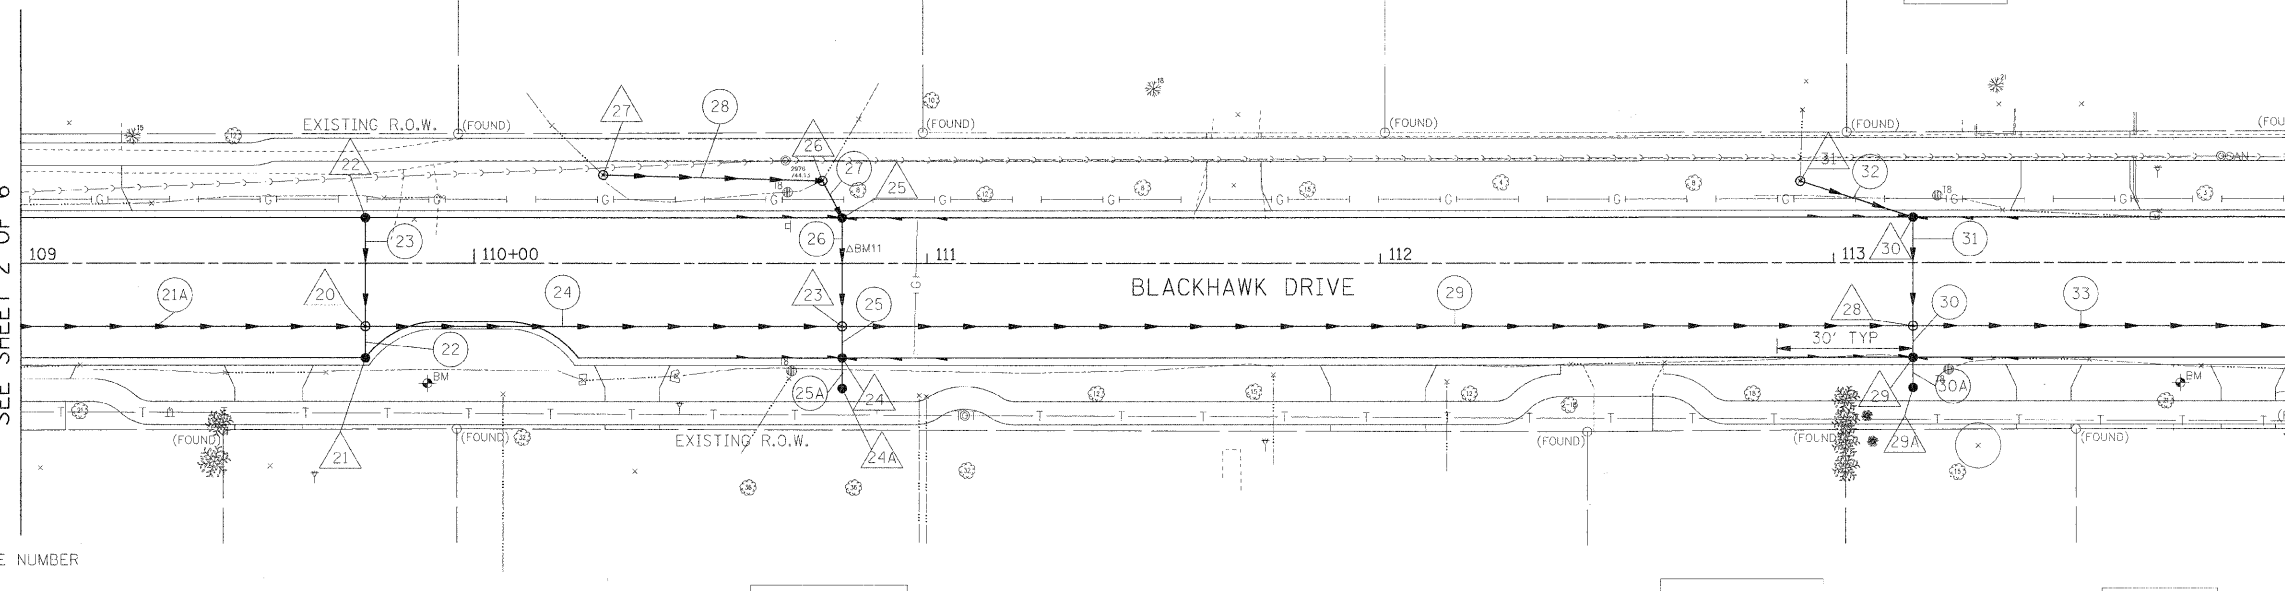

- DRAINAGE LEGEND:**
- DRAINAGE STRUCTURE NUMBER
  - STORM SEWER NUMBER
  - 4" PIPE UNDERDRAIN

PLAN	SURVEYED	DATE
	PLOTTED	
	NOTED	
	BY	
	NO. OF WAY DESIGNED	
	CADD FILE NAME	

PROFILE	SURVEYED	DATE
	PLOTTED	
	NOTED	
	BY	
	NO. OF WAY DESIGNED	
	STRUCTURE NOTATION	

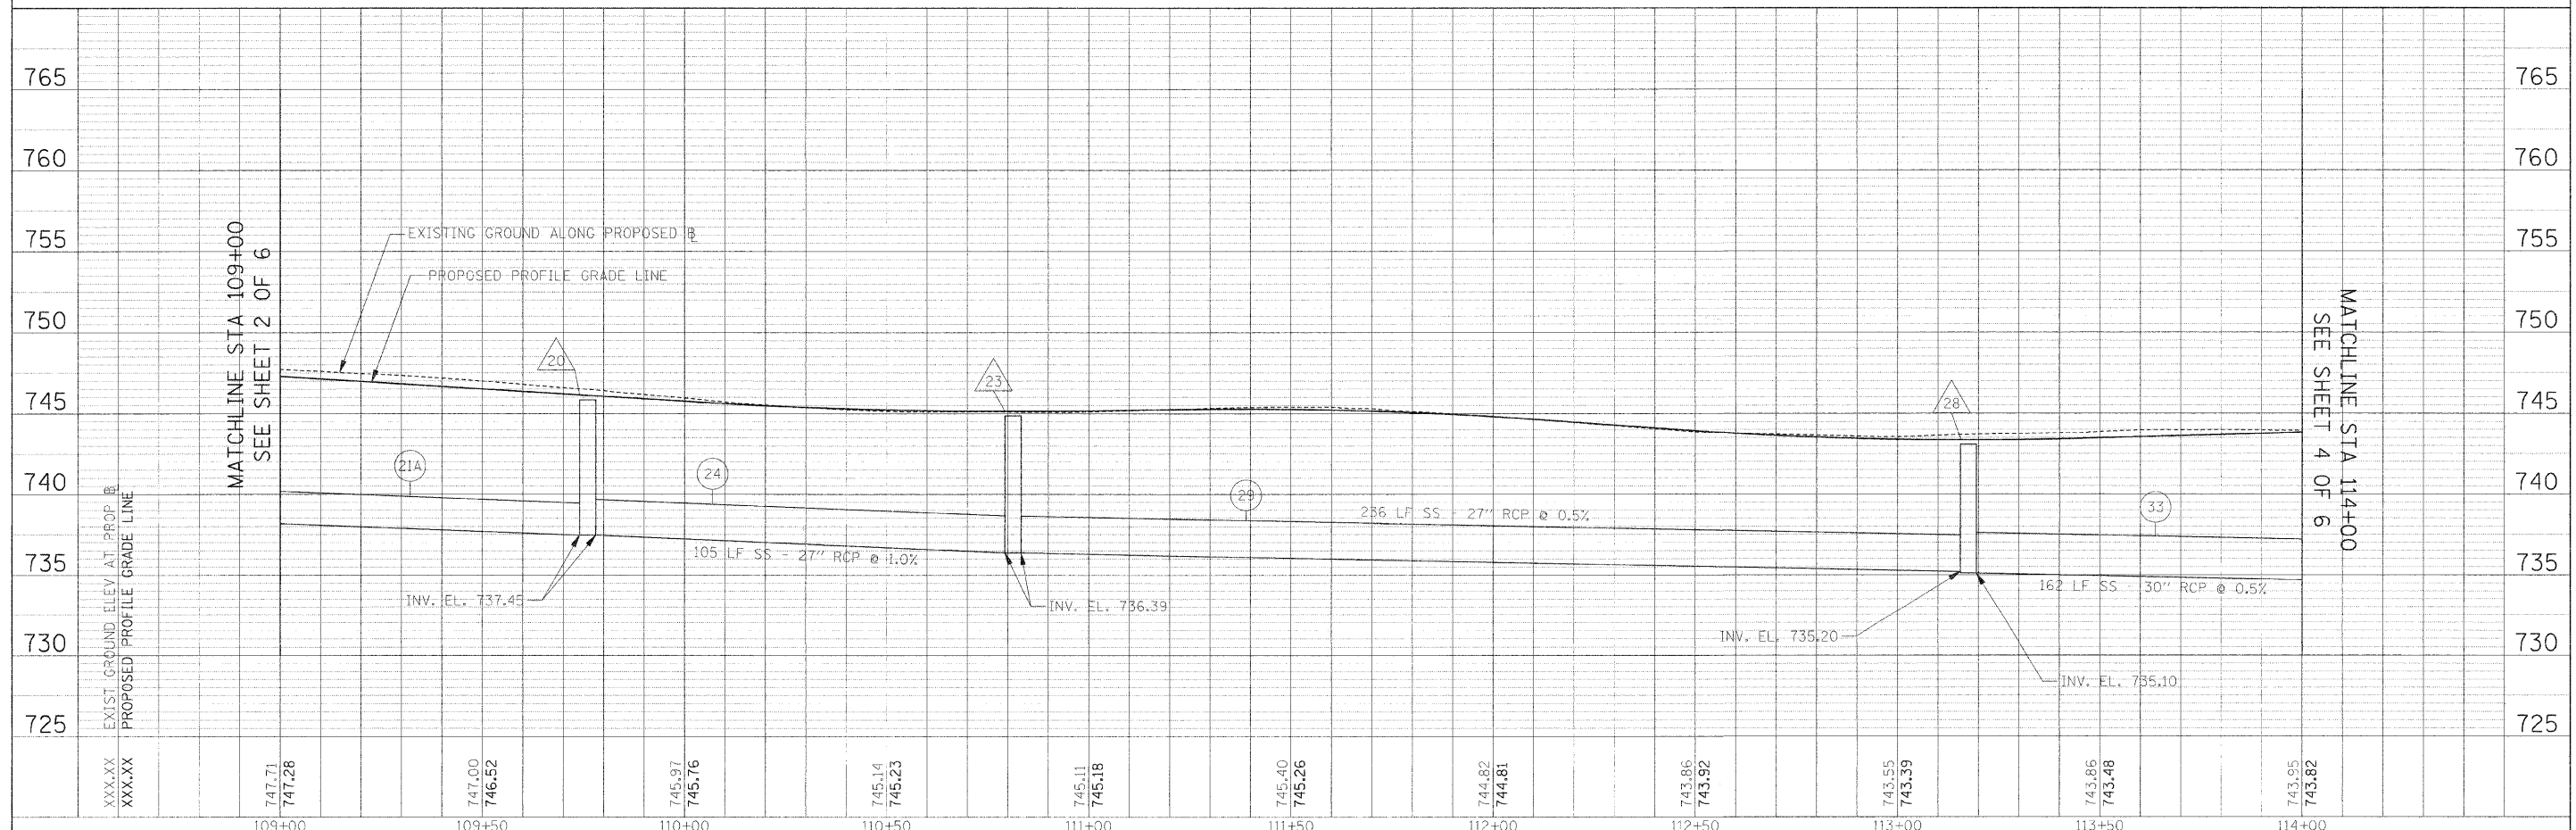

FILE NAME =	USER NAME = #USER#	DESIGNED - AJB	REVISED -	<b>STATE OF ILLINOIS DEPARTMENT OF TRANSPORTATION</b>	<b>DRAINAGE PLAN AND PROFILE</b>	F.A.U. RTE.	SECTION	COUNTY	TOTAL SHEETS	SHEET NO.	
#FILE#	PLLOT SCALE = #SCALE#	DRAWN - TMC	REVISED -			3003	00-00084-00-PV	DUPAGE	112	41	
	PLLOT DATE = #DATE#	CHECKED - DEB	REVISED -			BLACKHAWK DR RECONSTRUCTION		CONTRACT NO. 63121			
		DATE - 01/02/09	REVISED -			FED. ROAD DIST. NO. 1 ILLINOIS FED. AID PROJECT					

SCALE: 1:20      SHEET NO. 3 OF 6 SHEETS      STA. 109+00.00 TO STA. 114+00.00