

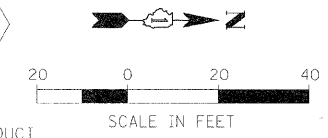
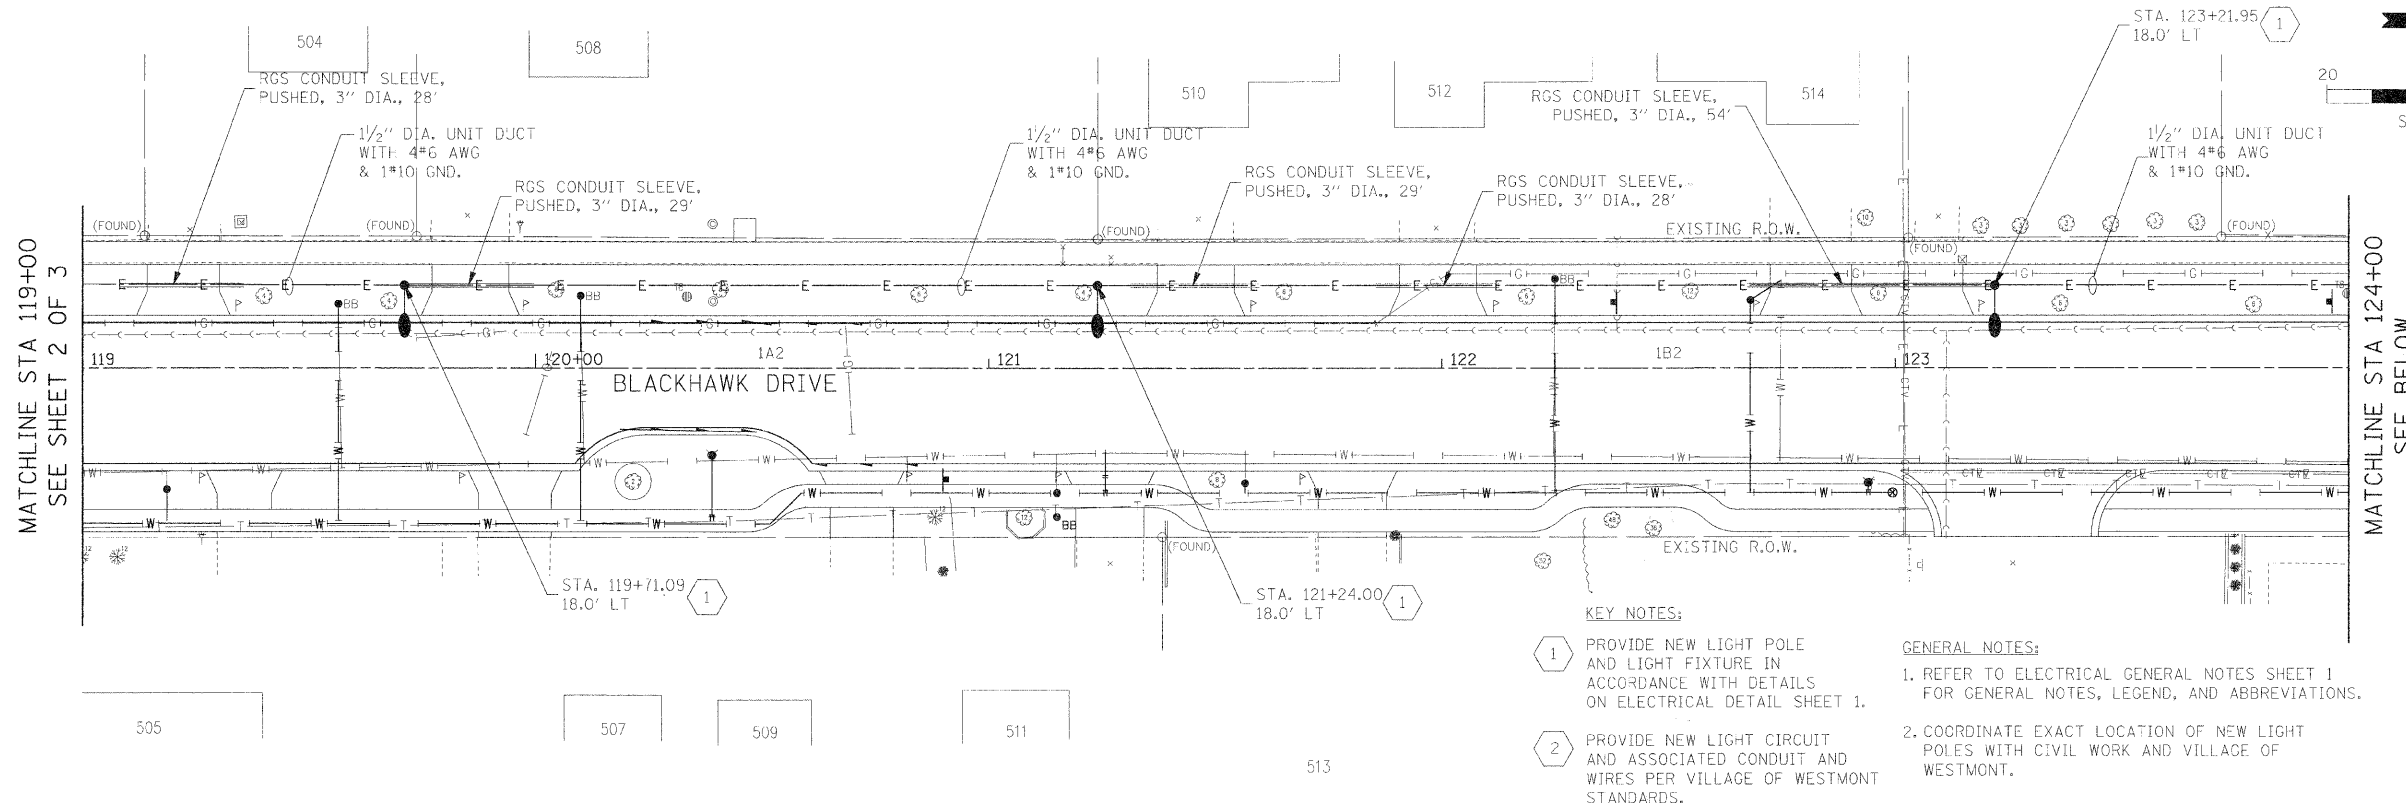


PLAN	DATE
DESIGNED	BY
CHECKED	DATE
DATE	BY
NO.	NO.
FILE NAME	FILE NAME

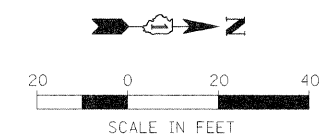

- KEY NOTES:**
- 1 PROVIDE NEW LIGHT POLE AND LIGHT FIXTURE IN ACCORDANCE WITH DETAILS ON ELECTRICAL DETAIL SHEET 1.
  - 2 PROVIDE NEW LIGHT CIRCUIT AND ASSOCIATED CONDUIT AND WIRES PER VILLAGE OF WESTMONT STANDARDS.
- GENERAL NOTES:**
- 1. REFER TO ELECTRICAL GENERAL NOTES SHEET 1 FOR GENERAL NOTES, LEGEND, AND ABBREVIATIONS.
  - 2. COORDINATE EXACT LOCATION OF NEW LIGHT POLES WITH CIVIL WORK AND VILLAGE OF WESTMONT.

PROFILE	DATE
DESIGNED	BY
CHECKED	DATE
DATE	BY
NO.	NO.
FILE NAME	FILE NAME

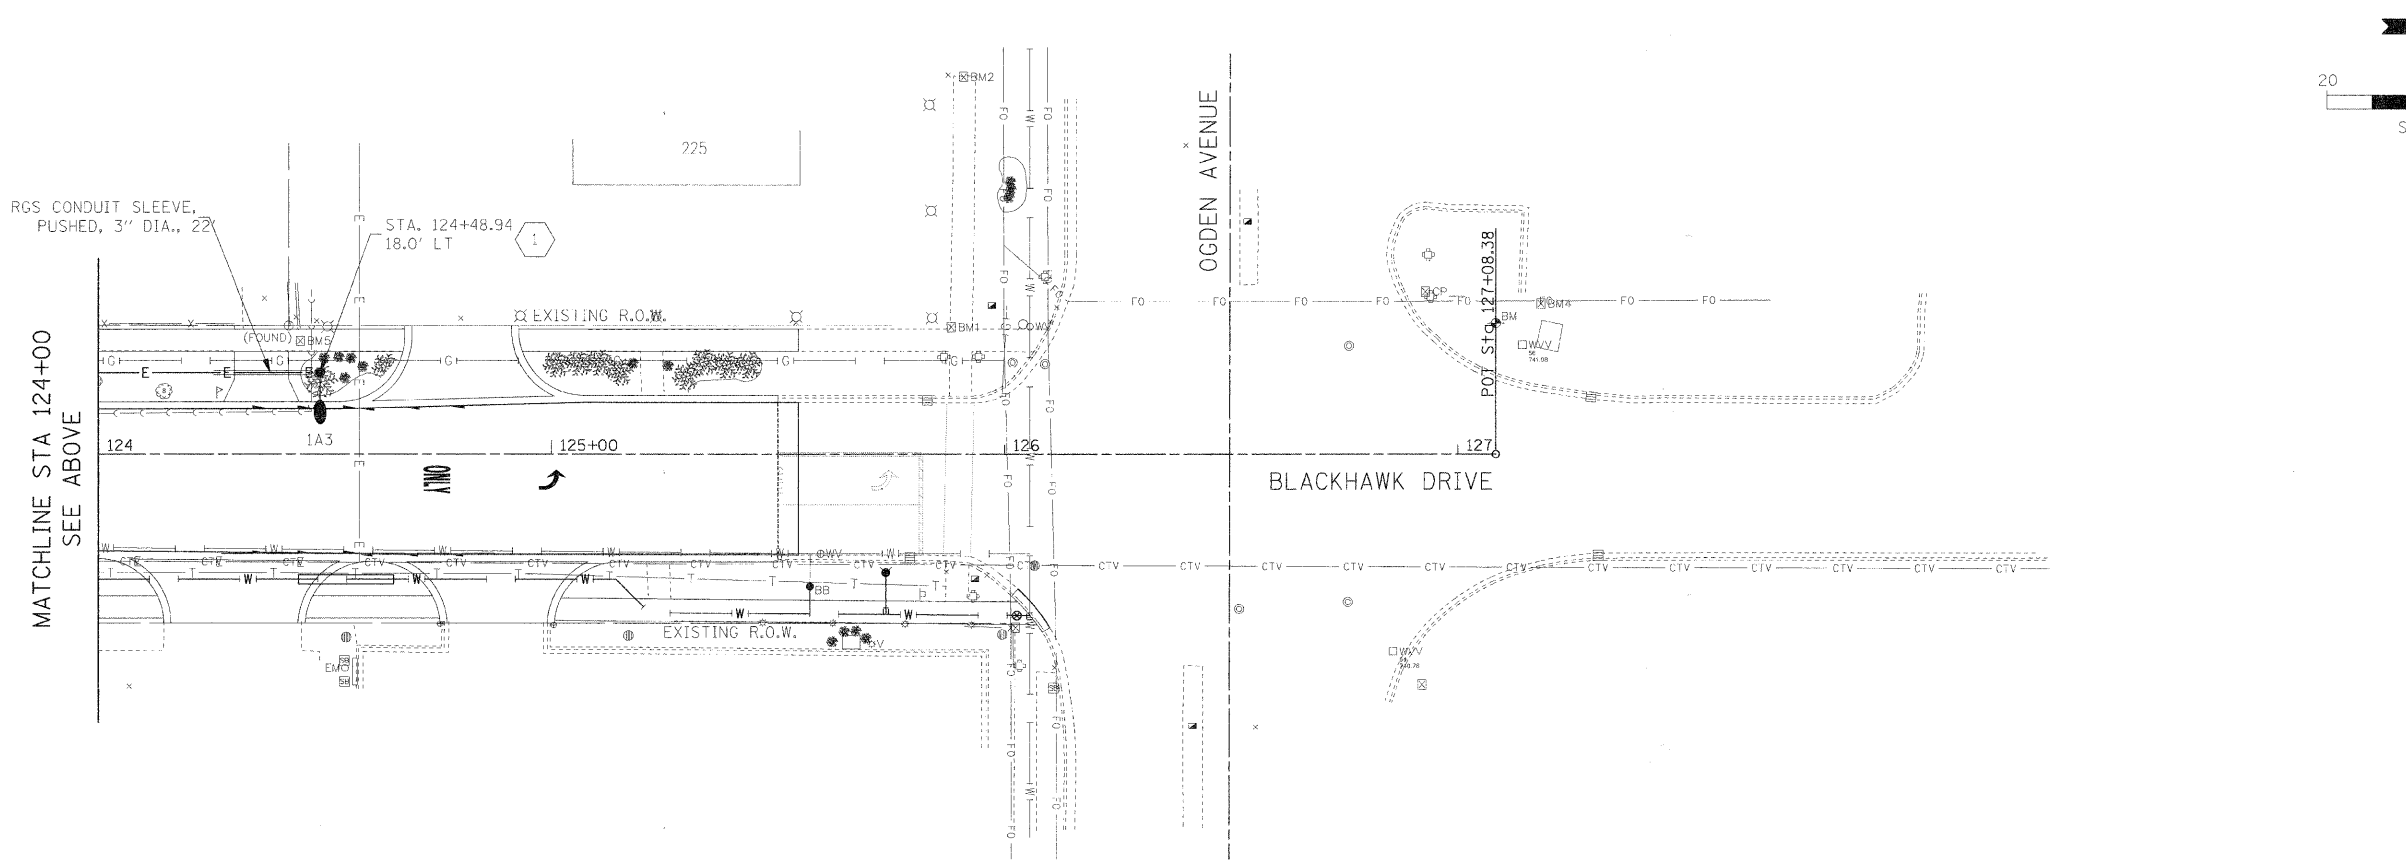

FILE NAME =	USER NAME = #USER#	DESIGNED - FE1	REVISED -	<b>STATE OF ILLINOIS DEPARTMENT OF TRANSPORTATION</b>	<b>PROPOSED LIGHTING PLAN</b>	F.A.U. R.T.E.	SECTION	COUNTY	TOTAL SHEETS	SHEET NO.		
#FILE_#		DRAWN - TMC	REVISED -			3003	00-00084-00-PV	DUPAGE	112	67		
		CHECKED - MAR	REVISED -			BLACKHAWK DR RECONSTRUCTION		CONTRACT NO. 63121				
		DATE - 01/02/09	REVISED -			SCALE: 1:20		SHEET NO. 3 OF 3 SHEETS		STA. 119+00.00 TO STA. 127+08.38		
						FED. ROAD DIST. NO. 1 ILLINOIS FED. AID PROJECT						