



DATE	
BY	
DESIGNED	
DRAWN	
CHECKED	
DATE	
NO.	

DATE	
BY	
DESIGNED	
DRAWN	
CHECKED	
DATE	
NO.	

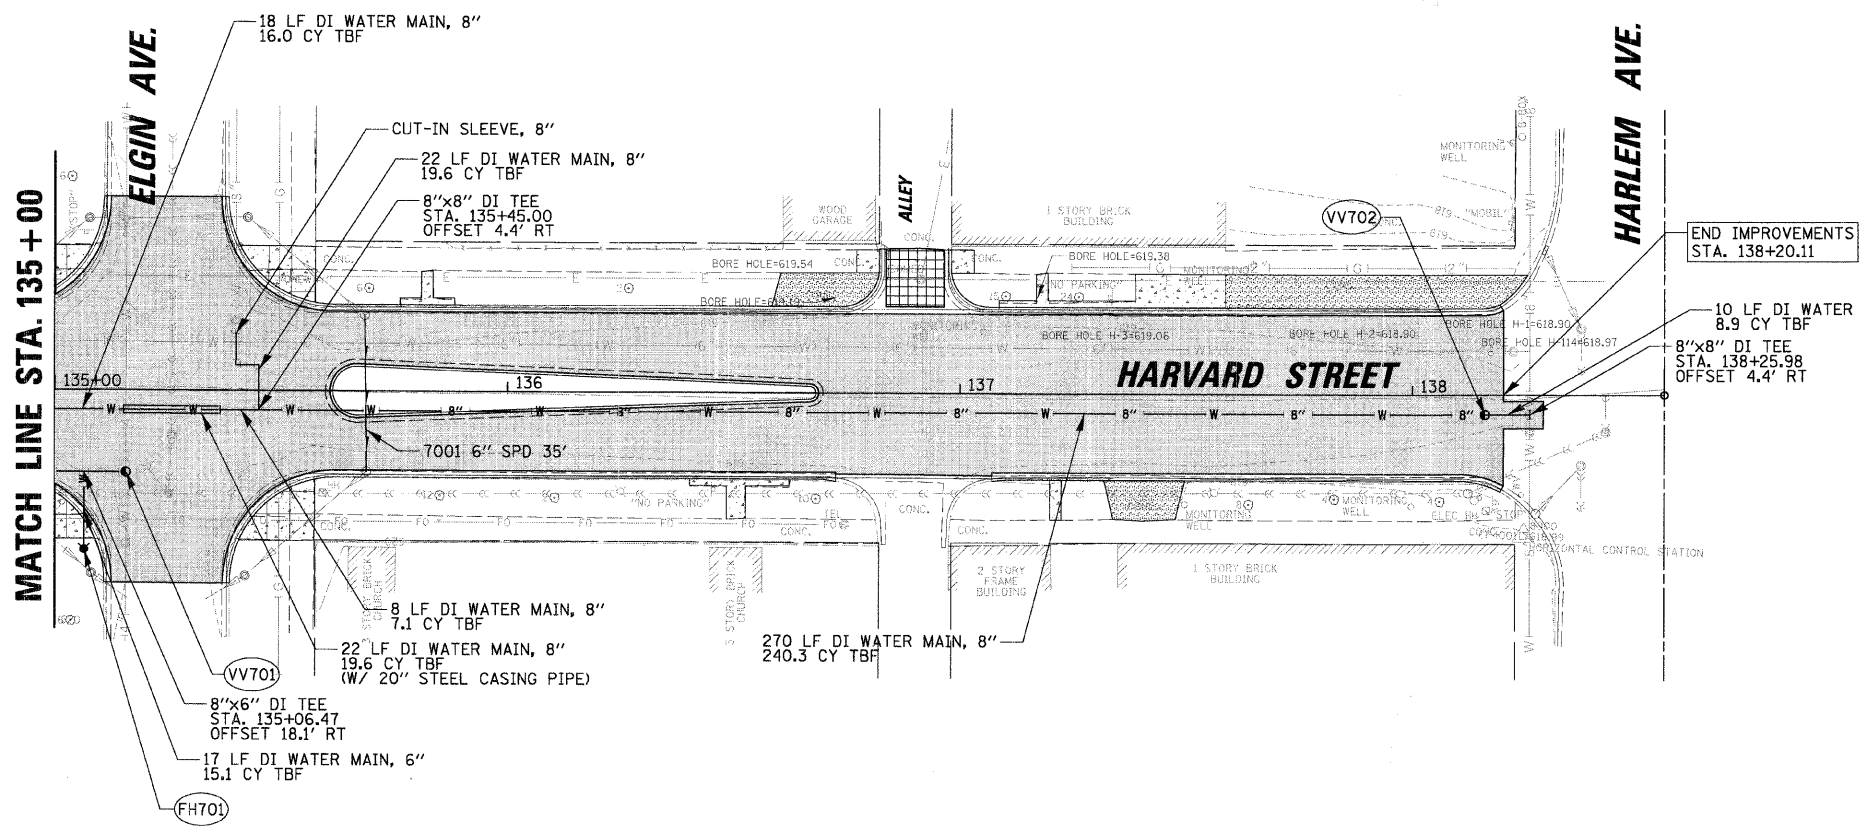

- LEGEND:**
- ⊙ FIRE HYDRANT W/AUXILIARY VALVE AND VALVE BOX
  - ⊙ VALVE VAULT
  - W — 8" — PROPOSED WATER MAIN
  - W — 8" — PROPOSED WATER MAIN (W/STEEL CASING PIPE)
  - S — PROPOSED STORM SEWER
  - C — PROPOSED COMBINED SEWER
  - U — PROPOSED PIPE UNDERDRAIN

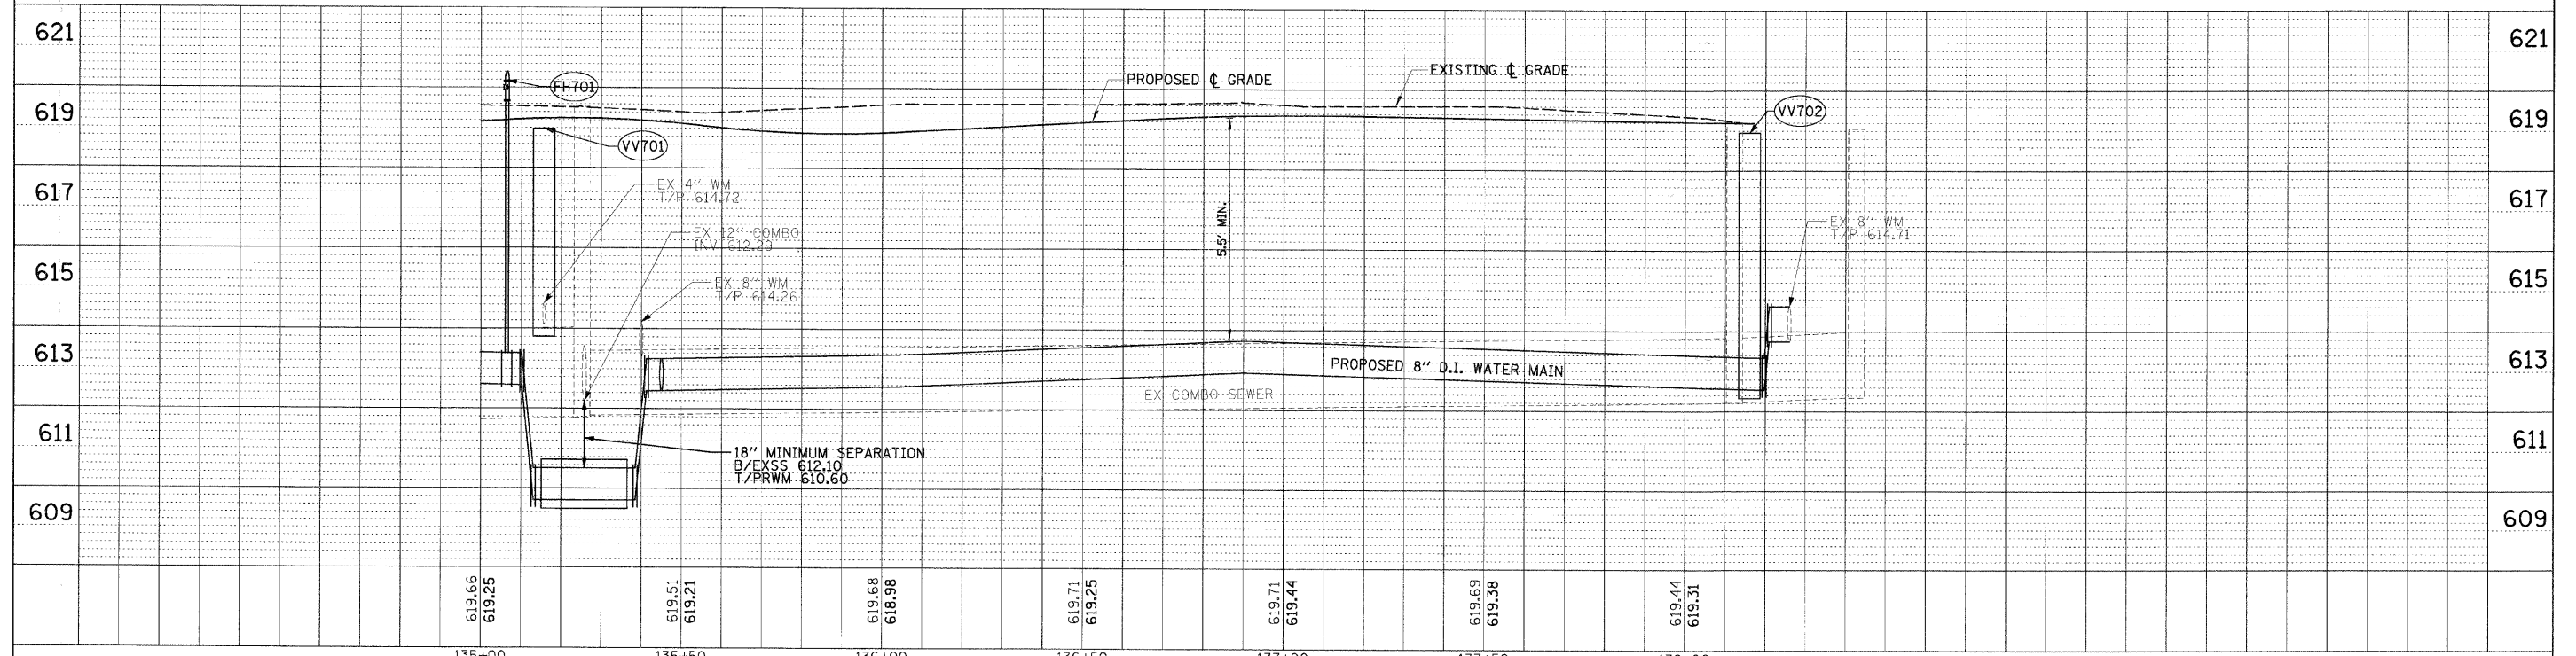

FILE NAME = N:\FORESTPARK\070082\Civil\DDP_070082_07.dwg	USER NAME = JBARNETT	DESIGNED -	REVISED -	<b>STATE OF ILLINOIS DEPARTMENT OF TRANSPORTATION</b>		<b>DRAINAGE AND UTILITIES PLAN AND PROFILE - HARVARD STREET STA. 135+00.00 TO STA. 138+20.11</b>		F.A.U. RTE. 1702	SECTION 07-00106-00-PV	COUNTY COOK	TOTAL SHEETS 75	SHEET NO. 28
PLOT SCALE = 20'	CHECKED -	REVISED -	CONTRACT NO. 63148									
PLOT DATE = 2/18/2009	DATE -	REVISED -	SCALE: SHEET NO. OF SHEETS STA. TO STA.									
FED. ROAD DIST. NO. 1 ILLINOIS FED. AID PROJECT												