
 
 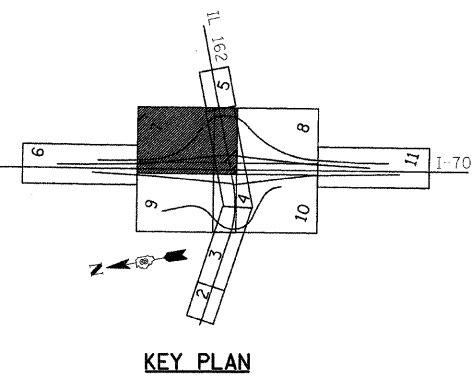



SECTION	COUNTY	TOTAL SHEETS	SHEET NO
70	MADISON	420	110
STA. 1340+00 TO STA. 1353+15.77		CONTRACT NO. 76709	
60-10K, 60-10-4HB			



PLAN	DATE
BY	
CHECKED	
NO. OF WAY CHECKED	
FILE NAME	

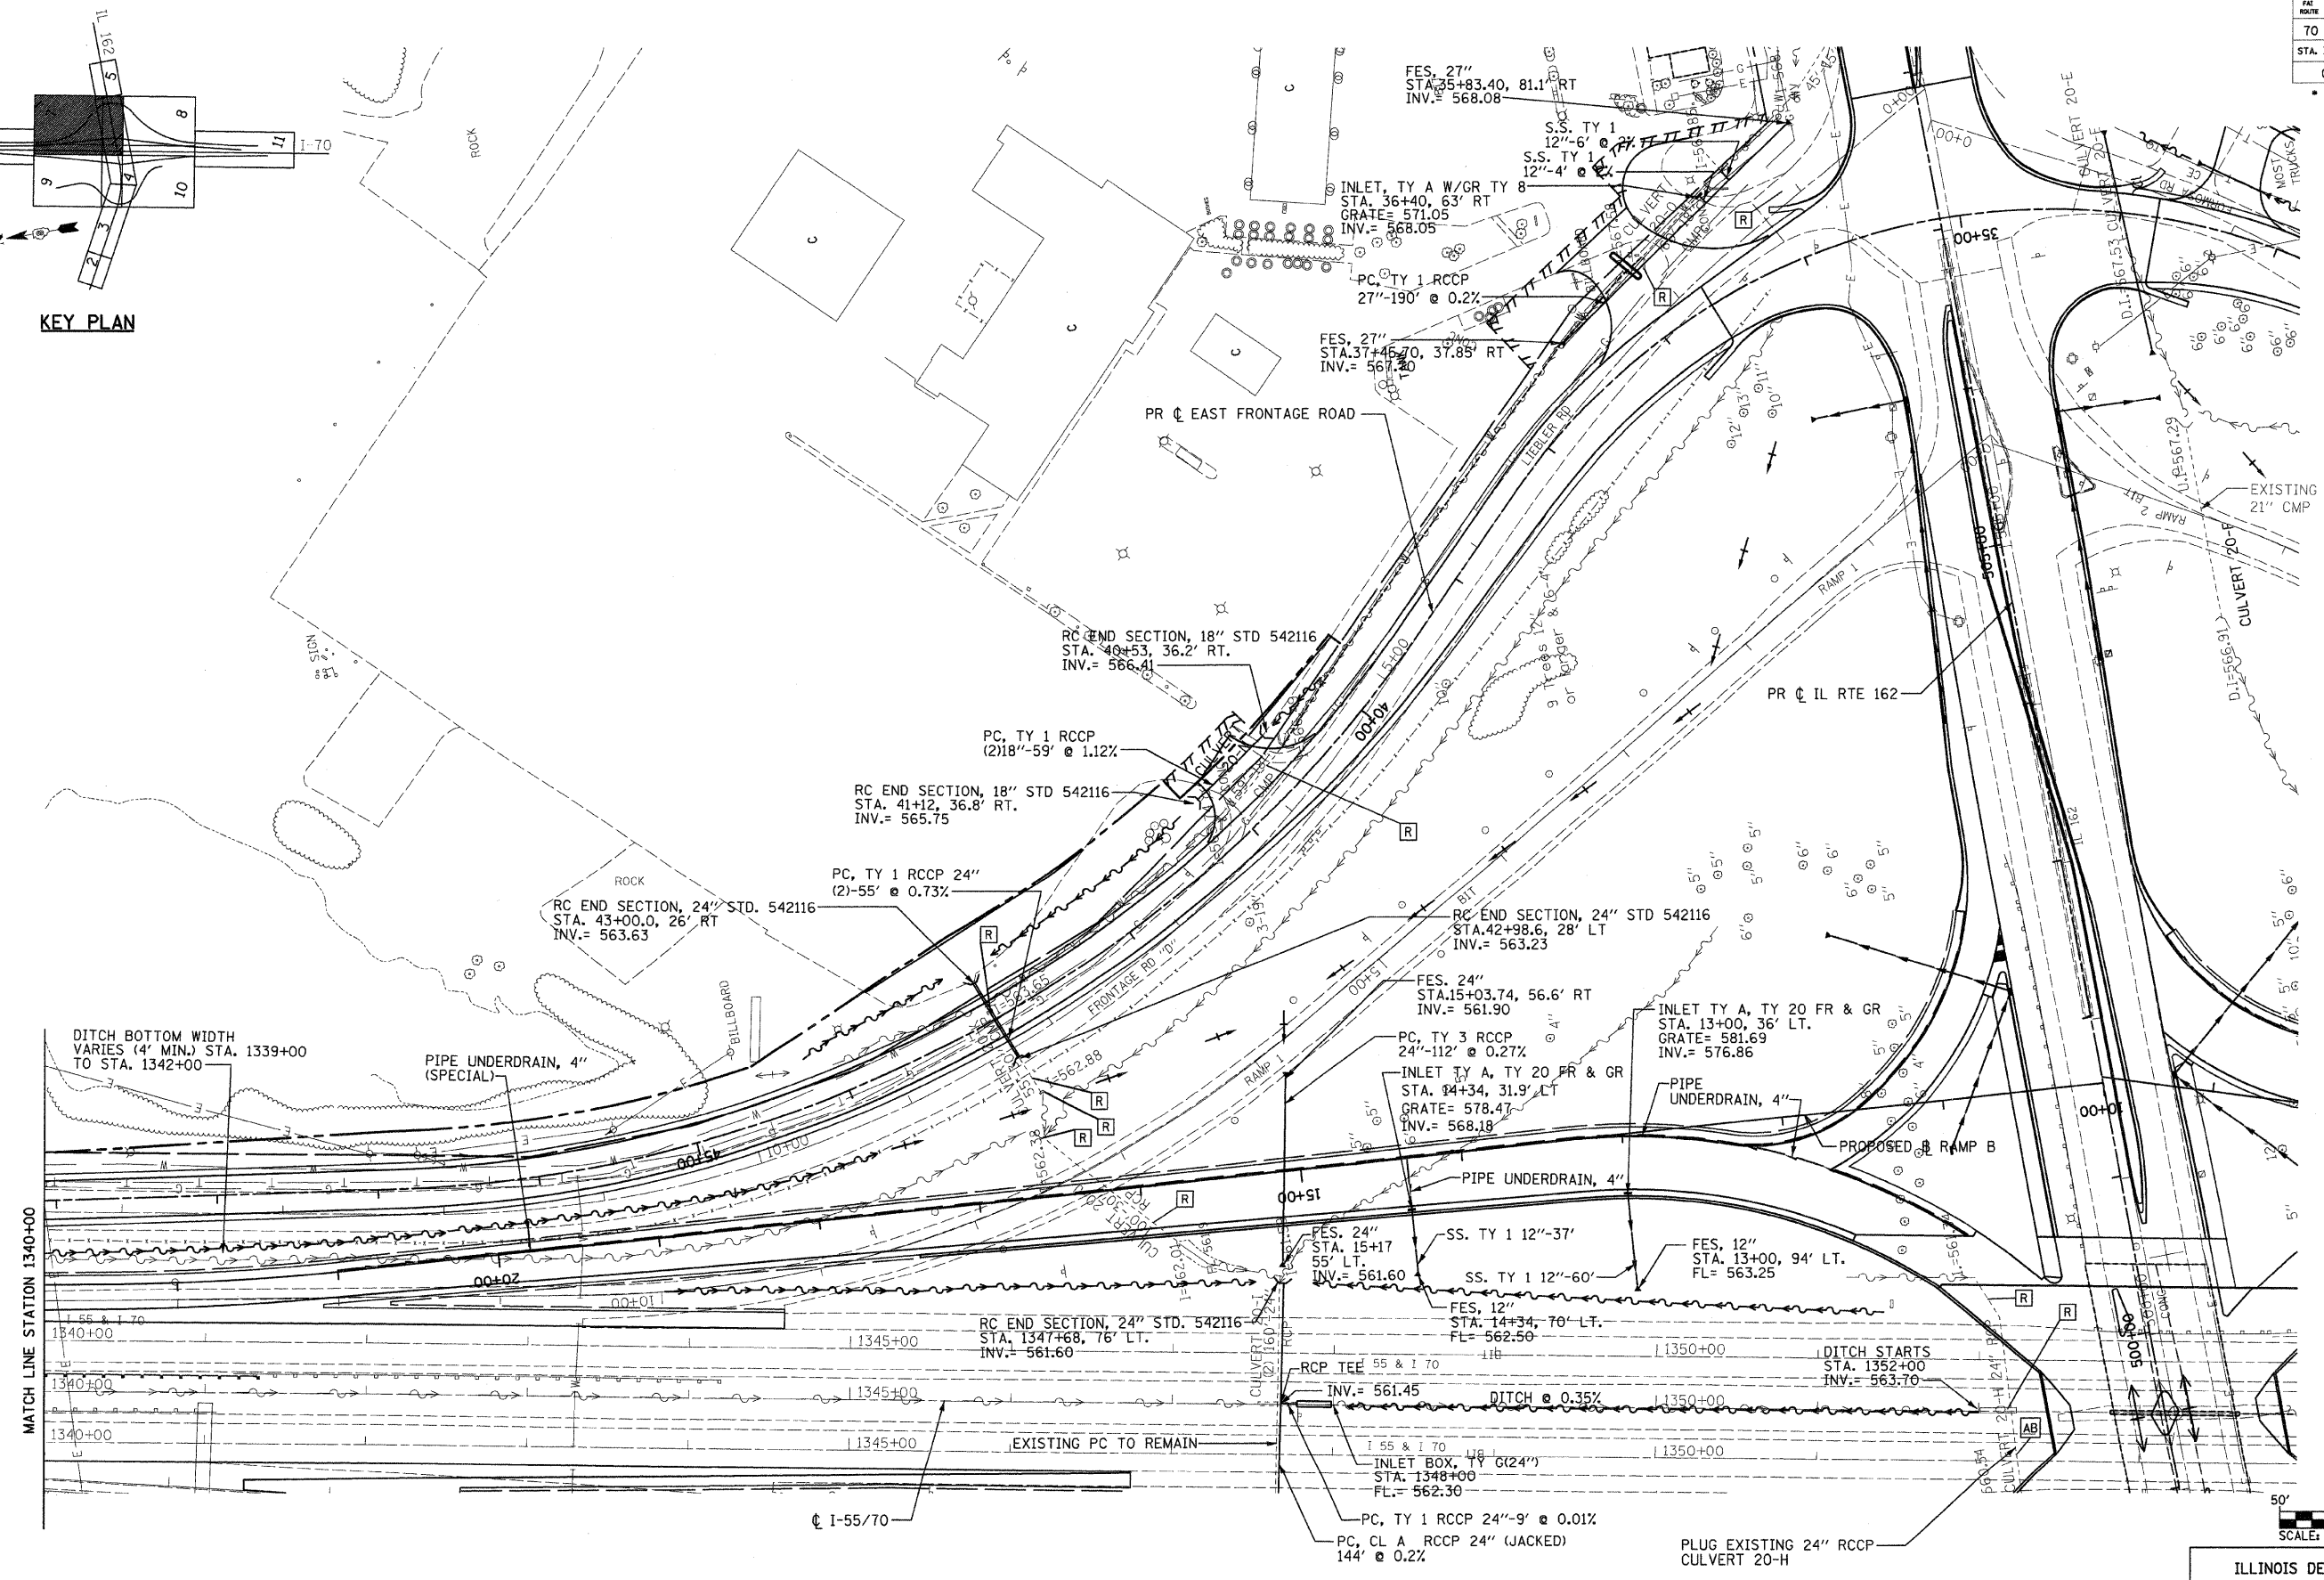

- NOTE:**
- FOR STORM SEWER INFORMATION AT IL 162, SEE PROPOSED DRAINAGE PLAN-4.
 - FOR DITCH PROFILES, SEE PROPOSED DRAINAGE PROFILE DRAWINGS.
 - FOR PROPOSED SWALE INFORMATION, SEE INTERCHANGE GRADING PLAN.

REVISIONS	
NAME	DATE

ILLINOIS DEPARTMENT OF TRANSPORTATION
PROPOSED DRAINAGE PLAN - 7

FAI ROUTE 70
SECTION 60-10K, 60-10-4HB
MADISON COUNTY

DRAWN BY: GRH
PLOT DATE: *DATE-TIME*

DATE-TIME
*BY: 5/25/01, JGP
*CHK: 5/25/01, JGP
*REF: 2/25/01, JGP
*REF: 2/25/01, JGP
*REF: 2/25/01, JGP