
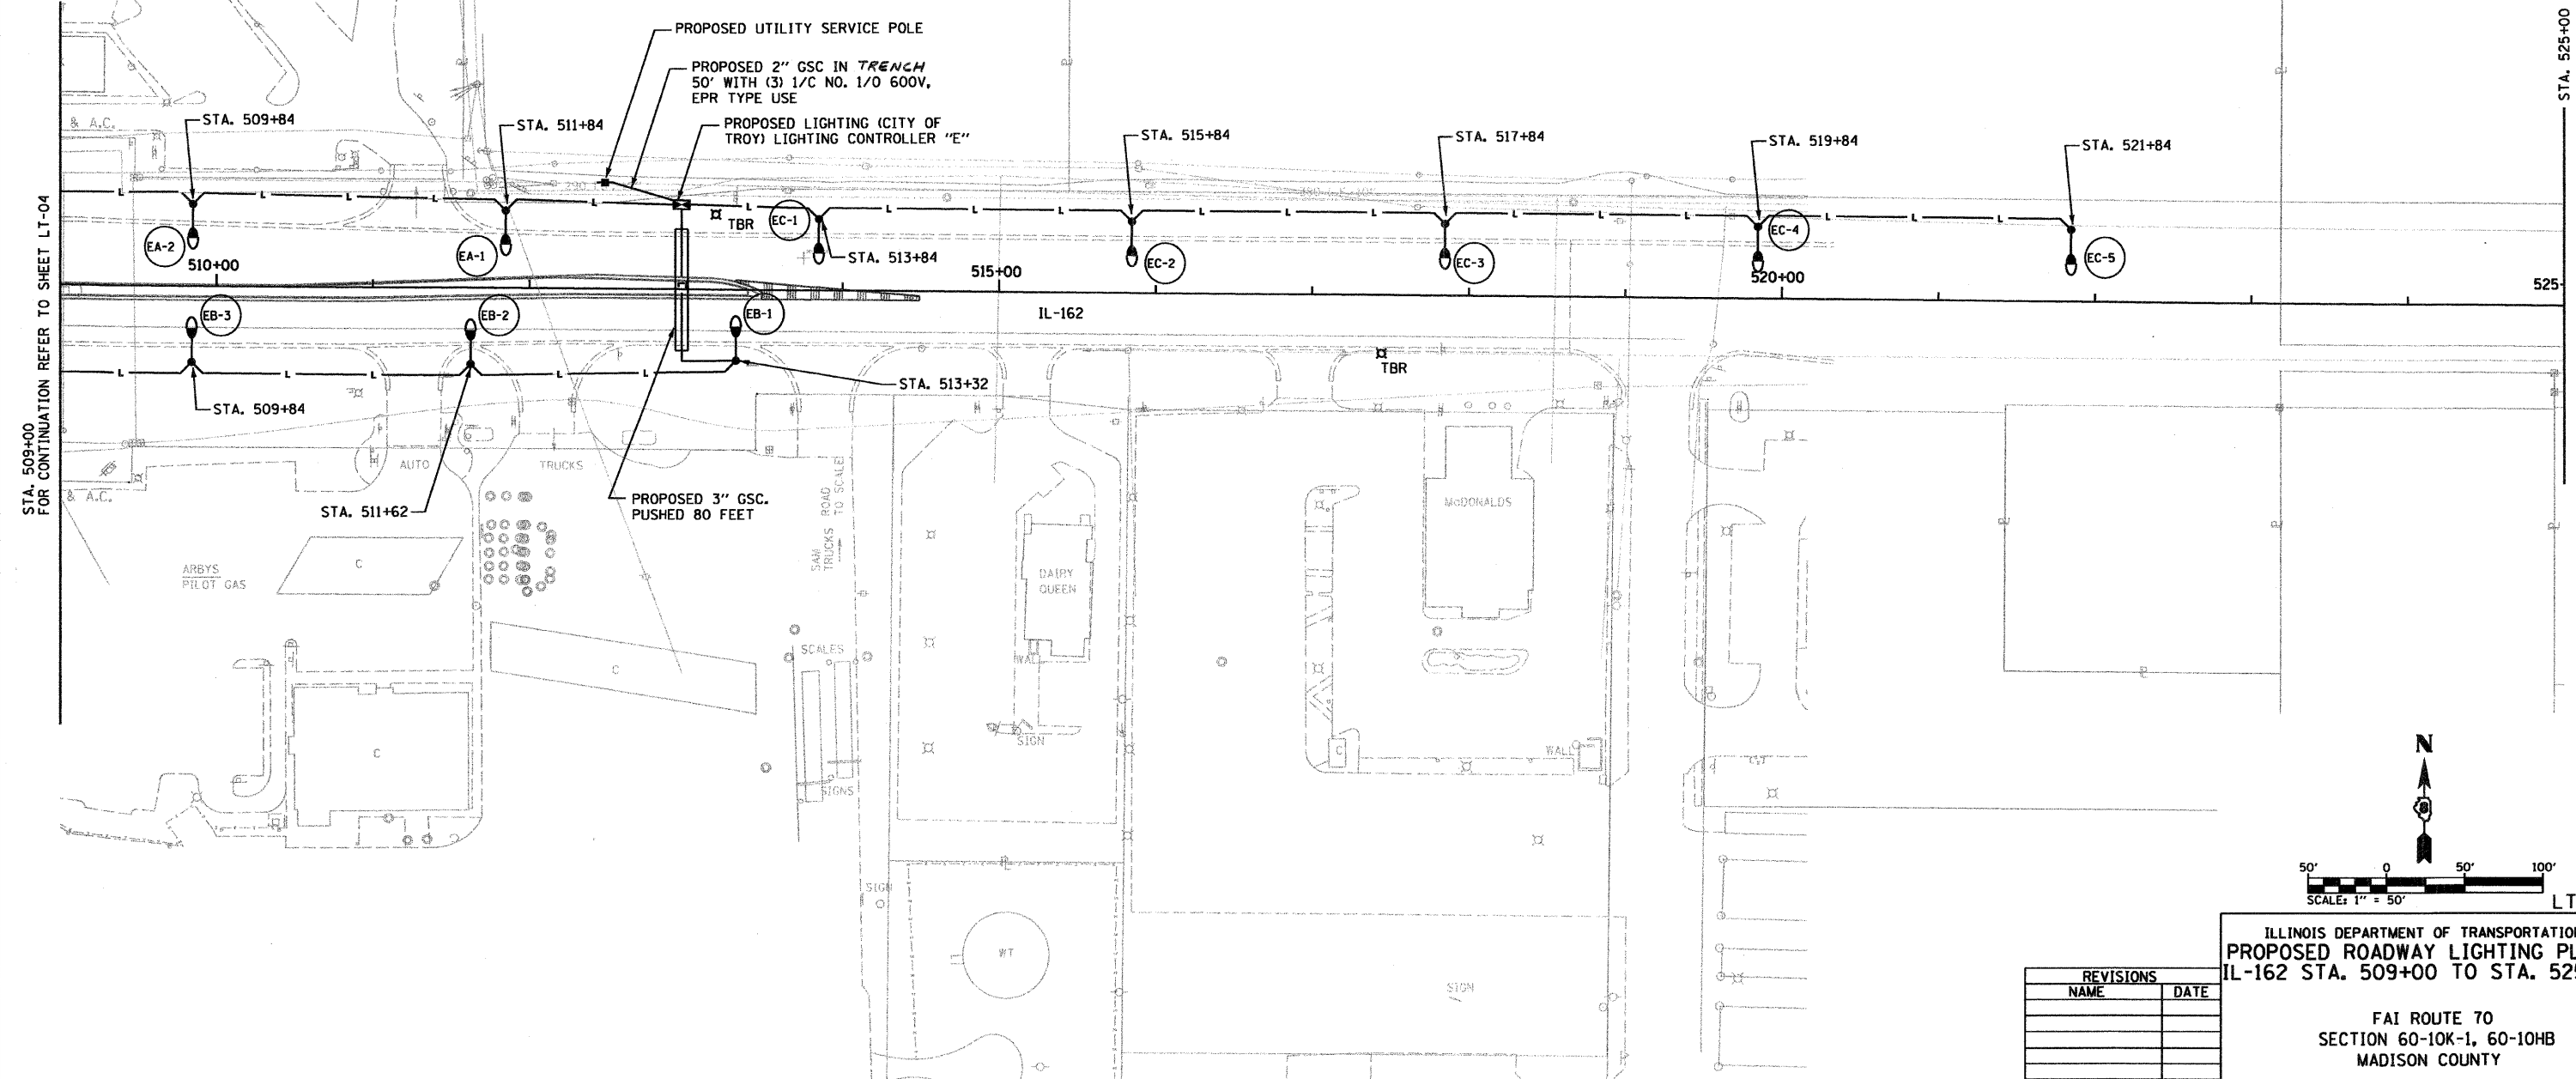


FAP NO.	SECTION	COUNTY	TOTAL SHEETS	SHEET NO.
70	60-10 (K-1,HB)	MADISON	420	182
STA. TO STA.		CONTRACT NO.: 76709		

**NOTES:**  
 1. ALL UNIT DUCT ON THIS SHEET SHALL BE 6" (2" 6 XLP, 1" 6 XLP, 1.0P) UNLESS NOTED OTHERWISE.


**LEGEND**  
 TBR - TO BE REMOVED  
 REMOVE POLE  
 REMOVE AND SALVAGE LUMINAIRE  
 REMOVE FOUNDATION

PLAN	DATE
BY	
REVISION	
NO.	
NO.	
NO.	
NO.	
NO.	
NO.	
NO.	

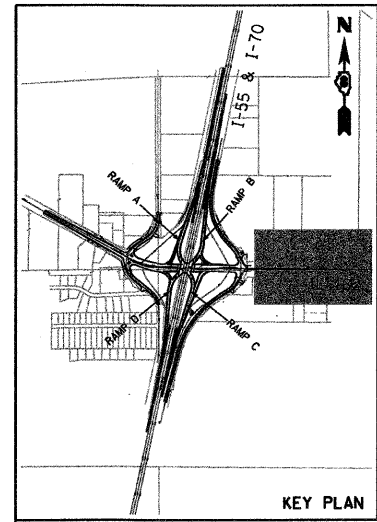

STA. 509+00  
 FOR CONTINUATION REFER TO SHEET LT-04

STA. 525+00

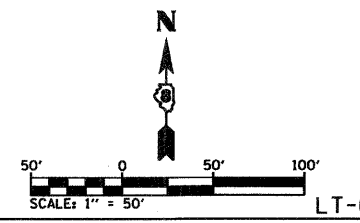

REVISIONS	
NAME	DATE

ILLINOIS DEPARTMENT OF TRANSPORTATION  
**PROPOSED ROADWAY LIGHTING PLAN**  
 IL-162 STA. 509+00 TO STA. 525+00

FAI ROUTE 70  
 SECTION 60-10K-1, 60-10HB  
 MADISON COUNTY

DRAWN BY: RPJ      CHECKED BY: A. OSHANA, P.E.

XXXXXXX - IDOT IL 162 over I-55,70 revisions  
 236-LT-05.dgn  
 1/28/2009  
 1:29:33 PM  
 Robert L. Swanson