
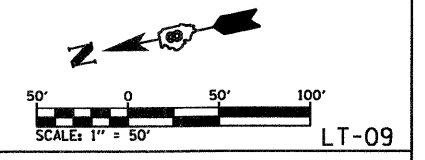
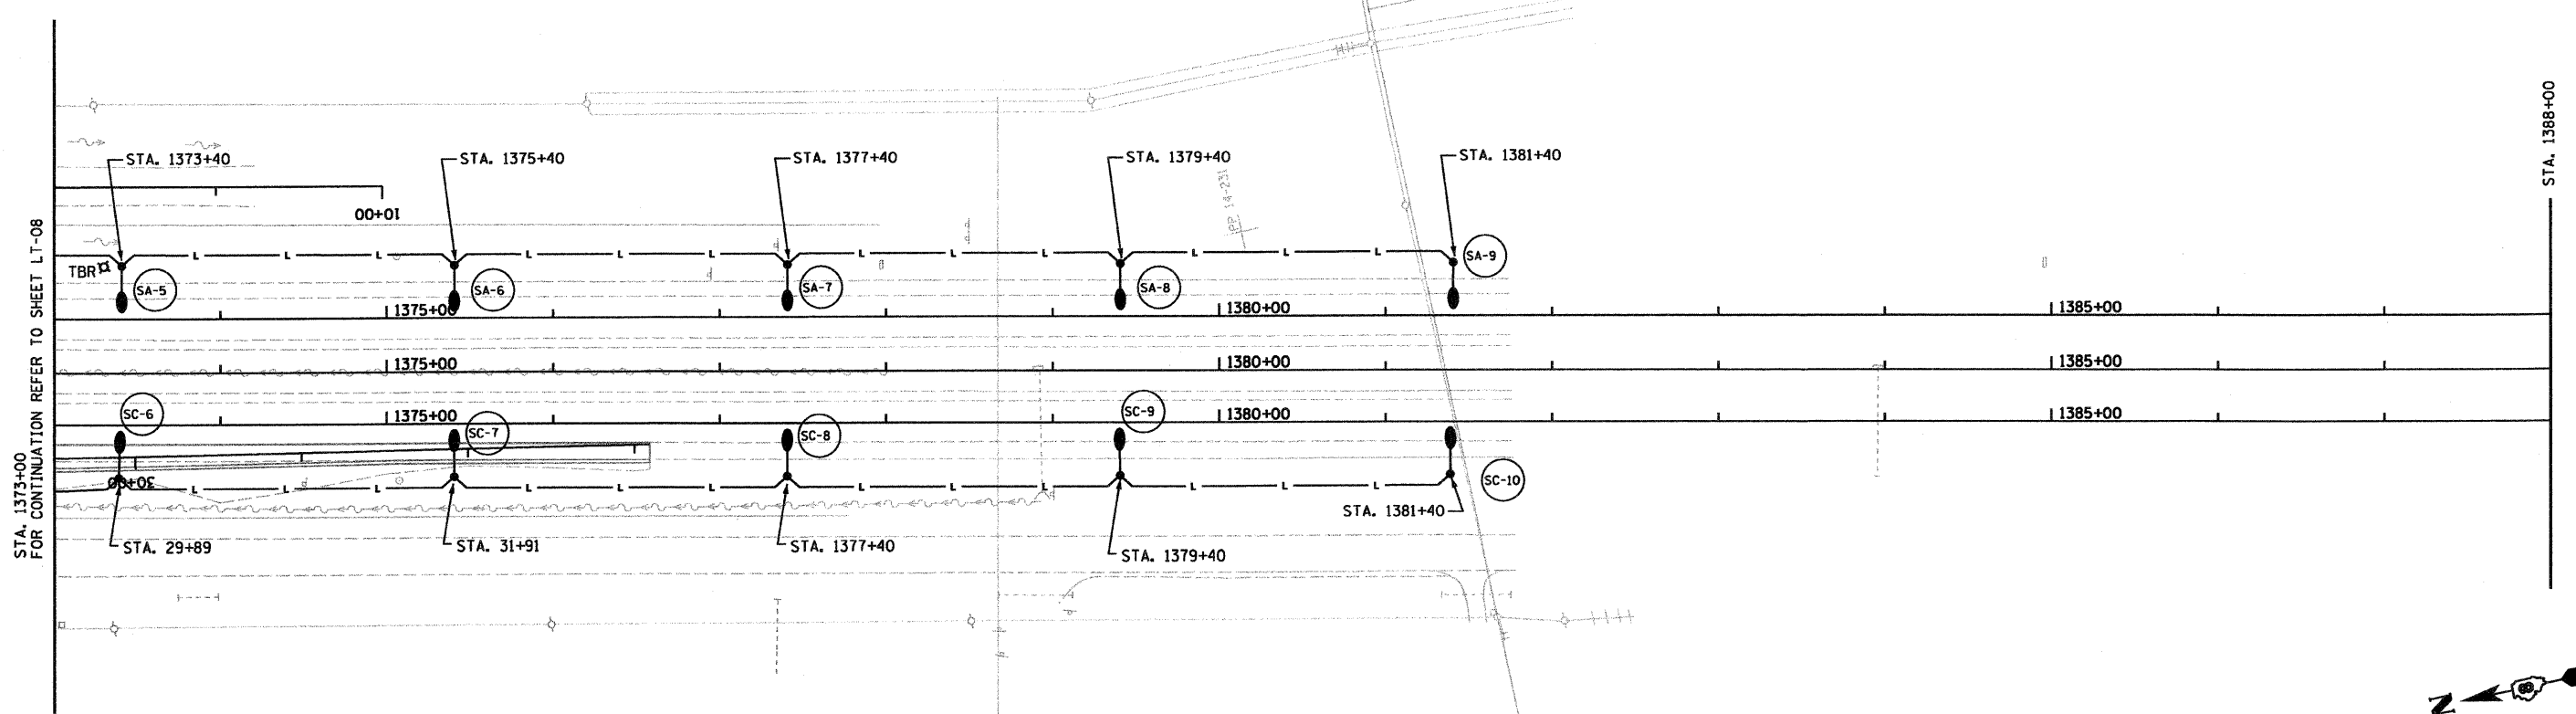


F&P ROUTE	SECTION	COUNTY	TOTAL SHEETS	SHEET NO.
70	60-10 (K-1,HB)	MADISON	420	186
STA.		TO STA.		
CONTRACT NO.: 76709				

NOTES:
 1. ALL UNIT DUCT ON THIS SHEET SHALL BE 4" (2" 4 XLP, 1" 4 XLPG, 1.0P) UNLESS NOTED OTHERWISE.

LEGEND
 TBR - TO BE REMOVED
 REMOVE POLE
 REMOVE AND SALVAGE LUMINAIRE
 REMOVE FOUNDATION

PLAN	DATE	BY
REVIEWED		
APPROVED		
NOTE BOOK		
NO.		

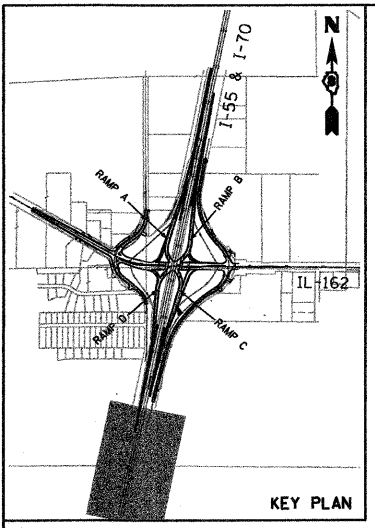

REVISIONS	
NAME	DATE

ILLINOIS DEPARTMENT OF TRANSPORTATION
PROPOSED ROADWAY LIGHTING PLAN
 I-55/70 STA. 1373+00 TO STA. 1388+00
 FAI ROUTE 70
 SECTION 60-10K-1, 60-10HB
 MADISON COUNTY
 DRAWN BY: RPJ CHECKED BY: A. OSHANA, P.E.

XXXXXX - IDOT IL 162 over I-55.70 revisions
 236-LI-09.dgn
 1/28/2009
 1:06:44 PM
 Robert Swanson