
 



 





FAP NO.	SECTION	COUNTY	TOTAL SHEETS	SHEET NO.
70	60-10 (K-1,10B)	MADISON	420	202
STA.		TO STA.		
CONTRACT NO. 76709				


**EXISTING TRAFFIC SIGNALS LEGEND**

- CONTROLLER 
- SERVICE INSTALLATION 
- SIGNAL HEAD 
- SIGNAL HEAD WITH BACKPLATE 
- SIGNAL POST 
- MAST ARM ASSEMBLY AND POLE, ALUMINUM 
- HANDHOLE 
- DOUBLE HANDHOLE 


- NOTES**
- TEMPORARY TRAFFIC SIGNAL INSTALLATION SHALL REMAIN IN USE DURING CONSTRUCTION UNTIL NEW SIGNALS ARE READY FOR OPERATION.
  - REFER TO LIGHTING PLANS FOR THE REMOVAL OF LIGHT UNITS AND FOUNDATIONS.
  - "TBR" INDICATES EQUIPMENT TO BE REMOVED

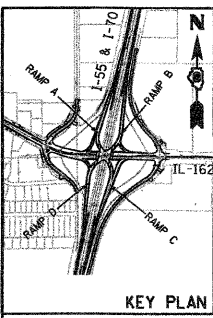

PLAN	DATE	BY
SURVEYED		
DESIGNED		
CHECKED		
IN CHARGE		
NO.		

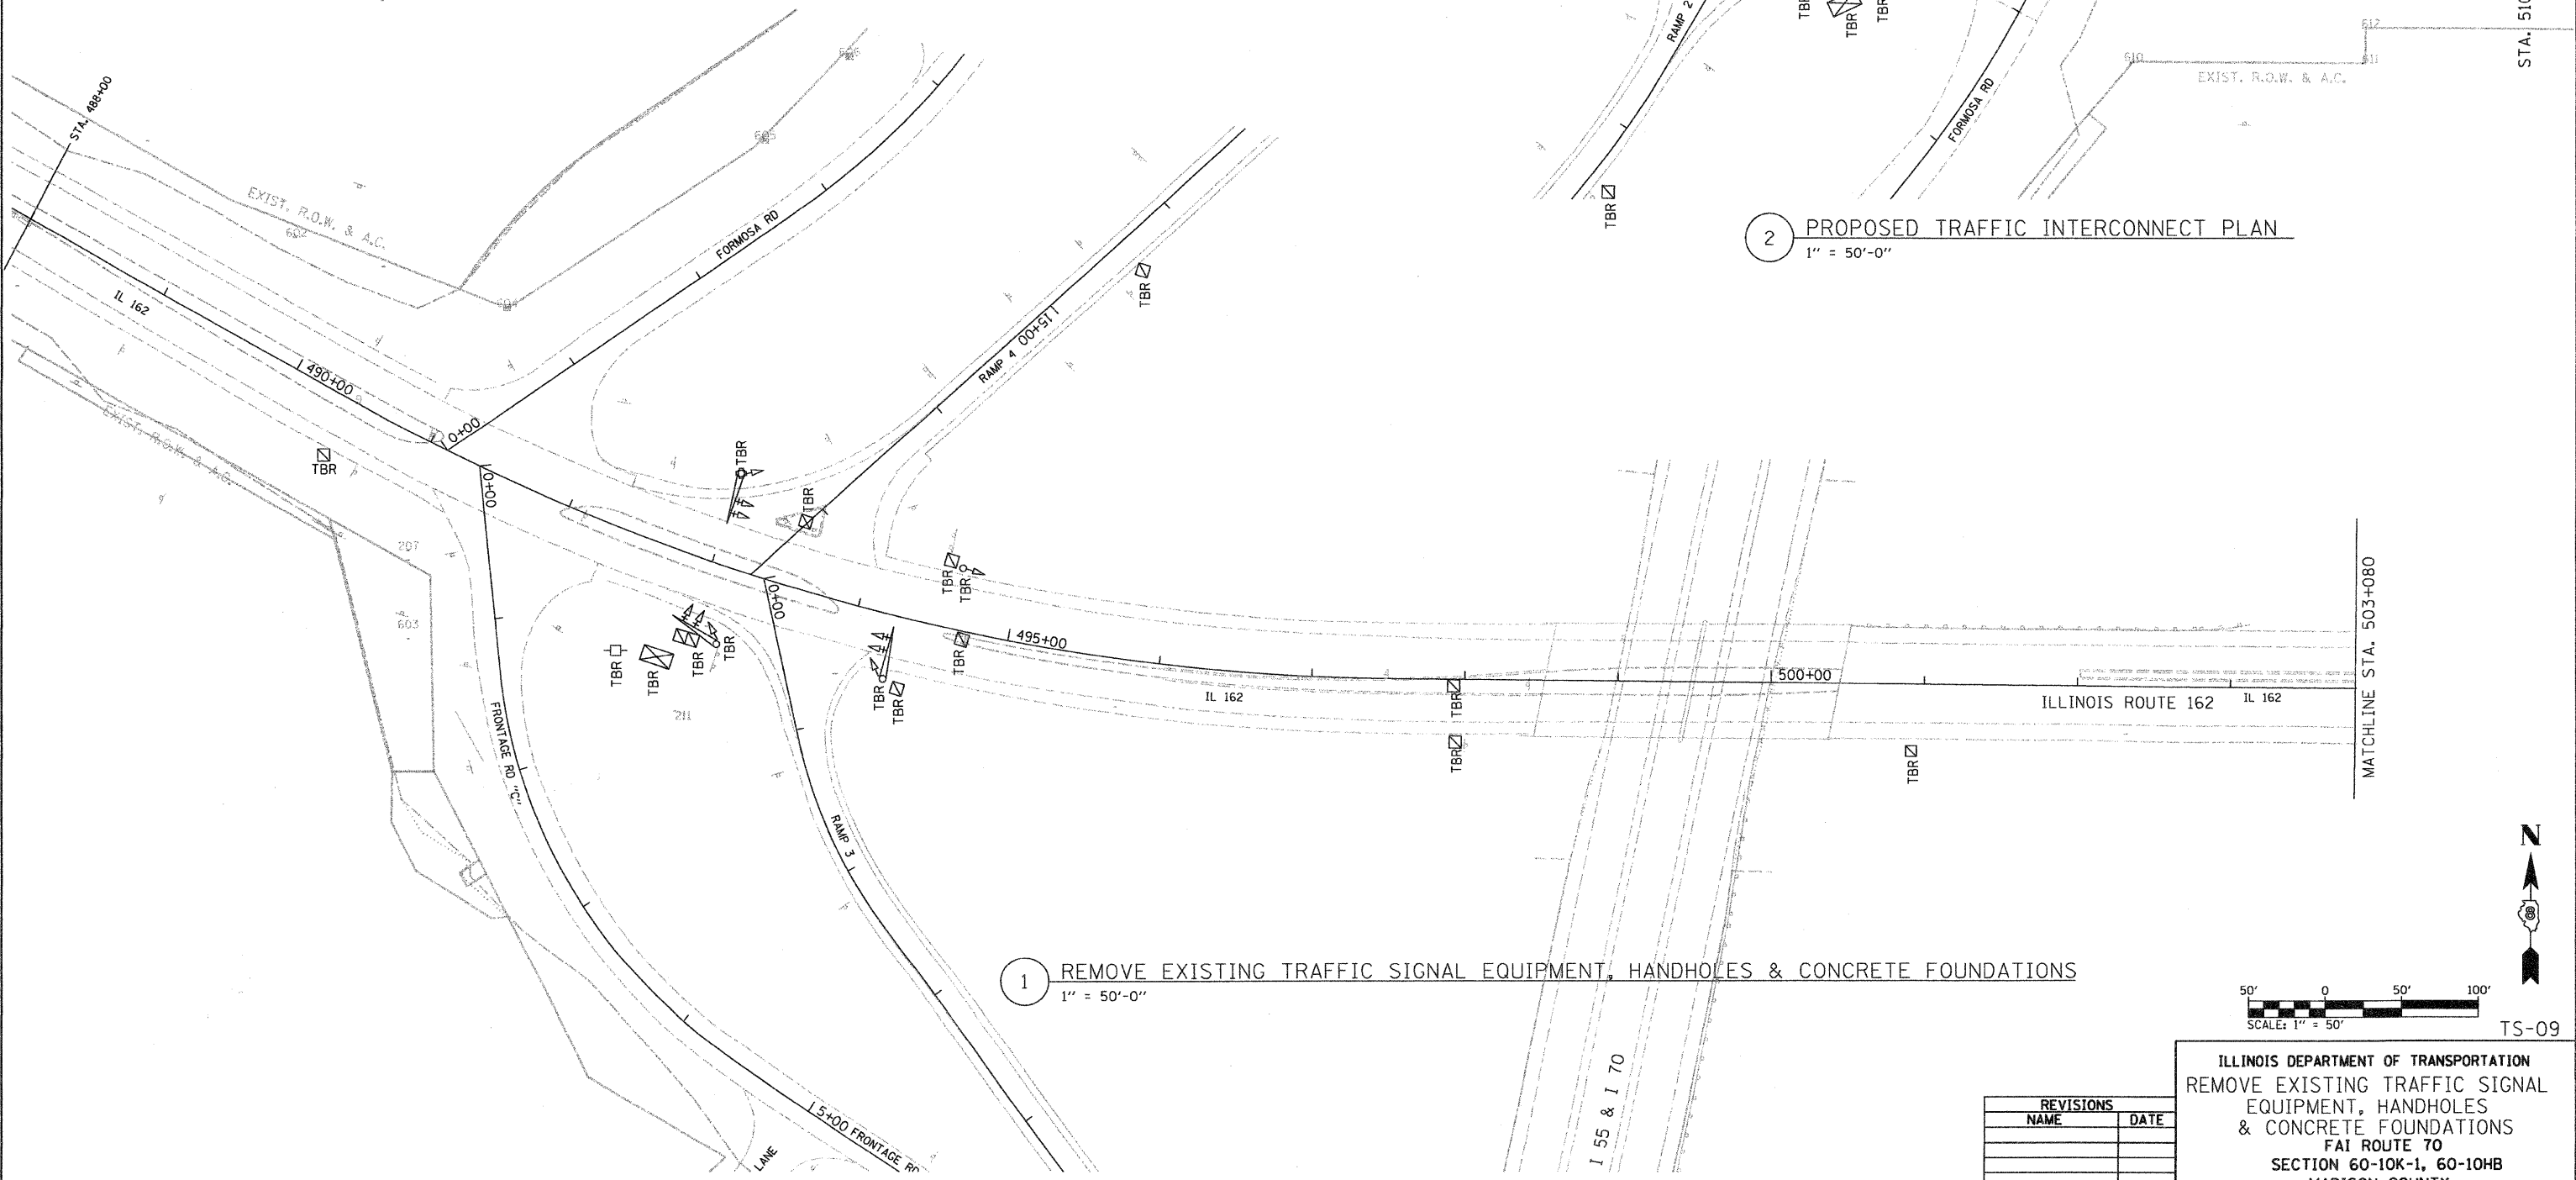

**1 REMOVE EXISTING TRAFFIC SIGNAL EQUIPMENT, HANDHOLES & CONCRETE FOUNDATIONS**  
1" = 50'-0"

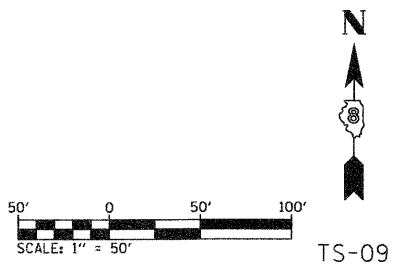

REVISIONS	
NAME	DATE

ILLINOIS DEPARTMENT OF TRANSPORTATION  
REMOVE EXISTING TRAFFIC SIGNAL  
EQUIPMENT, HANDHOLES  
& CONCRETE FOUNDATIONS  
FAI ROUTE 70  
SECTION 60-10K-1, 60-10HB  
MADISON COUNTY

DRAWN BY: RPJ CHECKED BY: A. OSHANA, P.E.

XXXXXX - IDOT IL 162 over I-55, 70 revisions  
236-TS-09-Removal\_Plan.dwg  
1/28/2009  
5:01:23 PM  
Robert Swanson