
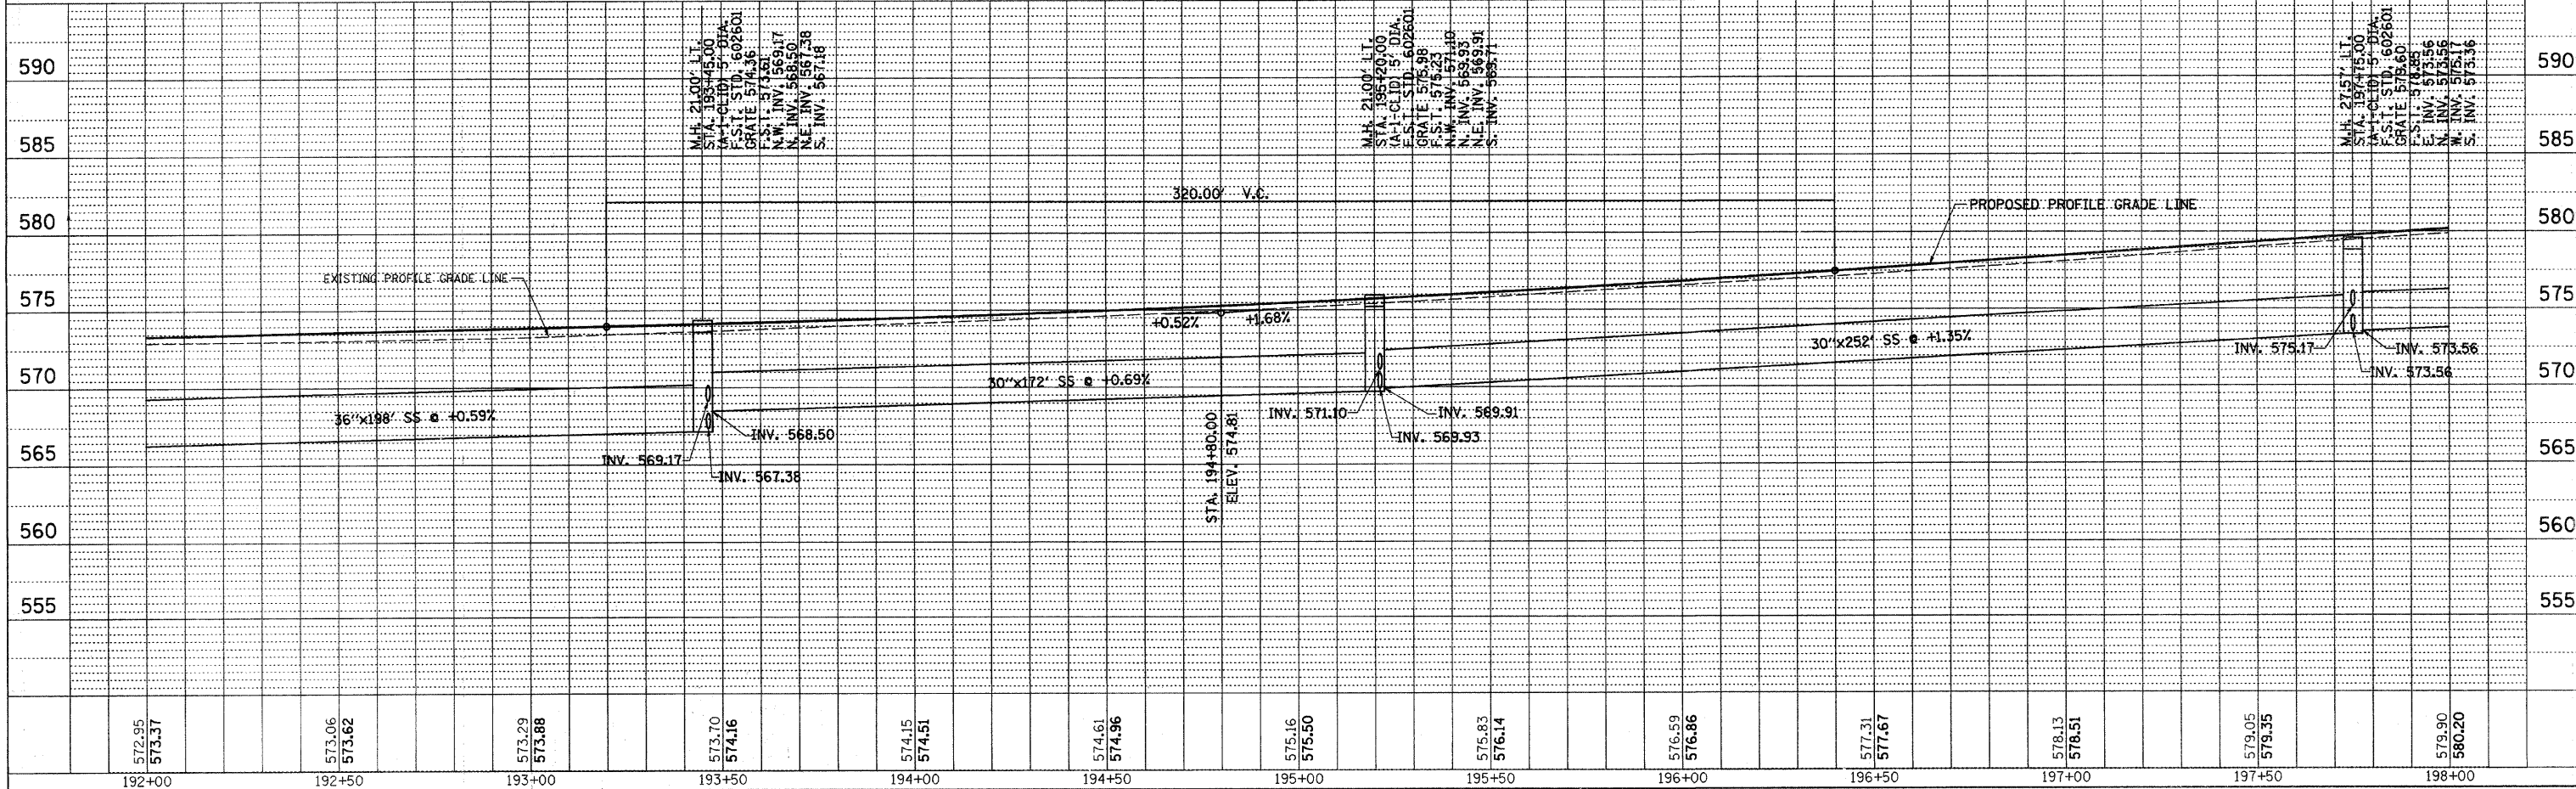


RTE. NO.	SECTION	COUNTY	TOTAL SHEETS	SHEET NO.
CH 2006-00275-00-PV		LOGSALLE	218	73
STA. 192+00		TO STA. 198+00		
FED. ROAD DIST. NO. 3 ILLINOIS FED. AID PROJECT				

CONTRACT NO. 87352

PLAN	DATE
SURVEYED	
ALIGNED	
CHECKED	
BY	
NO.	

PROFILE	DATE
SURVEYED	
PLotted	
CHECKED	
BY	
NO.	

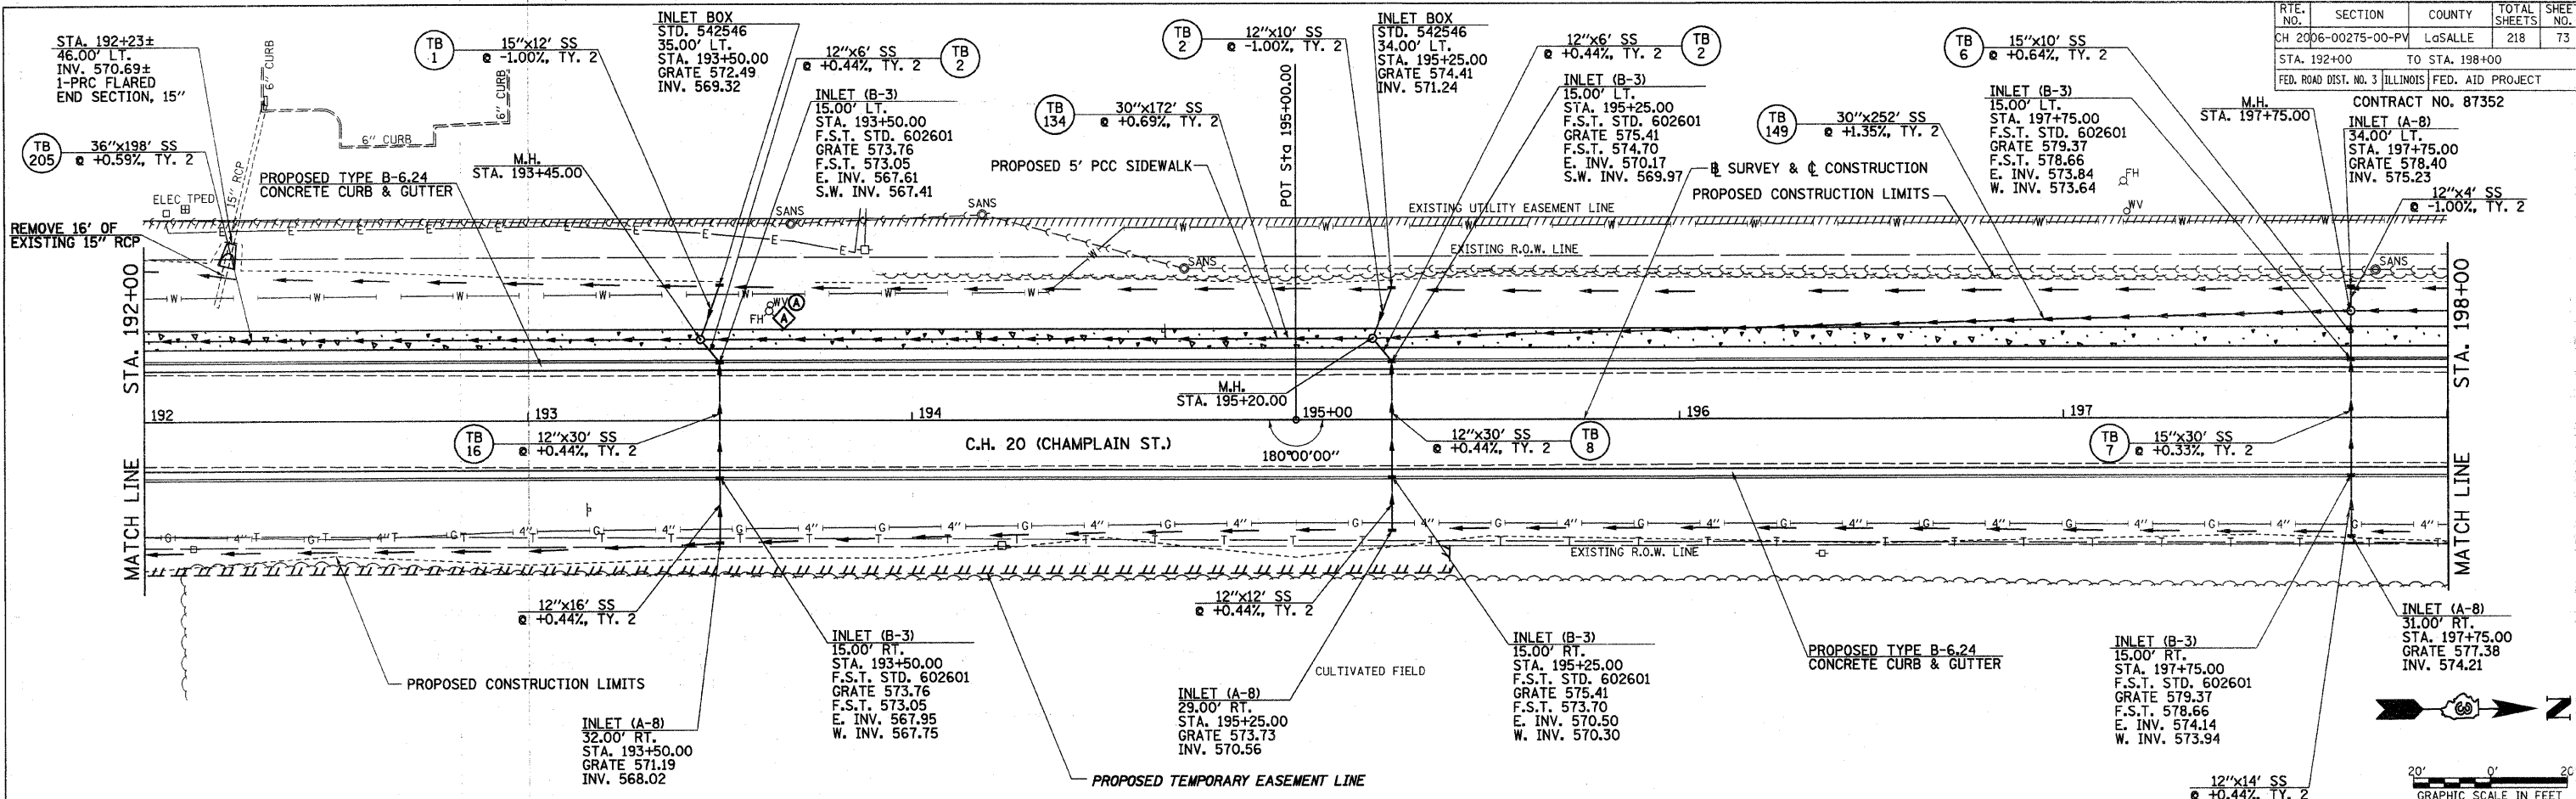

2389D017 C.H. 20 (CHAMPLAIN ST.), DRAINAGE PLAN & PROFILE, STA. 192+00 TO STA. 198+00