


SW 1/4 SEC. 22, T.19N., R.9E., 3rd P.M.
CHAMPAIGN COUNTY, ILLINOIS

CONTRACT NO. 91391

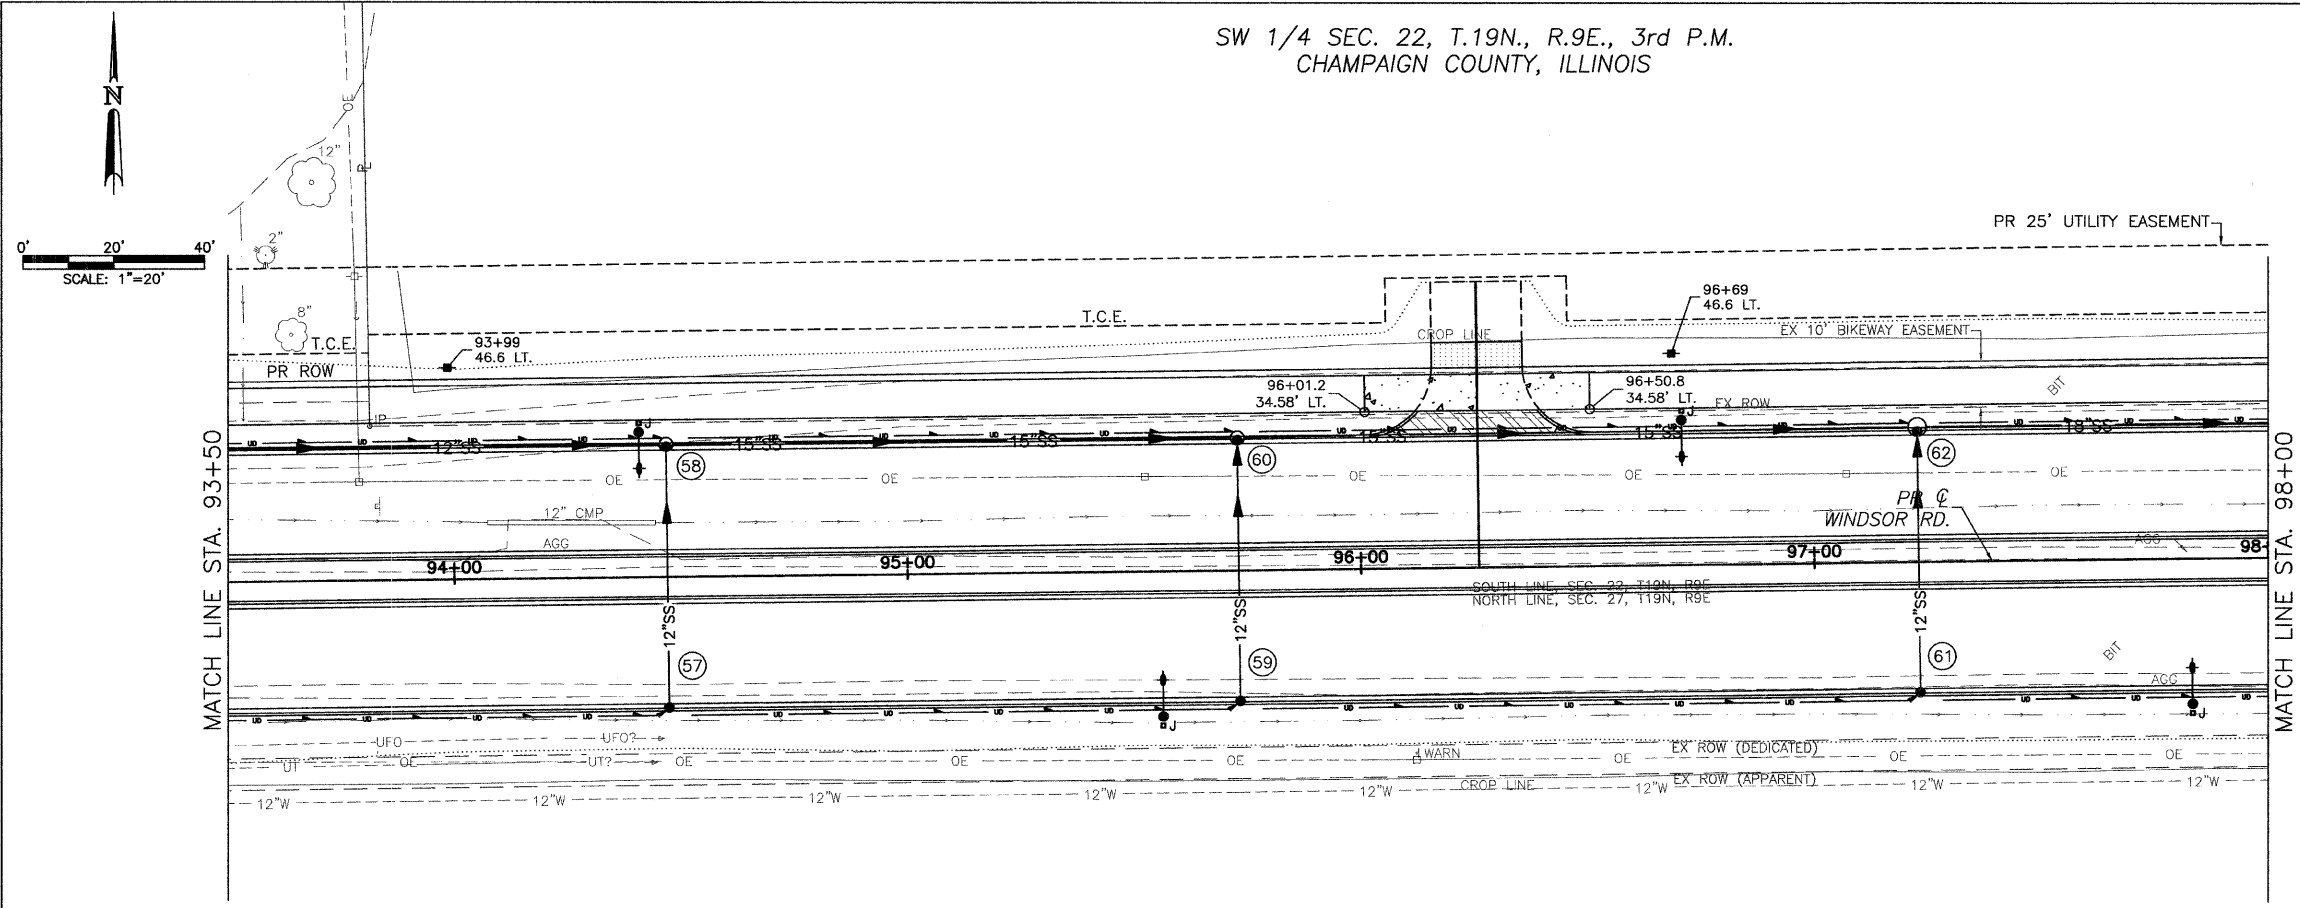

CITY OF URBANA
PUBLIC WORKS
ENGINEERING DIVISION



EX UNDERGROUND TELEPHONE NOT SHOWN
FROM STA. 94+00 TO STA. 114+00

NW 1/4 SEC. 27, T.19N., R.9E., 3rd P.M.
CHAMPAIGN COUNTY, ILLINOIS

STR. NO.	STRUCTURE TYPE	OFF-SET SIDE	STA. OF C/L STR.	OFFSET OF C/L STR.	EX. T/O FRAME/GRATE ELEV.	PR. T/O FRAME/GRATE ELEV.	PR. T/O FLAT SLAB TOP ELEV.	INVERT IN ELEV.	U.S. STR. NO.	INVERT OUT ELEV.	D.S. STR. NO.
57	INLETS TA T11V F&G	RT	94+47.00	28.79	----	726.14	----	----	--	722.14	58
58	RD INLET TY B T11V F&G	LT	94+47.00	29.29	----	726.14	724.64	721.86	56	721.66	60
								721.86	57		
59	INLETS TA T11V F&G	RT	95+73.00	28.79	----	723.11	----	----	--	719.11	60
60	RD INLET TY B T11V F&G	LT	95+73.00	29.29	----	723.11	721.61	718.83	58	718.63	62
								718.83	59		
61	INLETS TA T11V F&G	RT	97+23.00	28.79	----	720.25	----	----	--	716.25	62
62	RD MAN 4 DIA T11V F&G	LT	97+23.00	29.79	----	723.11	721.61	715.77	60	715.57	64
								715.97	61		

LOCATION STR. - STR. OR STA., O.S.	STORM SEW CL A 1 12 (FOOT)	STORM SEW CL A 1 15 (FOOT)	STORM SEW CL A 1 18 (FOOT)	STORM SEW CL A 2 15 (FOOT)	GRADE %	TRENCH BACKFILL (CU YD)
57 - 58	56				0.50	8.4
58 - 60		123			2.30	20.9
59 - 60	56				0.50	8.4
60 - 62				147	2.09	26.6
61 - 62	56				0.50	8.4
62 - 64			96		1.23	17.6

DATED: 1/09
DESIGNED BY: CES
DRAWN BY: AJS
CHECKED BY: GLJ
CITY SECTION
00-00367-00-PV

WINDSOR ROAD IMPROVEMENTS
DRAINAGE PLANS
STA 93+50 TO STA 98+00

SHEET NO.
59
OF
145

MAR 20 2009 11:25AM DRAINAGE_STA93+50-98+00.DWG