

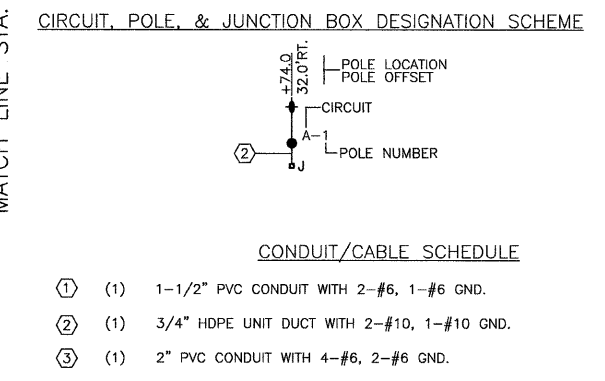


JAN 09 2009 10:44AM ROWYLIGHT_STA80+00-89+00.DWG


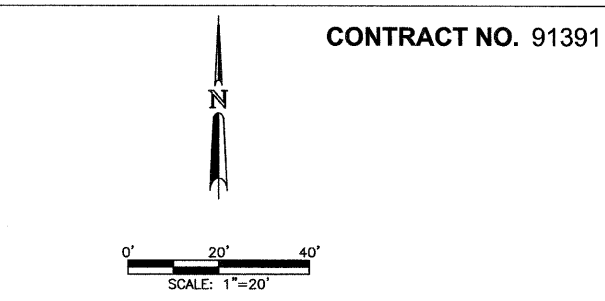


CONTRACT NO. 91391

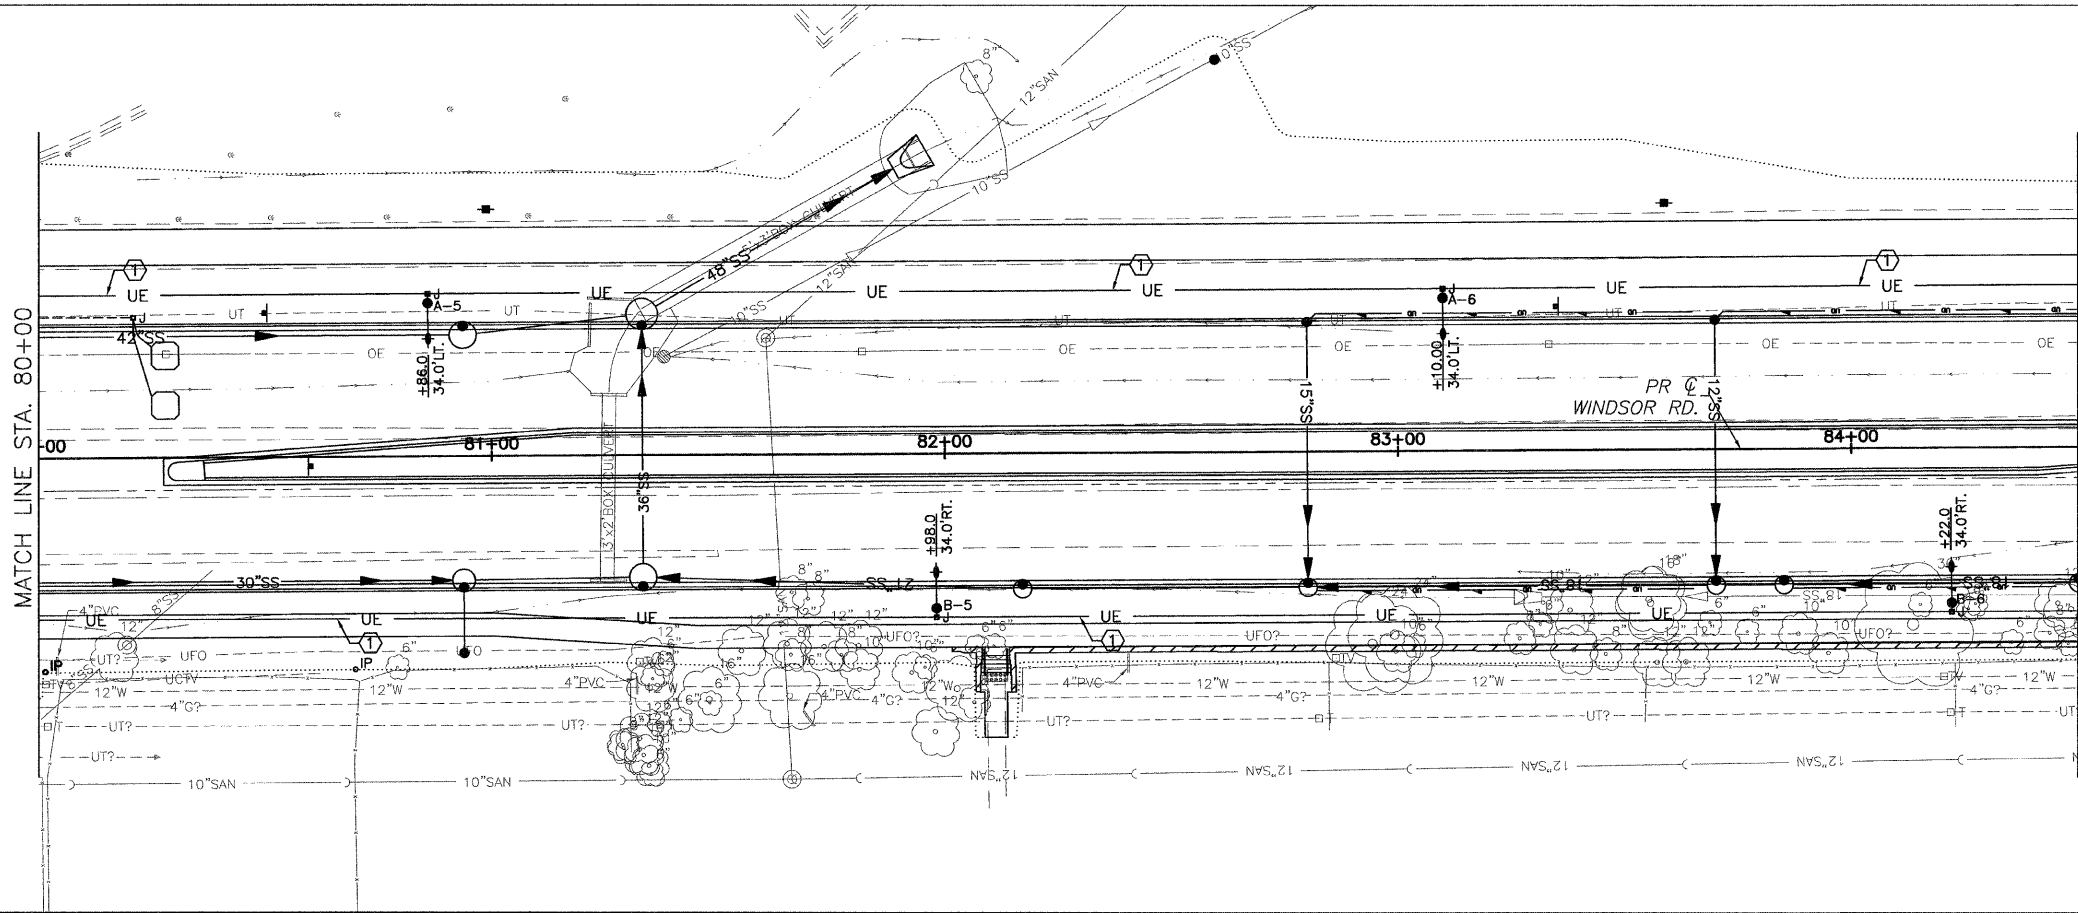

CITY OF URBANA
PUBLIC WORKS
ENGINEERING DIVISION

DATED: 1/09
DESIGNED BY: JLS
DRAWN BY: AJS
CHECKED BY: GLJ
CITY SECTION
00-00361-00-PV

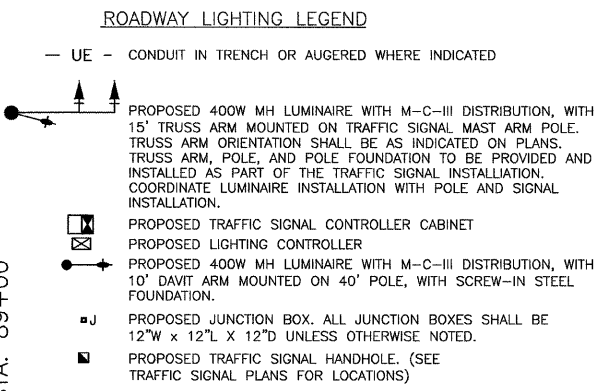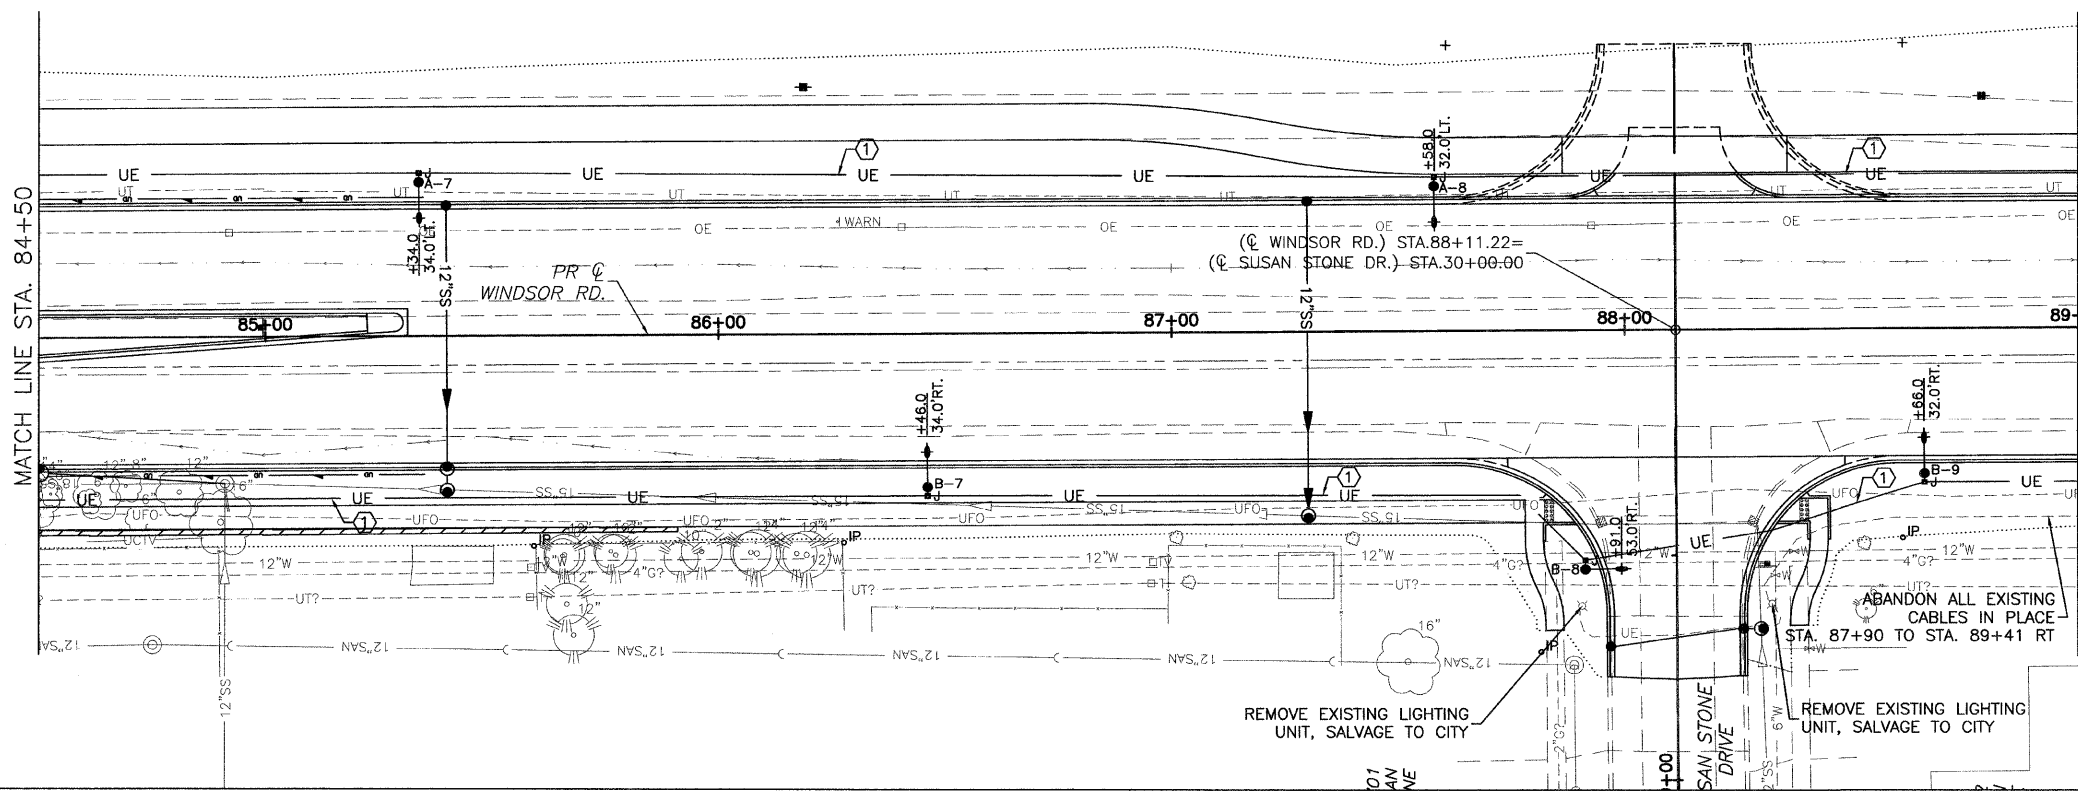

WINDSOR ROAD IMPROVEMENTS
ROADWAY LIGHTING PLANS
STA 80+00 TO STA 89+00

SHEET NO.
83
OF
145