


LEGEND
 (R) - STRUCTURE TO BE REMOVED

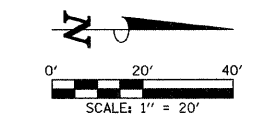


SEE THE TRAFFIC SIGNAL PLANS FOR TRAFFIC SIGNAL REMOVAL ITEMS.
 SEE THE ROADWAY LIGHTING PLANS FOR ROADWAY LIGHTING REMOVAL ITEMS.
 SEE DRAINAGE PLANS FOR ADDITIONAL INFORMATION.

THE LIMITS OF SIDEWALK REMOVAL AND BRICK PAVER REMOVAL ARE NOT SHOWN FOR THE REMOVAL AND/OR INSTALLATION OF LIGHT POLES, JUNCTION BOXES, OR PARKING METERS. QUANTITIES FOR THIS WORK ARE INCLUDED ON THE PLANS.

THE STRUCTURE INFORMATION SHOWN IN ITALICS IS ALSO SHOWN ON THE DRAINAGE PLANS. THE SCHEDULE OF QUANTITIES FOR THESE ITEMS IS SHOWN ON THE REMOVAL PLANS.

SEE SHEET 11 FOR REMOVAL NOTES

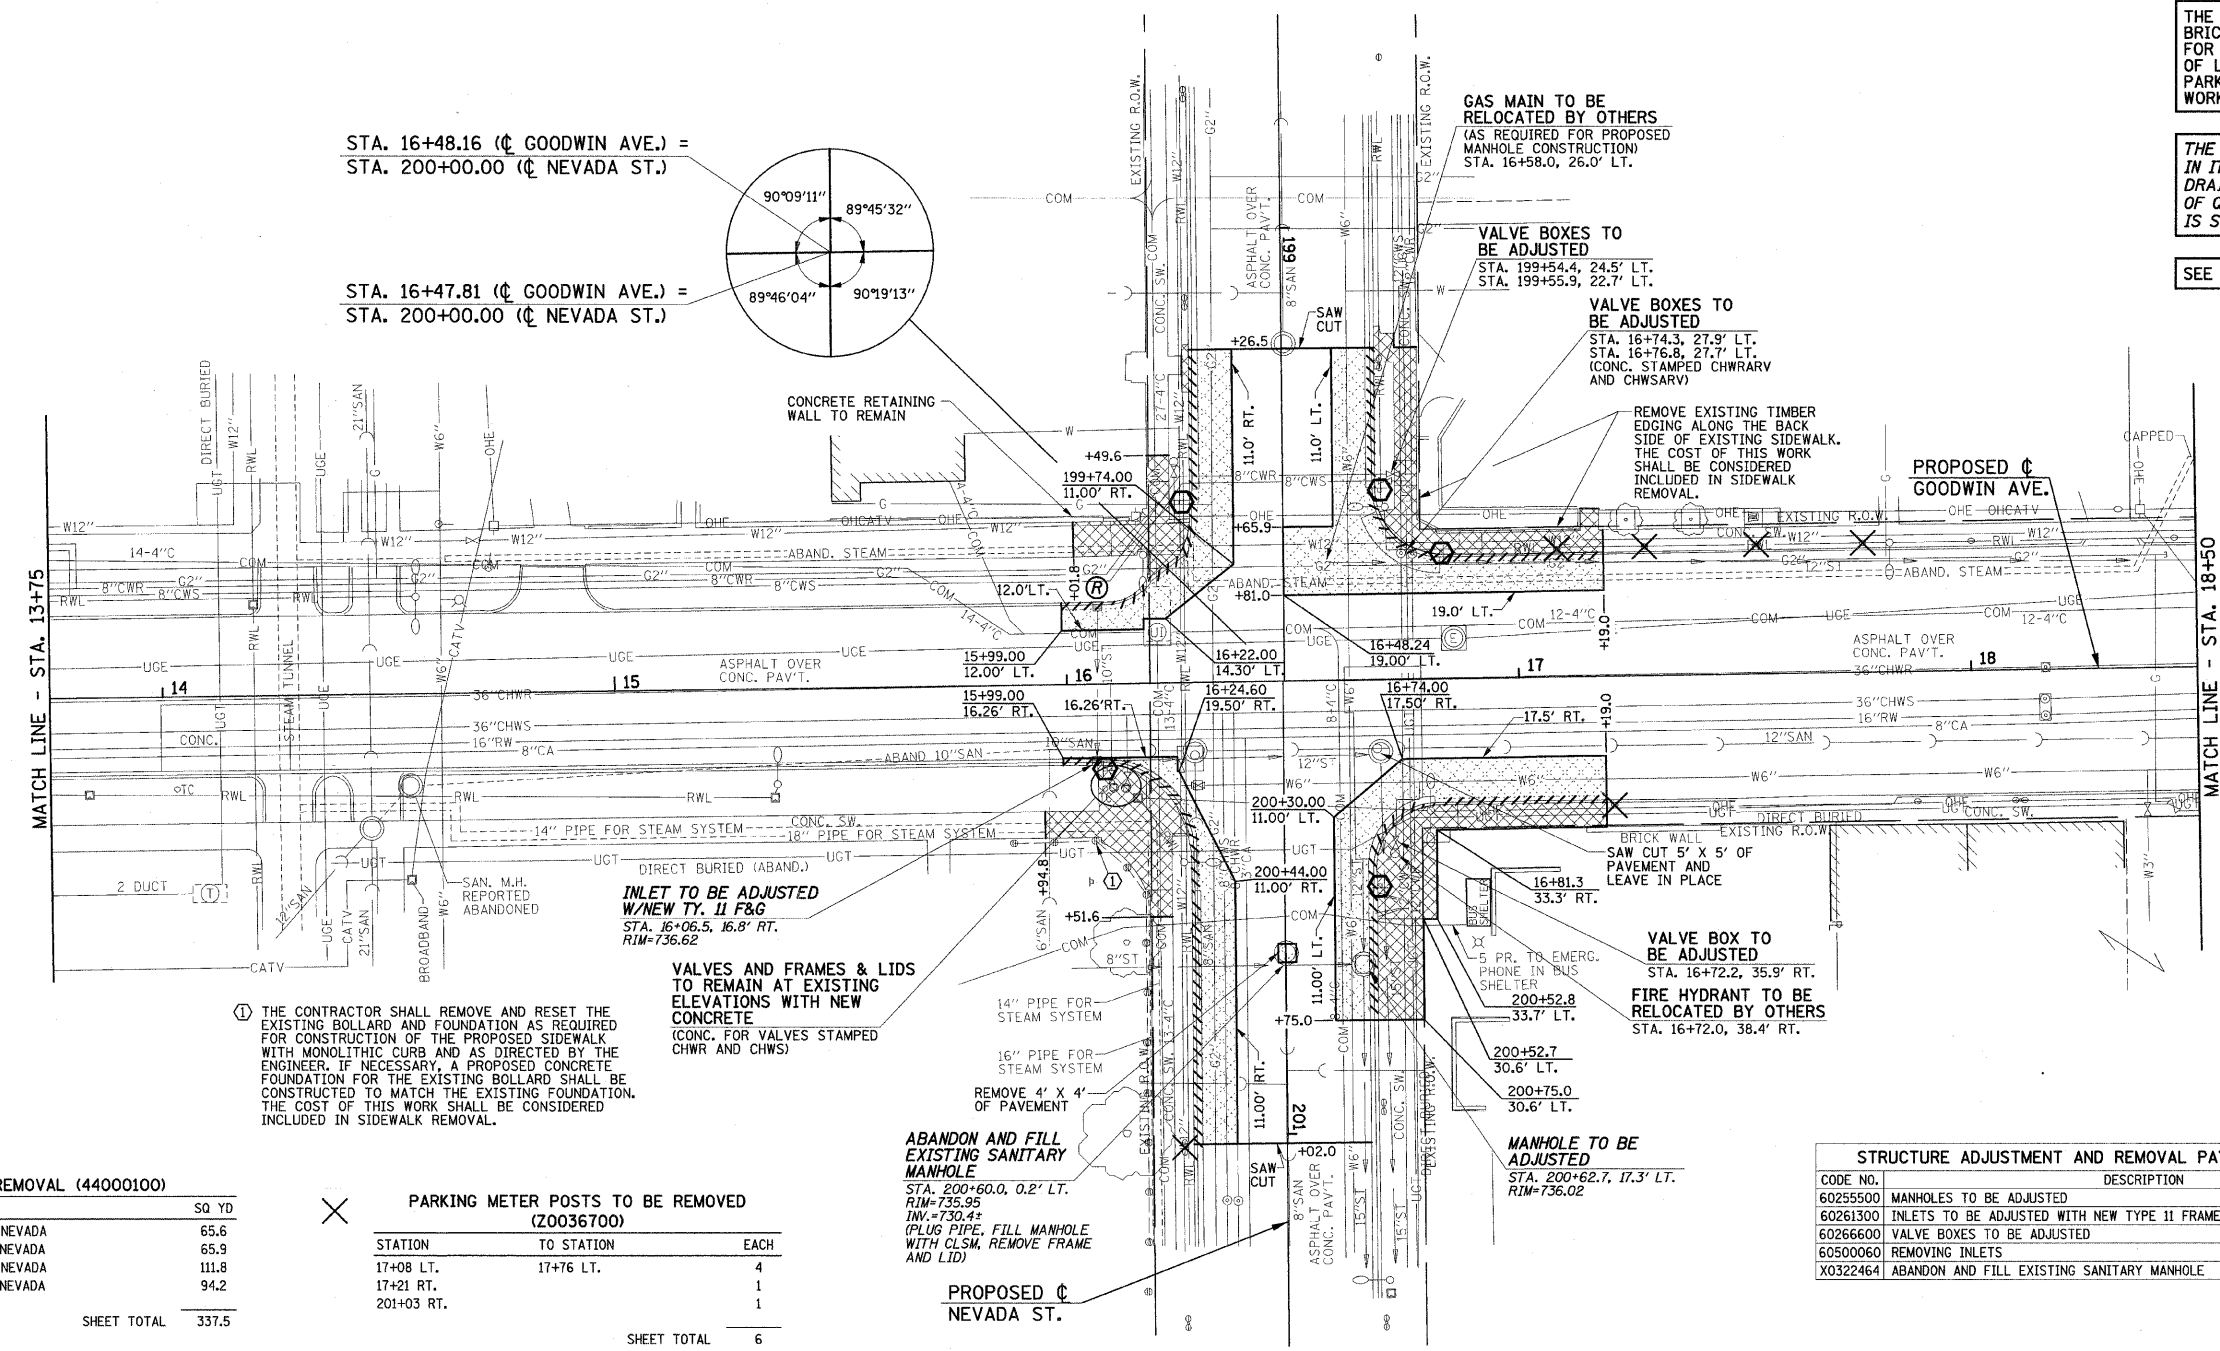

MATCH LINE - STA. 13+75

MATCH LINE - STA. 18+50

① THE CONTRACTOR SHALL REMOVE AND RESET THE EXISTING BOLLARD AND FOUNDATION AS REQUIRED FOR CONSTRUCTION OF THE PROPOSED SIDEWALK WITH MONOLITHIC CURB AND AS DIRECTED BY THE ENGINEER. IF NECESSARY, A PROPOSED CONCRETE FOUNDATION FOR THE EXISTING BOLLARD SHALL BE CONSTRUCTED TO MATCH THE EXISTING FOUNDATION. THE COST OF THIS WORK SHALL BE CONSIDERED INCLUDED IN SIDEWALK REMOVAL.

INLET TO BE ADJUSTED W/NEW TY. II F&G
 STA. 16+06.5, 16.8' RT.
 RIM=736.62

VALVES AND FRAMES & LIDS TO REMAIN AT EXISTING ELEVATIONS WITH NEW CONCRETE
 (CONC. FOR VALVES STAMPED CHWR AND CHWS)

PAVEMENT REMOVAL (44000100)

| LOCATION | SQ YD |
|------------------------------|--------------|
| SW CORNER GOODWIN AND NEVADA | 65.6 |
| SE CORNER GOODWIN AND NEVADA | 65.9 |
| NW CORNER GOODWIN AND NEVADA | 111.8 |
| NE CORNER GOODWIN AND NEVADA | 94.2 |
| SHEET TOTAL | 337.5 |

PARKING METER POSTS TO BE REMOVED (Z0036700)

| STATION | TO STATION | EACH |
|--------------------|------------|----------|
| 17+08 LT. | 17+76 LT. | 4 |
| 17+21 RT. | | 1 |
| 201+03 RT. | | 1 |
| SHEET TOTAL | | 6 |

SIDEWALK REMOVAL (44000600)

| LOCATION | SQ FT |
|------------------------------|---------------|
| SW CORNER GOODWIN AND NEVADA | 301.9 |
| SE CORNER GOODWIN AND NEVADA | 460.6 |
| NW CORNER GOODWIN AND NEVADA | 493.4 |
| NE CORNER GOODWIN AND NEVADA | 725.8 |
| ROADWAY LIGHTING | 185.0 |
| PARKING METER POSTS | 40.0 |
| SHEET TOTAL | 2206.7 |

COMBINATION CURB AND GUTTER REMOVAL (44000500)

| LOCATION | FOOT |
|------------------------------|--------------|
| SW CORNER GOODWIN AND NEVADA | 76.5 |
| SE CORNER GOODWIN AND NEVADA | 105.5 |
| NW CORNER GOODWIN AND NEVADA | 90.8 |
| NE CORNER GOODWIN AND NEVADA | 93.1 |
| SHEET TOTAL | 365.9 |

REMOVING AND RESETTING STREET SIGNS (Z0051500)

| LOCATION | EACH |
|--------------------|----------|
| STA. 16+08 RT. | 1 |
| STA. 16+83 LT. | 1 |
| STA. 199+58 LT. | 1 |
| STA. 199+60 RT. | 1 |
| STA. 200+45 LT. | 1 |
| SHEET TOTAL | 5 |

STRUCTURE ADJUSTMENT AND REMOVAL PAY ITEMS - 13+75 TO 18+50

| CODE NO. | DESCRIPTION | UNIT | QUAN. |
|----------|--|------|-------|
| 60255500 | MANHOLES TO BE ADJUSTED | EACH | 1 |
| 60261300 | INLETS TO BE ADJUSTED WITH NEW TYPE II FRAME AND GRATE | EACH | 1 |
| 60266600 | VALVE BOXES TO BE ADJUSTED | EACH | 5 |
| 60500600 | REMOVING INLETS | EACH | 1 |
| X0322464 | ABANDON AND FILL EXISTING SANITARY MANHOLE | EACH | 1 |

REVISED 4-6-09

FILE NAME = p:\u0070052\plans\sheet\10-Removal.dgn
 PLOT DATE = 2/27/2009 3:21:38 PM

DESIGNED - JAJ
 DRAWN - DLM
 CHECKED - RLH
 DATE - 01-2009

REVISED -
 REVISED -
 REVISED -
 REVISED -

STATE OF ILLINOIS
 DEPARTMENT OF TRANSPORTATION

REMOVALS/RELOCATIONS PLAN
 SCALE: 1"=20' SHEET NO. 12 OF 75 SHEETS STA. 13+75 TO STA. 18+50

| F.A.U. RTE. | SECTION | COUNTY | TOTAL SHEETS | SHEET NO. |
|-------------|----------------|-----------|--------------|-----------|
| 7175 | 07-00456-00-RS | CHAMPAIGN | 75 | 12 |

GOODWIN AVENUE CONTRACT NO. 91392
 FED. ROAD DIST. NO. ILLINOIS FED. AID PROJECT