

SEE THE TRAFFIC SIGNAL PLANS FOR TRAFFIC SIGNAL REMOVAL ITEMS.
SEE THE ROADWAY LIGHTING PLANS FOR ROADWAY LIGHTING REMOVAL ITEMS.
SEE DRAINAGE PLANS FOR ADDITIONAL INFORMATION.

SEE SHEET 11 FOR REMOVAL NOTES

THE LIMITS OF SIDEWALK REMOVAL AND BRICK PAVER REMOVAL ARE NOT SHOWN FOR THE REMOVAL AND/OR INSTALLATION OF LIGHT POLES, JUNCTION BOXES, OR PARKING METERS. QUANTITIES FOR THIS WORK ARE INCLUDED ON THE PLANS.

THE STRUCTURE INFORMATION SHOWN IN ITALICS IS ALSO SHOWN ON THE DRAINAGE PLANS. THE SCHEDULE OF QUANTITIES FOR THESE ITEMS IS SHOWN ON THE REMOVAL PLANS.

LEGEND

- (R) - STRUCTURE TO BE REMOVED
- PR - TREE PRUNING (BY OTHERS)

STA. 27+69.78 (C GOODWIN AVE.) =
STA. 400+03.10 (C ILLINOIS ST.)

STA. 27+69.78 (C GOODWIN AVE.) =
STA. 400+00.00 (C ILLINOIS ST.)

REMOVING AND RESETTING STREET SIGNS (Z0051500)

LOCATION	EACH
STA. 27+42 RT.	1
STA. 28+18 LT.	1
STA. 400+48 RT.	1
SHEET TOTAL	3

PARKING METER POSTS TO BE REMOVED (Z0036700)

STATION	TO STATION	EACH
29+68 LT.	30+09 LT.	2
26+60 RT.		1
400+88 RT.		1
SHEET TOTAL		4

PAVEMENT REMOVAL (44000100)

STATION	TO STATION	SQ YD
26+46 LT.	28+42 LT.	222.2
SE CORNER GOODWIN AND ILLINOIS		388.0
ROADWAY LIGHTING CONTROLLER		8.5
SHEET TOTAL		618.7

SIDEWALK REMOVAL (44000600)

STATION	TO STATION	SQ FT
26+46 LT.	28+42 LT.	792.3
SE CORNER GOODWIN AND ILLINOIS		1261.9
NE CORNER GOODWIN AND ILLINOIS		989.2
ROADWAY LIGHTING		425.0
PARKING METER POSTS		20.0
SHEET TOTAL		3488.4

REMOVE AND REINSTALL BRICK PAVER (XX003313)


LOCATION	SQ FT
PARKING METER POSTS	4.0
SHEET TOTAL	4.0

COMBINATION CURB AND GUTTER REMOVAL (44000500)

STATION	TO STATION	FOOT
26+46 LT.	28+42 LT.	196.0
SE CORNER GOODWIN AND ILLINOIS		106.4
NE CORNER GOODWIN AND ILLINOIS		117.4
SHEET TOTAL		419.8

CURB REMOVAL (44000300)

STATION	TO STATION	FOOT
28+09.6 LT.	28+43.4 LT.	23.5
SHEET TOTAL		23.5

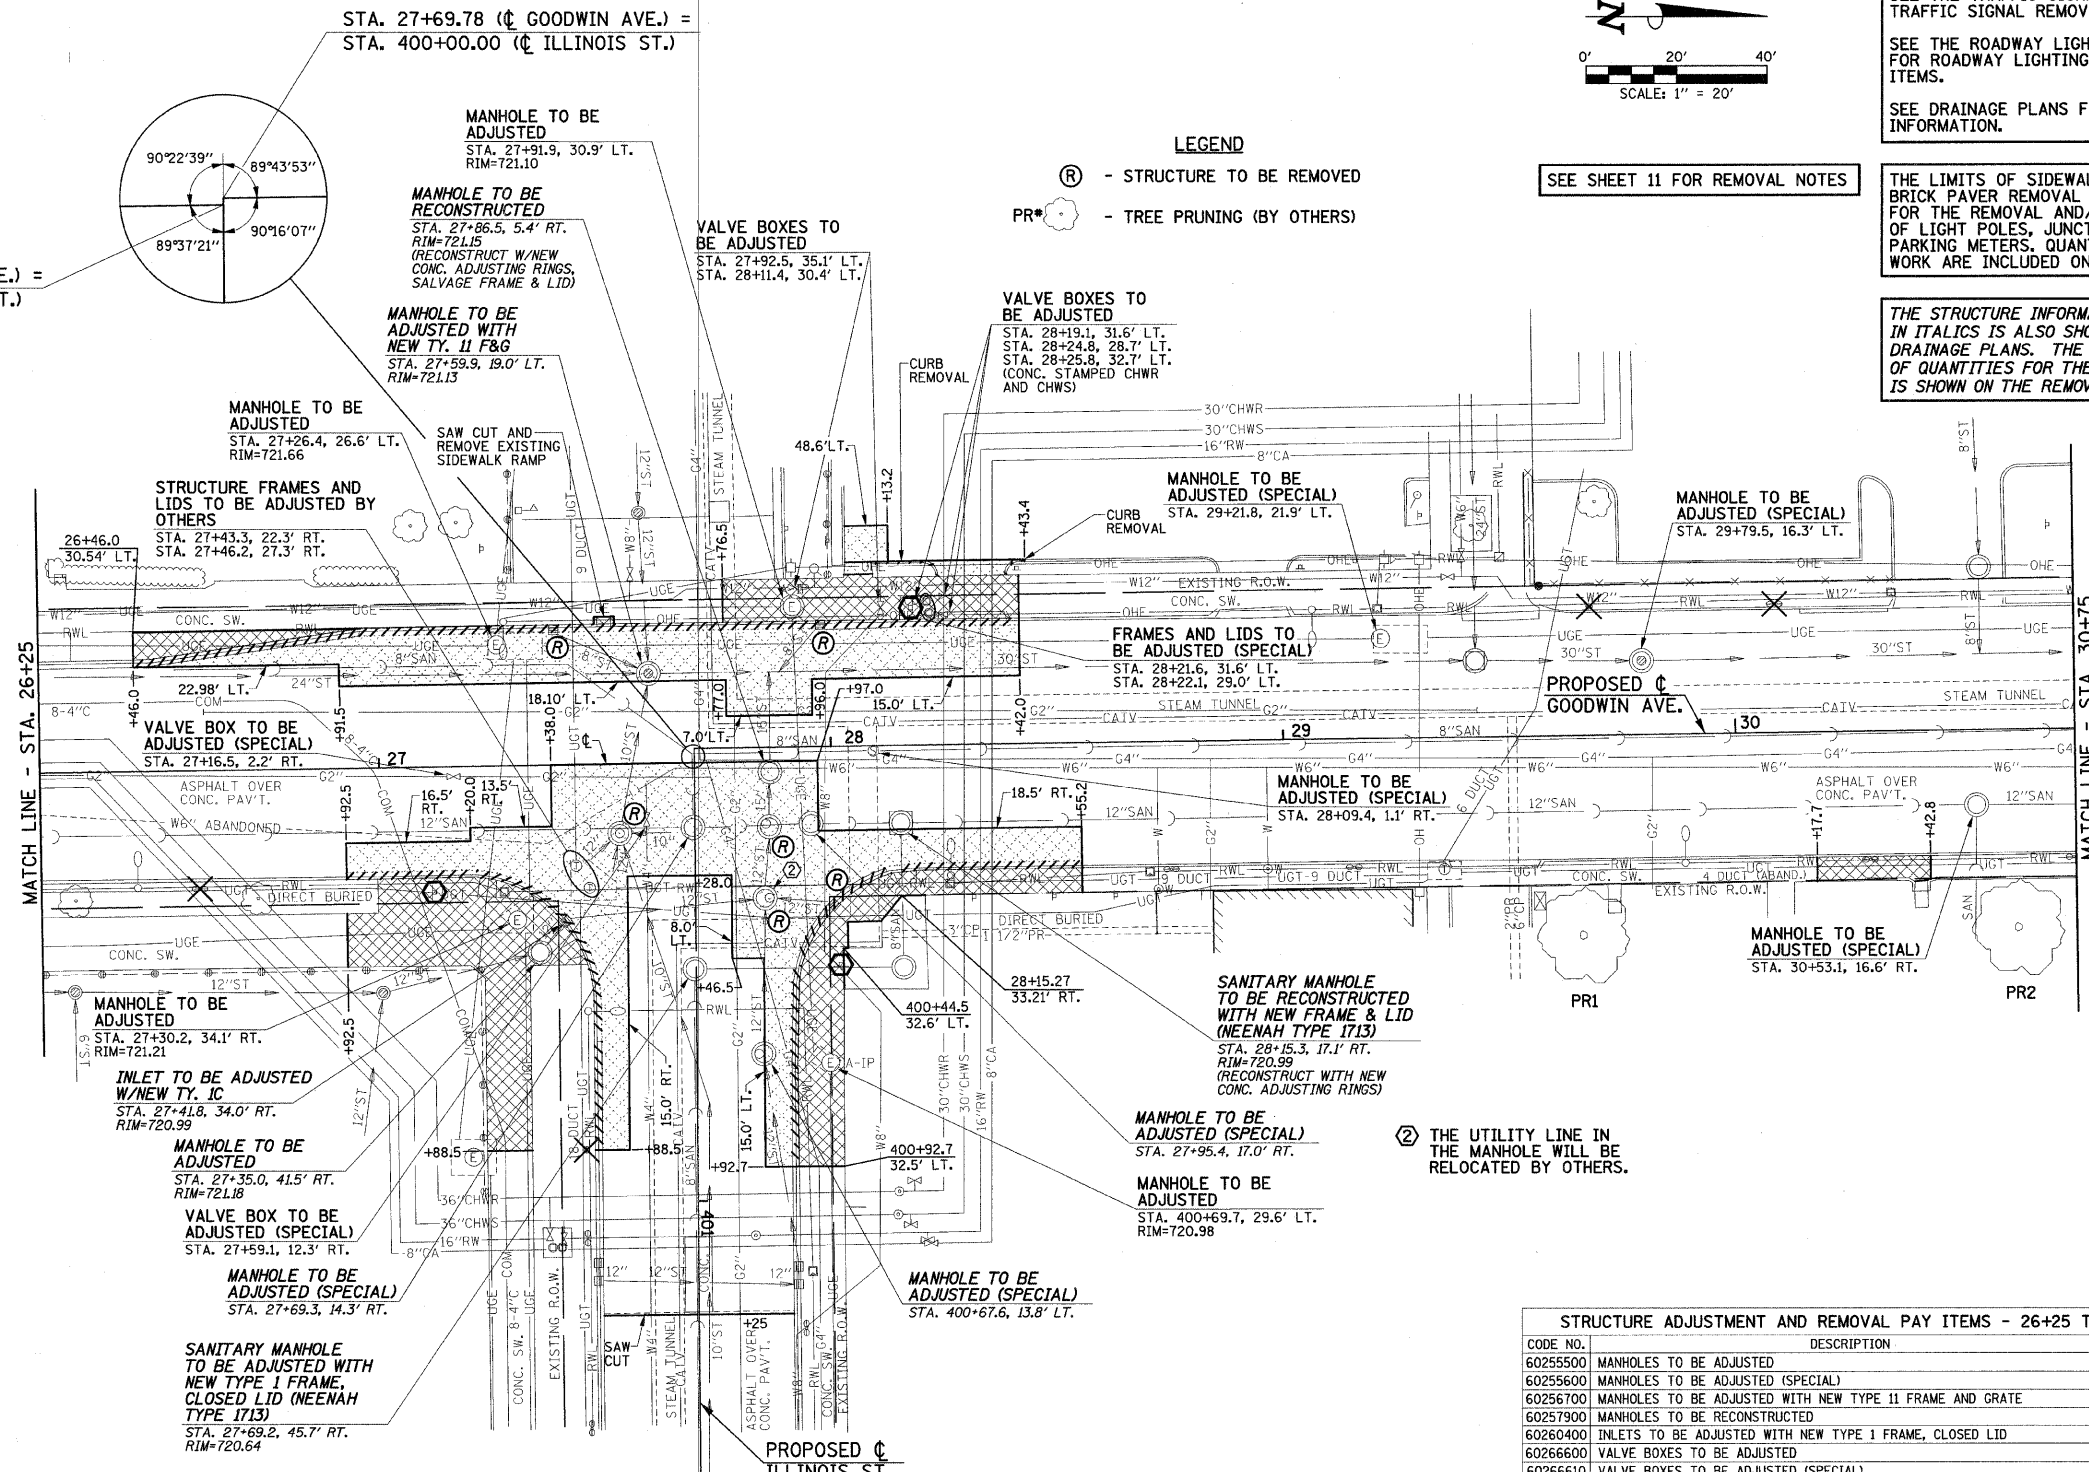

THE UTILITY LINE IN THE MANHOLE WILL BE RELOCATED BY OTHERS.

STRUCTURE ADJUSTMENT AND REMOVAL PAY ITEMS - 26+25 TO 30+75

CODE NO.	DESCRIPTION	UNIT	QUAN.
60255500	MANHOLES TO BE ADJUSTED	EACH	5
60255600	MANHOLES TO BE ADJUSTED (SPECIAL)	EACH	7
60256700	MANHOLES TO BE ADJUSTED WITH NEW TYPE 11 FRAME AND GRATE	EACH	1
60257900	MANHOLES TO BE RECONSTRUCTED	EACH	1
60260400	INLETS TO BE ADJUSTED WITH NEW TYPE 1 FRAME, CLOSED LID	EACH	1
60266600	VALVE BOXES TO BE ADJUSTED	EACH	5
60266610	VALVE BOXES TO BE ADJUSTED (SPECIAL)	EACH	2
60300310	FRAMES AND LIDS TO BE ADJUSTED (SPECIAL)	EACH	2
60500040	REMOVING MANHOLES	EACH	3
60500060	REMOVING INLETS	EACH	3
X0321558	SANITARY MANHOLES TO BE ADJUSTED WITH NEW TYPE 1 FRAME, CLOSED LID	EACH	1
XX002895	SANITARY MANHOLES TO BE RECONSTRUCTED WITH NEW FRAME AND LID	EACH	1

REVISED A-6-09

FILE NAME = p:\u0070052\plans\sheet\10-Removal.dgn
PLOT DATE = 2/27/2009 3:21:41 PM

DESIGNED - JAJ
DRAWN - DLM
CHECKED - RLH
DATE - 01-2009

REVISED -
REVISED -
REVISED -
REVISED -

STATE OF ILLINOIS
DEPARTMENT OF TRANSPORTATION

REMOVALS/RELOCATIONS PLAN

SCALE: 1"=20' SHEET NO. 15 OF 75 SHEETS STA. 26+25 TO STA. 30+75

F.A.U. R.T.E.	SECTION	COUNTY	TOTAL SHEETS	SHEET NO.
7175	07-00456-00-RS	CHAMPAIGN	75	15

GOODWIN AVENUE CONTRACT NO. 91392
FED. ROAD DIST. NO. ILLINOIS FED. AID PROJECT