 



STORM AND SANITARY SEWER PIPE SCHEDULE - MIDBLOCK			
CODE NO.	DESCRIPTION	UNIT	QUAN.
54248515	CONCRETE COLLAR	EACH	4
550A0050	STORM SEWERS, CLASS A, TYPE 1 12"	FOOT	62
550A0380	STORM SEWERS, CLASS A, TYPE 2 18"	FOOT	8
59300100	CONTROLLED LOW-STRENGTH MATERIAL	CU YD	32.7

STORM AND SANITARY SEWER STRUCTURE SCHEDULE - MIDBLOCK			
CODE NO.	DESCRIPTION	UNIT	QUAN.
60225110	RESTRICTED DEPTH MANHOLES, 4'-DIAMETER, TYPE 11 FRAME AND GRATE	EACH	2
60236800	INLETS, TYPE A, TYPE 11 FRAME AND GRATE	EACH	1

- STRUCTURE LEGEND**
- TA - TYPE A INLET
 - TB - TYPE B INLET
 - TA (4' DIA.) - TYPE A MANHOLE (DIA. SPECIFIED)
 - R.D. - RESTRICTED DEPTH
 - ⊕ RIM - CENTER OF 2' OPENING
 - RIM - TOP OF FRAME ELEVATION
 - T/F.S.T. - TOP OF FLAT SLAB TOP
 - 1C - TYPE 1 FRAME AND CLOSED LID
 - 8 - TYPE 8 GRATE
 - 11 - TYPE 11 FRAME AND GRATE



THE STRUCTURE INFORMATION SHOWN IN ITALICS IS ALSO SHOWN ON THE REMOVAL PLANS. THE SCHEDULE OF QUANTITIES FOR THESE ITEMS IS SHOWN ON THE REMOVAL PLANS.

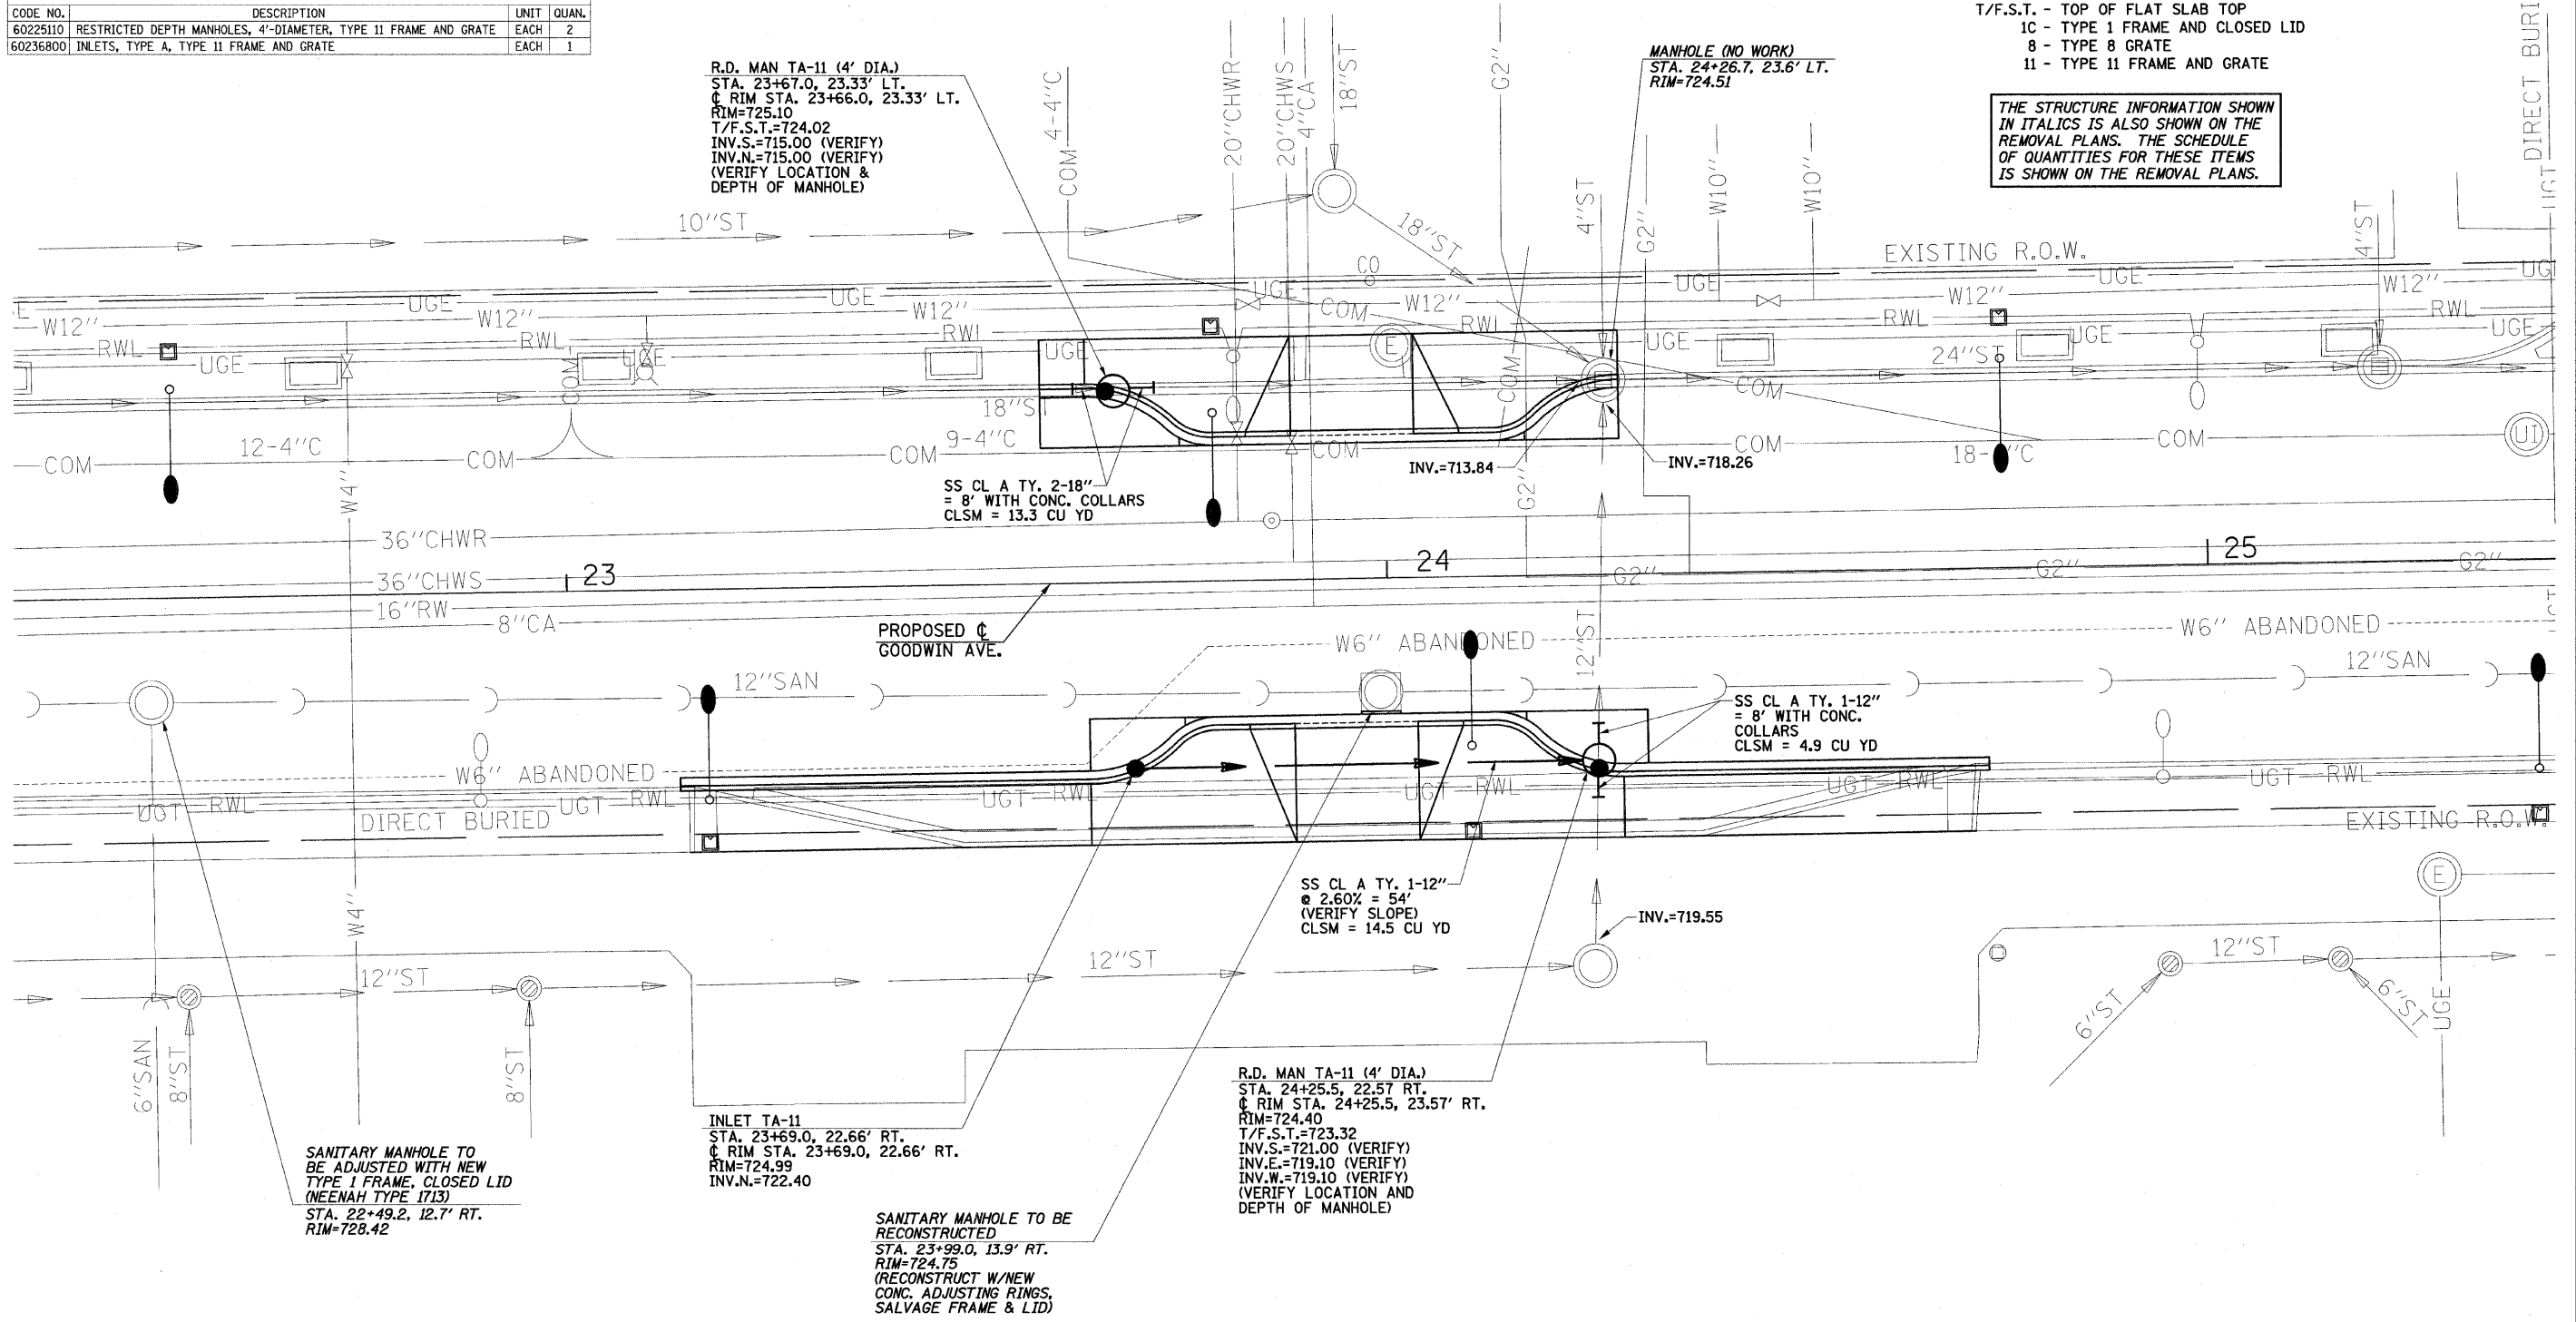

FILE NAME = p:\u0070052\plans\sheet\27-Drainage.dgn
 PLOT DATE = 2/27/2009 3:21:57 PM

DESIGNED - RLH	REVISED -
DRAWN - JRM	REVISED -
CHECKED - JAJ	REVISED -
DATE - 01-2009	REVISED -

STATE OF ILLINOIS
 DEPARTMENT OF TRANSPORTATION

DRAINAGE PLAN
 SCALE: 1"=10' SHEET NO. 29 OF 75 SHEETS STA. TO STA.

F.A.U. RTE.	SECTION	COUNTY	TOTAL SHEETS	SHEET NO.
7175	07-00456-00-RS	CHAMPAIGN	75	29

GOODWIN AVENUE CONTRACT NO. 91392
 FED. ROAD DIST. NO. ILLINOIS FED. AID PROJECT

REVISED 4-6-09