

INDEX OF SHEETS

SHEET NO.	DESCRIPTION
1	TITLE SHEET
2	GENERAL NOTES
3	HIGHWAY STANDARDS AND LEGEND
4 - 6	SUMMARY OF QUANTITIES
7	TYPICAL SECTIONS
8 - 9	HORIZONTAL ALIGNMENT LAYOUT AND CONTROL
10	HOT-MIX ASPHALT SURFACE REMOVAL PLANS
11 - 18	REMOVALS/RELOCATIONS PLANS
19 - 26	SITE IMPROVEMENTS PLANS
27 - 34	DRAINAGE PLANS
35	TRAFFIC CONTROL PLANS
36	STORM WATER POLLUTION PREVENTION PLANS
37 - 44	INTERSECTION DETAILS
45 - 52	PAVEMENT MARKING AND SIGNING PLANS
53 - 63	TRAFFIC SIGNAL PLANS
64 - 71	ROADWAY LIGHTING PLANS
72 - 75	MISCELLANEOUS DETAILS

STATE OF ILLINOIS
DEPARTMENT OF TRANSPORTATION
DIVISION OF HIGHWAYS


**PLANS FOR PROPOSED
STREET IMPROVEMENTS**

PLAN 1 INCH = 20 FEET
PROFILE HORIZ. 1 INCH = 20 FEET
PROFILE VERT. 1 INCH = 5 FEET
CROSS SECTIONS HORIZ. 1 INCH = 10 FEET
CROSS SECTIONS VERT. 1 INCH = 5 FEET

CITY OF URBANA
CHAMPAIGN COUNTY, ILLINOIS
CITY SECTION NO. 07-00456-00-RS
PROJECT NO. HSIP-5181(41)
JOB NO. C-95-317-08

GOODWIN AVENUE - F.A.U. ROUTE 7175
PEDESTRIAN AND BICYCLE SAFETY IMPROVEMENTS
GREGORY DRIVE TO SPRINGFIELD AVENUE


ILLINOIS HIGHWAY STANDARD DRAWINGS
(SEE SHEET NO. 3)

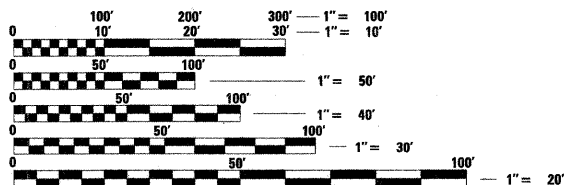

FULL SIZE PLANS HAVE BEEN PREPARED USING STANDARD ENGINEERING SCALES. REDUCED SIZED PLANS WILL NOT CONFORM TO STANDARD SCALES. IN MAKING MEASUREMENTS ON REDUCED PLANS, THE ABOVE SCALES MAY BE USED.

J.U.L.I.E.
JOINT UTILITY LOCATION INFORMATION FOR EXCAVATION
1-800-892-0123

CONTRACT NO. 91392

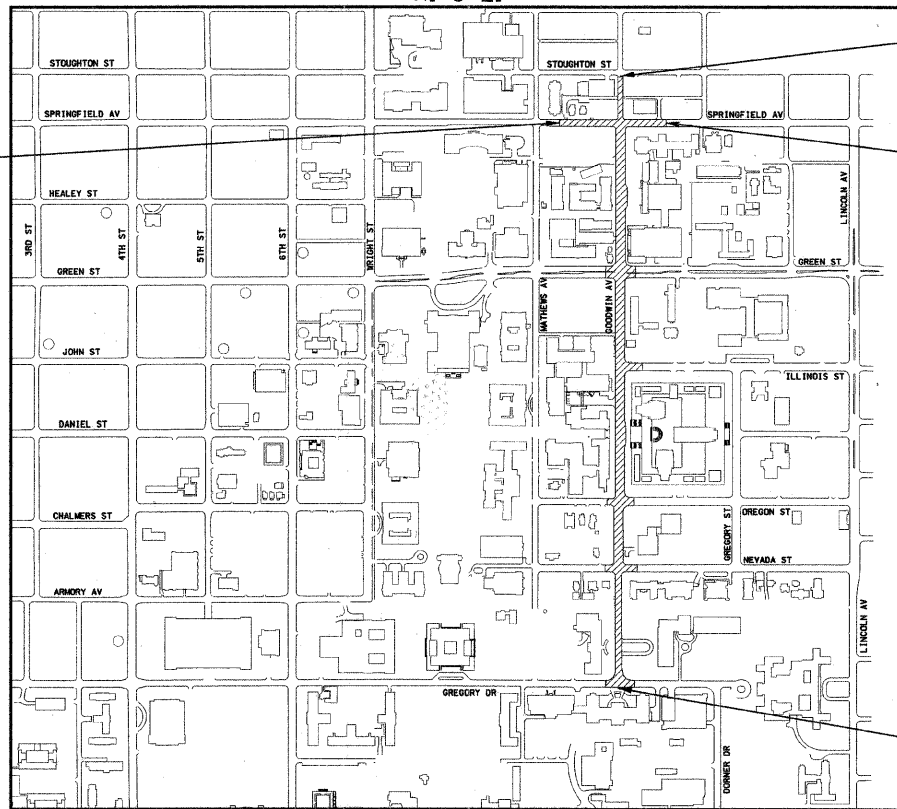

LOCATION MAP
SCALE: 1" = 500'

TOTAL LENGTH OF GOODWIN AVENUE IMPROVEMENT = 3,383.00 FEET = 0.64 MILES
TOTAL LENGTH OF SPRINGFIELD AVENUE IMPROVEMENT = 591.00 FEET = 0.11 MILES
TOTAL LENGTH OF IMPROVEMENTS = 3,974.00 FEET = 0.75 MILES

END IMPROVEMENTS
GOODWIN AVENUE
STA. 43+83.00

END IMPROVEMENTS
SPRINGFIELD AVENUE
STA. 602+56.00

BEGIN IMPROVEMENTS
GOODWIN AVENUE
STA. 10+00.00




LICENSE EXPIRES
11/30/09

FUNCTIONAL CLASSIFICATION = COLLECTOR

ADT = 5400

PROFESSIONAL ENGINEER
CLARK DIETZ, INC.
FOR SHEETS 1-63 AND 72-75

DATE: 01/09/2009
LICENSE EXPIRES 11-30-09

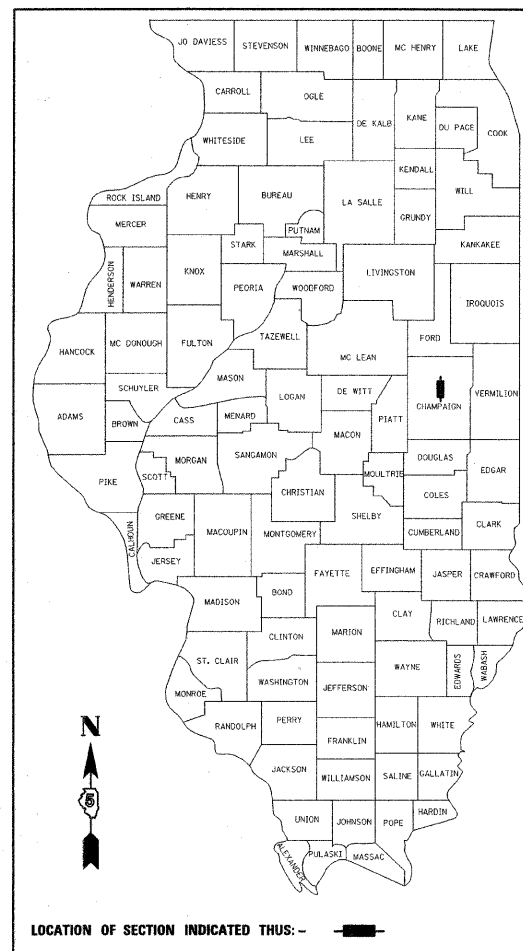

CITY OF URBANA
APPROVED JAN. 13 20 09
William R. Gray
DIRECTOR OF PUBLIC WORKS

STATE OF ILLINOIS
DEPARTMENT OF TRANSPORTATION
DIVISION OF HIGHWAYS
Released for Bid Based on Limited Review FEB 3 20 09
Paul E. Love
REGION 3 ENGINEER
PASSED 2/2 20 09
Daniel A. Sal
DISTRICT ENGINEER OF LOCAL ROADS AND STREETS

**PRINTED BY THE AUTHORITY
OF THE STATE OF ILLINOIS**



Clark Dietz
ENGINEERS
1817 SOUTH NEIL STREET
SUITE 100
CHAMPAIGN, IL 61820
PHONE: 217.373.8900
FAX: 217.373.8923