

SEE THE TRAFFIC SIGNAL PLANS FOR TRAFFIC SIGNAL REMOVAL ITEMS.


SEE THE ROADWAY LIGHTING PLANS FOR ROADWAY LIGHTING REMOVAL ITEMS.

SEE DRAINAGE PLANS FOR ADDITIONAL INFORMATION.

THE LIMITS OF SIDEWALK REMOVAL AND BRICK PAVER REMOVAL ARE NOT SHOWN FOR THE REMOVAL AND/OR INSTALLATION OF LIGHT POLES, JUNCTION BOXES, OR PARKING METERS. QUANTITIES FOR THIS WORK ARE INCLUDED ON THE PLANS.

THE STRUCTURE INFORMATION SHOWN IN ITALICS IS ALSO SHOWN ON THE DRAINAGE PLANS. THE SCHEDULE OF QUANTITIES FOR THESE ITEMS IS SHOWN ON THE REMOVAL PLANS.

SEE SHEET 11 FOR REMOVAL NOTES

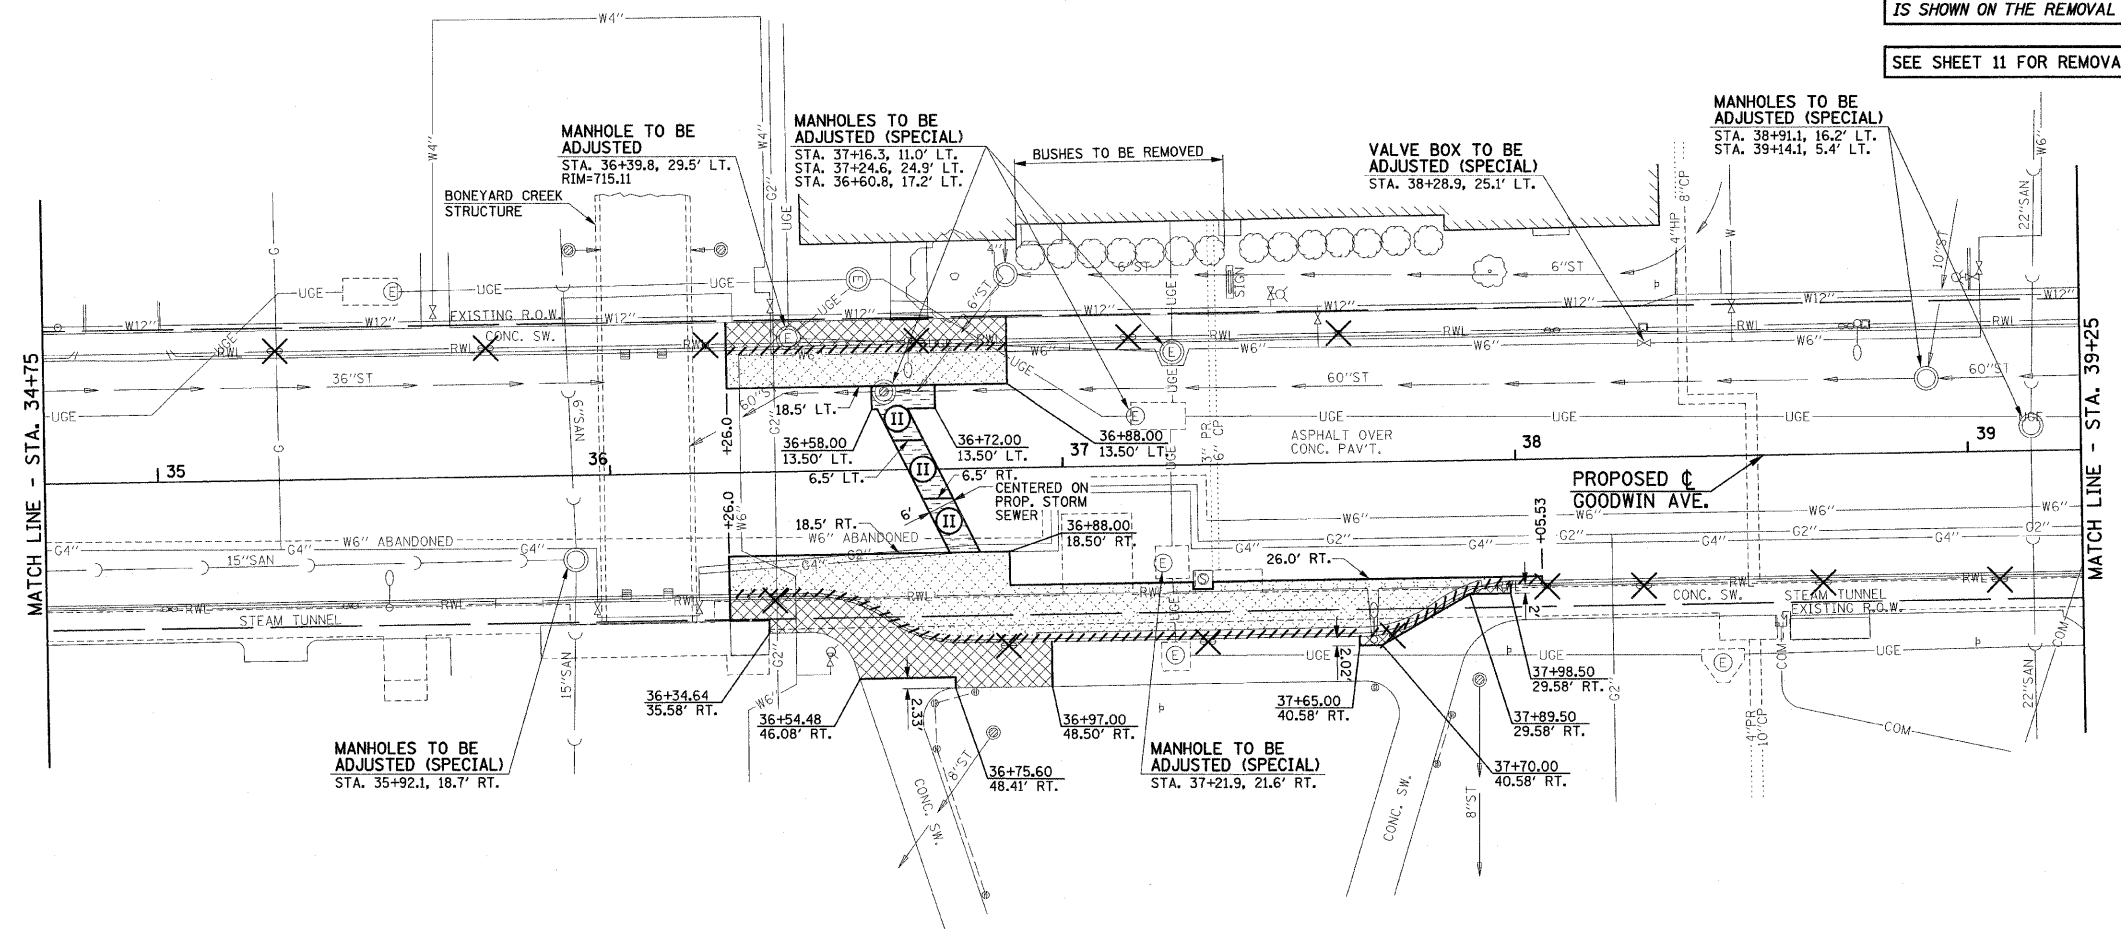

STRUCTURE ADJUSTMENT AND REMOVAL PAY ITEMS - 34+75 TO 39+25

CODE NO.	DESCRIPTION	UNIT	QUAN.
60255500	MANHOLES TO BE ADJUSTED	EACH	1
60255600	MANHOLES TO BE ADJUSTED (SPECIAL)	EACH	7
60266610	VALVE BOXES TO BE ADJUSTED (SPECIAL)	EACH	1

PARKING METER POSTS TO BE REMOVED (20036700)

STATION	TO STATION	EACH
35+26 LT.	37+61 LT.	6
36+36 RT.	39+07 RT.	8
		SHEET TOTAL
		14

SIDEWALK REMOVAL (44000600)

STATION	TO STATION	SQ FT
36+26 LT.	36+88 LT.	340.8
36+26 RT.	37+98.5 RT.	731.2
ROADWAY LIGHTING		340.0
PARKING METER POSTS		100.0
		SHEET TOTAL
		1512.0

CLASS B PATCHES, TYPE II, 8" (44200934)

STATION	TO STATION	SQ YD
36+58.0 LT.	36+72.0 LT.	13.0
36+62.7 LT.	36+75.7 RT.	9.7
36+69.0 RT.	36+81.5 RT.	8.9
		SHEET TOTAL
		31.6

PAVEMENT REMOVAL (44000100)

STATION	TO STATION	SQ YD
36+26 LT.	36+88 LT.	52.6
36+26 RT.	38+05.5 RT.	194.3
		SHEET TOTAL
		246.9

COMBINATION CURB AND GUTTER REMOVAL (44000500)

STATION	TO STATION	FOOT
36+26 LT.	36+88 LT.	62.0
36+26 RT.	38+05.5 RT.	184.2
		SHEET TOTAL
		246.2

FILE NAME = p:\u0070052\plans\sheets\10-Removal.dgn
 PLOT DATE = 1/12/2009 7:46:17 PM

DESIGNED - JAJ
 DRAWN - DLM
 CHECKED - RLH
 DATE - 01-2009

REVISED -
 REVISED -
 REVISED -
 REVISED -

STATE OF ILLINOIS
 DEPARTMENT OF TRANSPORTATION

REMOVALS/RELOCATIONS PLAN

SCALE: 1"=20' SHEET NO. 17 OF 75 SHEETS STA. 34+75 TO STA. 39+25

F.A.U. RTE.	SECTION	COUNTY	TOTAL SHEETS	SHEET NO.
7175	07-00456-00-RS	CHAMPAIGN	75	17
GOODWIN AVENUE		CONTRACT NO. 91392		
FED. ROAD DIST. NO.		ILLINOIS FED. AID PROJECT		