 


STORM AND SANITARY SEWER PIPE SCHEDULE - OREGON ST.			
CODE NO.	DESCRIPTION	UNIT	QVAN.
54248515	CONCRETE COLLAR	EACH	2
550A0050	STORM SEWERS, CLASS A, TYPE 1 12"	FOOT	13
59300100	CONTROLLED LOW-STRENGTH MATERIAL	CU YD	25.9
X0321905	STORM SEWERS, TYPE 1, WATER MAIN QUALITY PIPE, 12"	FOOT	106
X0321908	STORM SEWERS, TYPE 2, WATER MAIN QUALITY PIPE, 15"	FOOT	4


STORM AND SANITARY SEWER STRUCTURE SCHEDULE - OREGON ST.			
CODE NO.	DESCRIPTION	UNIT	QVAN.
60224600	RESTRICTED DEPTH MANHOLES, 4'-DIAMETER, TYPE 1 FRAME, CLOSED LID	EACH	1
60236800	INLETS, TYPE A, TYPE 11 FRAME AND GRATE	EACH	2
	RESTRICTED DEPTH INLET TYPE B, TYPE 11 FRAME AND GRATE	EACH	1

STRUCTURE LEGEND

- TA - TYPE A INLET
- TB - TYPE B INLET
- TA (4' DIA.) - TYPE A MANHOLE (DIA. SPECIFIED)
- R.D. - RESTRICTED DEPTH
- ◊ RIM - CENTER OF 2' OPENING
- RIM - TOP OF FRAME ELEVATION
- T/F.S.T. - TOP OF FLAT SLAB TOP
- 1C - TYPE 1 FRAME AND CLOSED LID
- 8 - TYPE 8 GRATE
- 11 - TYPE 11 FRAME AND GRATE



THE STRUCTURE INFORMATION SHOWN IN ITALICS IS ALSO SHOWN ON THE REMOVAL PLANS. THE SCHEDULE OF QUANTITIES FOR THESE ITEMS IS SHOWN ON THE REMOVAL PLANS.

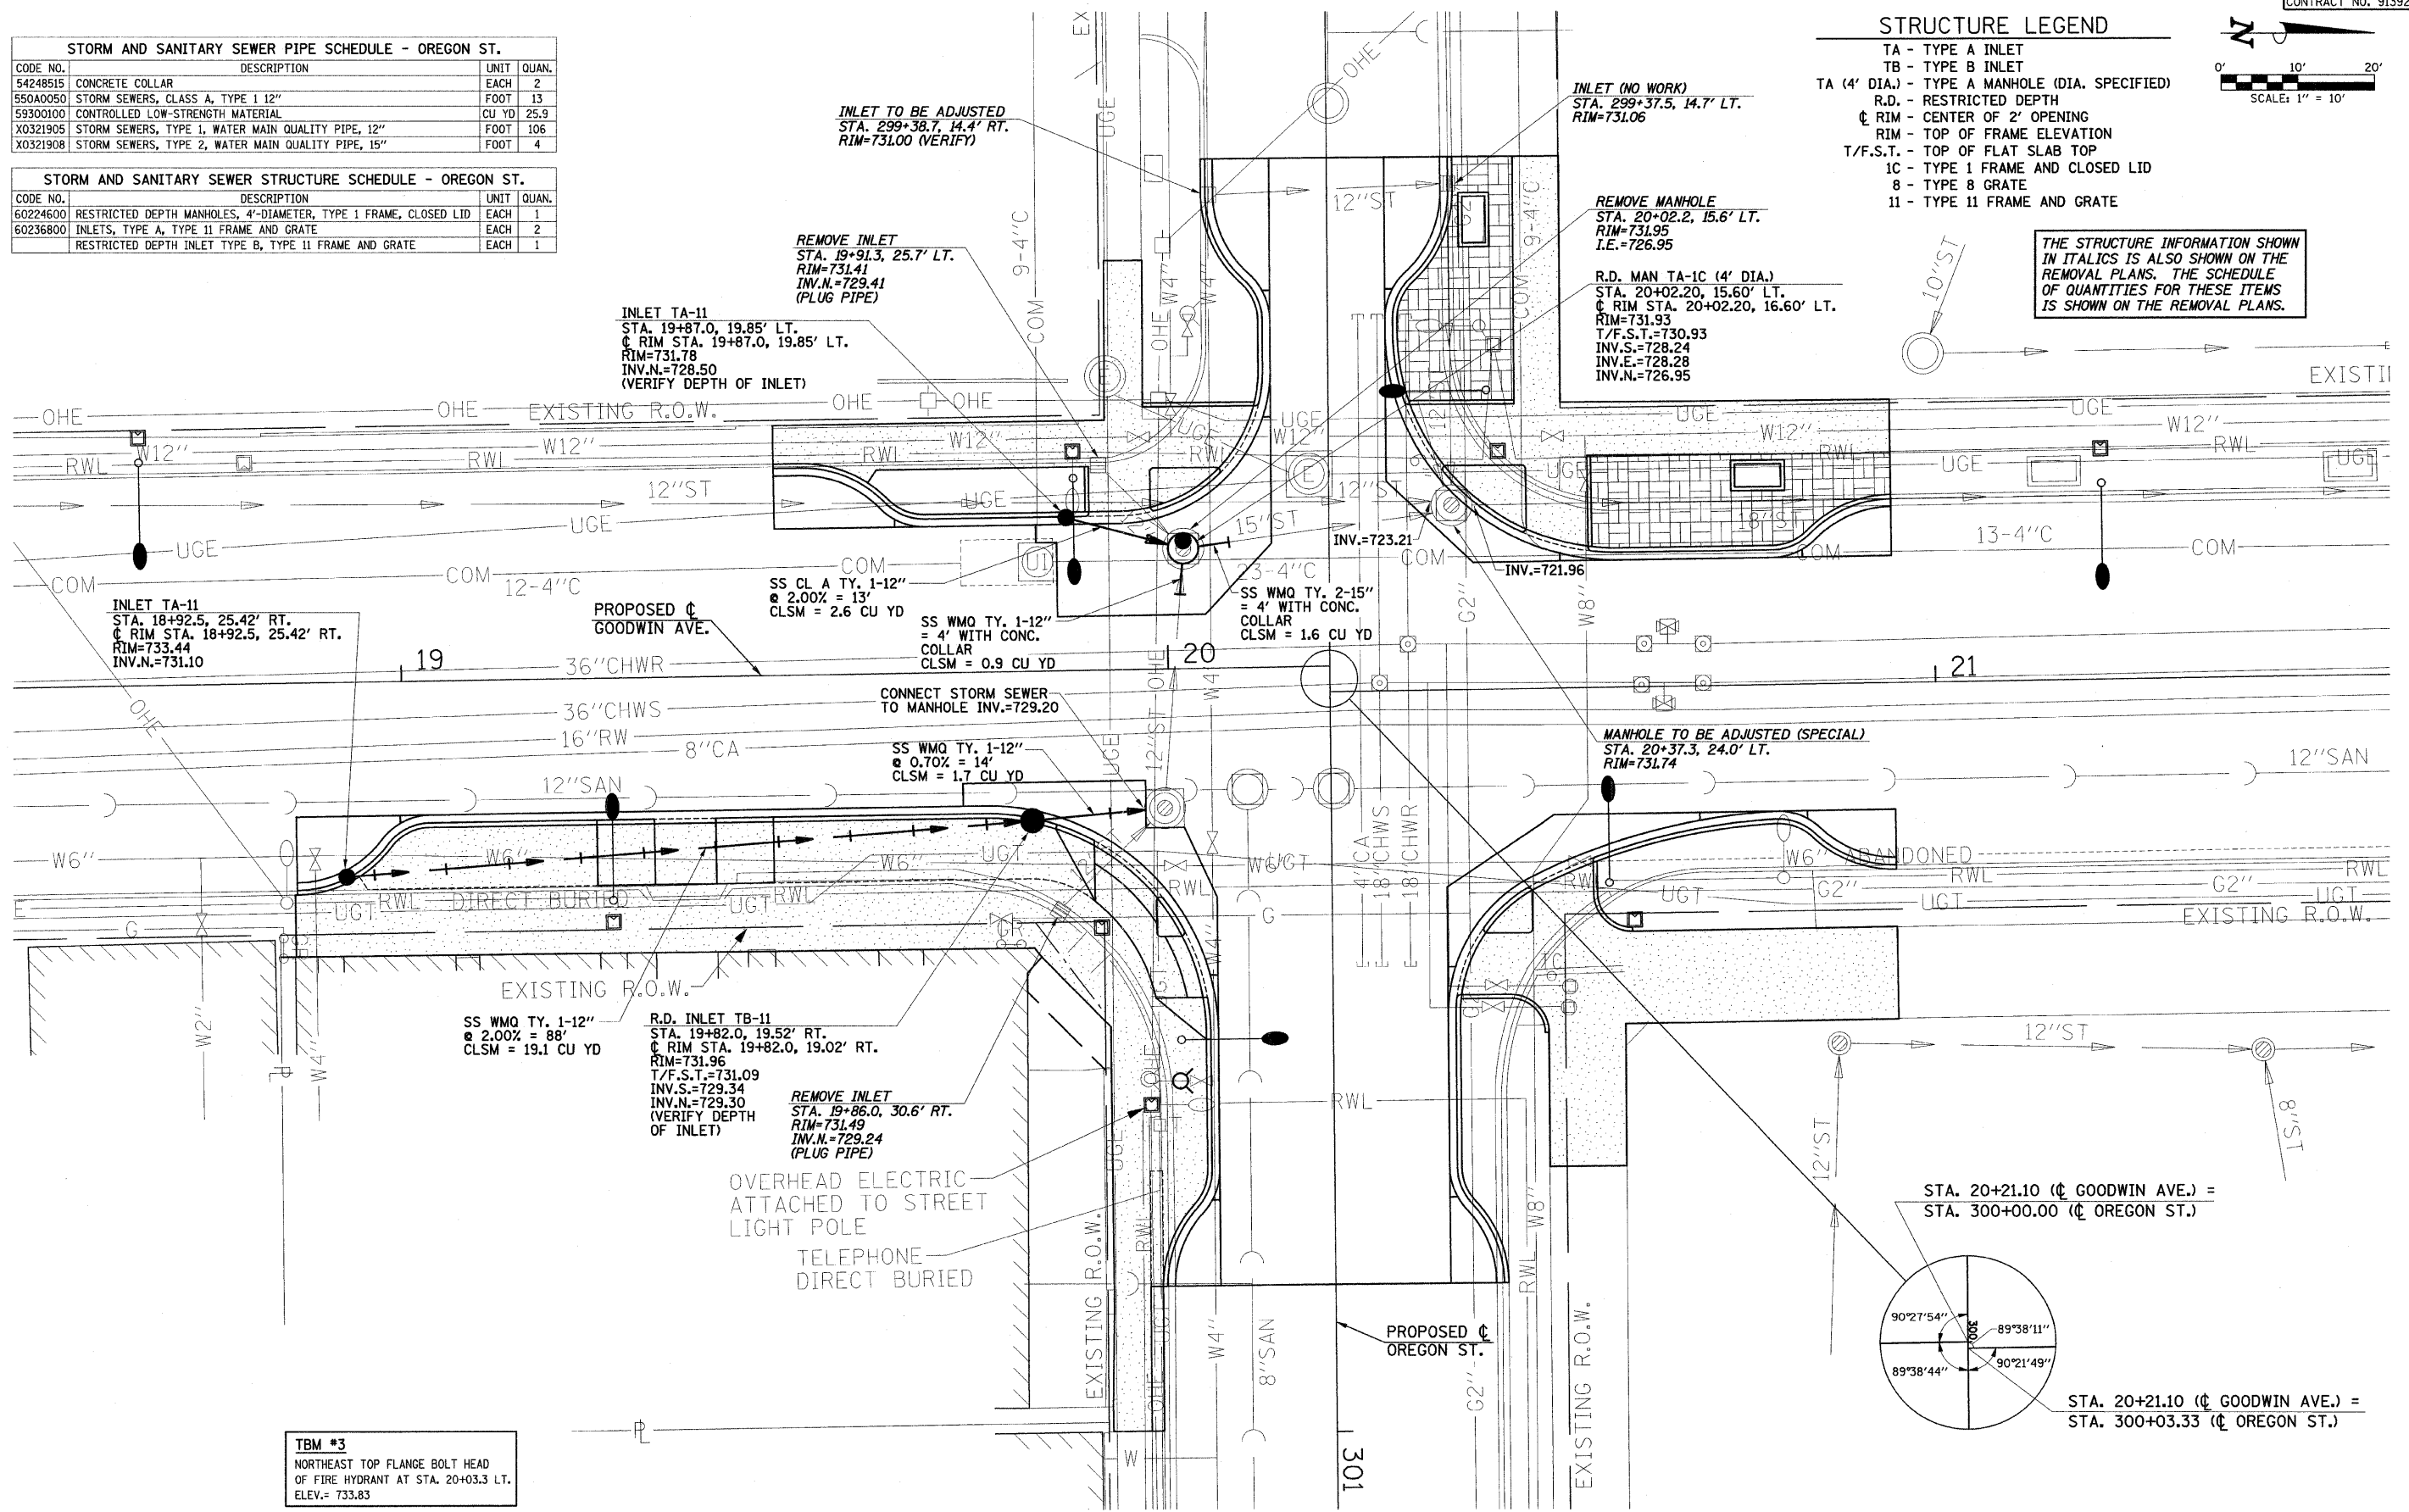

TBM #3
NORTHEAST TOP FLANGE BOLT HEAD
OF FIRE HYDRANT AT STA. 20+03.3 LT.
ELEV.= 733.83

FILE NAME = p:\u0070052\plans\sheets\27-Drainage.dgn	DESIGNED - RLH	REVISED -
PLOT DATE = 1/12/2009 7:46:32 PM	DRAWN - JRM	REVISED -
	CHECKED - JAJ	REVISED -
	DATE - 01-2009	REVISED -

STATE OF ILLINOIS DEPARTMENT OF TRANSPORTATION	DESIGNED - RLH	REVISED -
	DRAWN - JRM	REVISED -
	CHECKED - JAJ	REVISED -
	DATE - 01-2009	REVISED -

STATE OF ILLINOIS
DEPARTMENT OF TRANSPORTATION

DRAINAGE PLAN

SCALE: 1"=10' SHEET NO. 28 OF 75 SHEETS STA. TO STA.

F.A.U. RTE.	SECTION	COUNTY	TOTAL SHEETS	SHEET NO.
7175	07-00456-00-RS	CHAMPAIGN	75	28
GOODWIN AVENUE		CONTRACT NO. 91392		
FED. ROAD DIST. NO.		ILLINOIS FED. AID PROJECT		