

**STORM AND SANITARY SEWER PIPE SCHEDULE - SPRINGFIELD AVE.**


CODE NO.	DESCRIPTION	UNIT	QUAN.
54248515	CONCRETE COLLAR	EACH	4
550A0050	STORM SEWERS, CLASS A, TYPE 1 12"	FOOT	38
550A0330	STORM SEWERS, CLASS A, TYPE 2 10"	FOOT	6
59300100	CONTROLLED LOW-STRENGTH MATERIAL	CU YD	24.7
X0321905	STORM SEWERS, TYPE 1, WATER MAIN QUALITY PIPE, 12"	FOOT	40
X0321906	STORM SEWERS, TYPE 1, WATER MAIN QUALITY PIPE, 15"	FOOT	12

**STORM AND SANITARY SEWER STRUCTURE SCHEDULE - SPRINGFIELD AVE.**


CODE NO.	DESCRIPTION	UNIT	QUAN.
60224600	RESTRICTED DEPTH MANHOLES, 4'-DIAMETER, TYPE 1 FRAME, CLOSED LID	EACH	1
60236200	INLETS, TYPE A, TYPE 8 GRATE	EACH	1
60236800	INLETS, TYPE A, TYPE 11 FRAME AND GRATE	EACH	3
XX004735	RESTRICTED DEPTH INLET TYPE B, TYPE 1 FRAME, CLOSED LID	EACH	1
	RESTRICTED DEPTH INLET TYPE B, TYPE 11 FRAME AND GRATE	EACH	2

**STRUCTURE LEGEND**

- TA - TYPE A INLET
- TB - TYPE B INLET
- TA (4' DIA.) - TYPE A MANHOLE (DIA. SPECIFIED)
- R.D. - RESTRICTED DEPTH
- ⊕ RIM - CENTER OF 2' OPENING
- RIM - TOP OF FRAME ELEVATION
- T/F.S.T. - TOP OF FLAT SLAB TOP
- 1C - TYPE 1 FRAME AND CLOSED LID
- 8 - TYPE 8 GRATE
- 11 - TYPE 11 FRAME AND GRATE

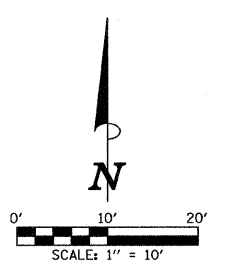

THE STRUCTURE INFORMATION SHOWN IN ITALICS IS ALSO SHOWN ON THE REMOVAL PLANS. THE SCHEDULE OF QUANTITIES FOR THESE ITEMS IS SHOWN ON THE REMOVAL PLANS.

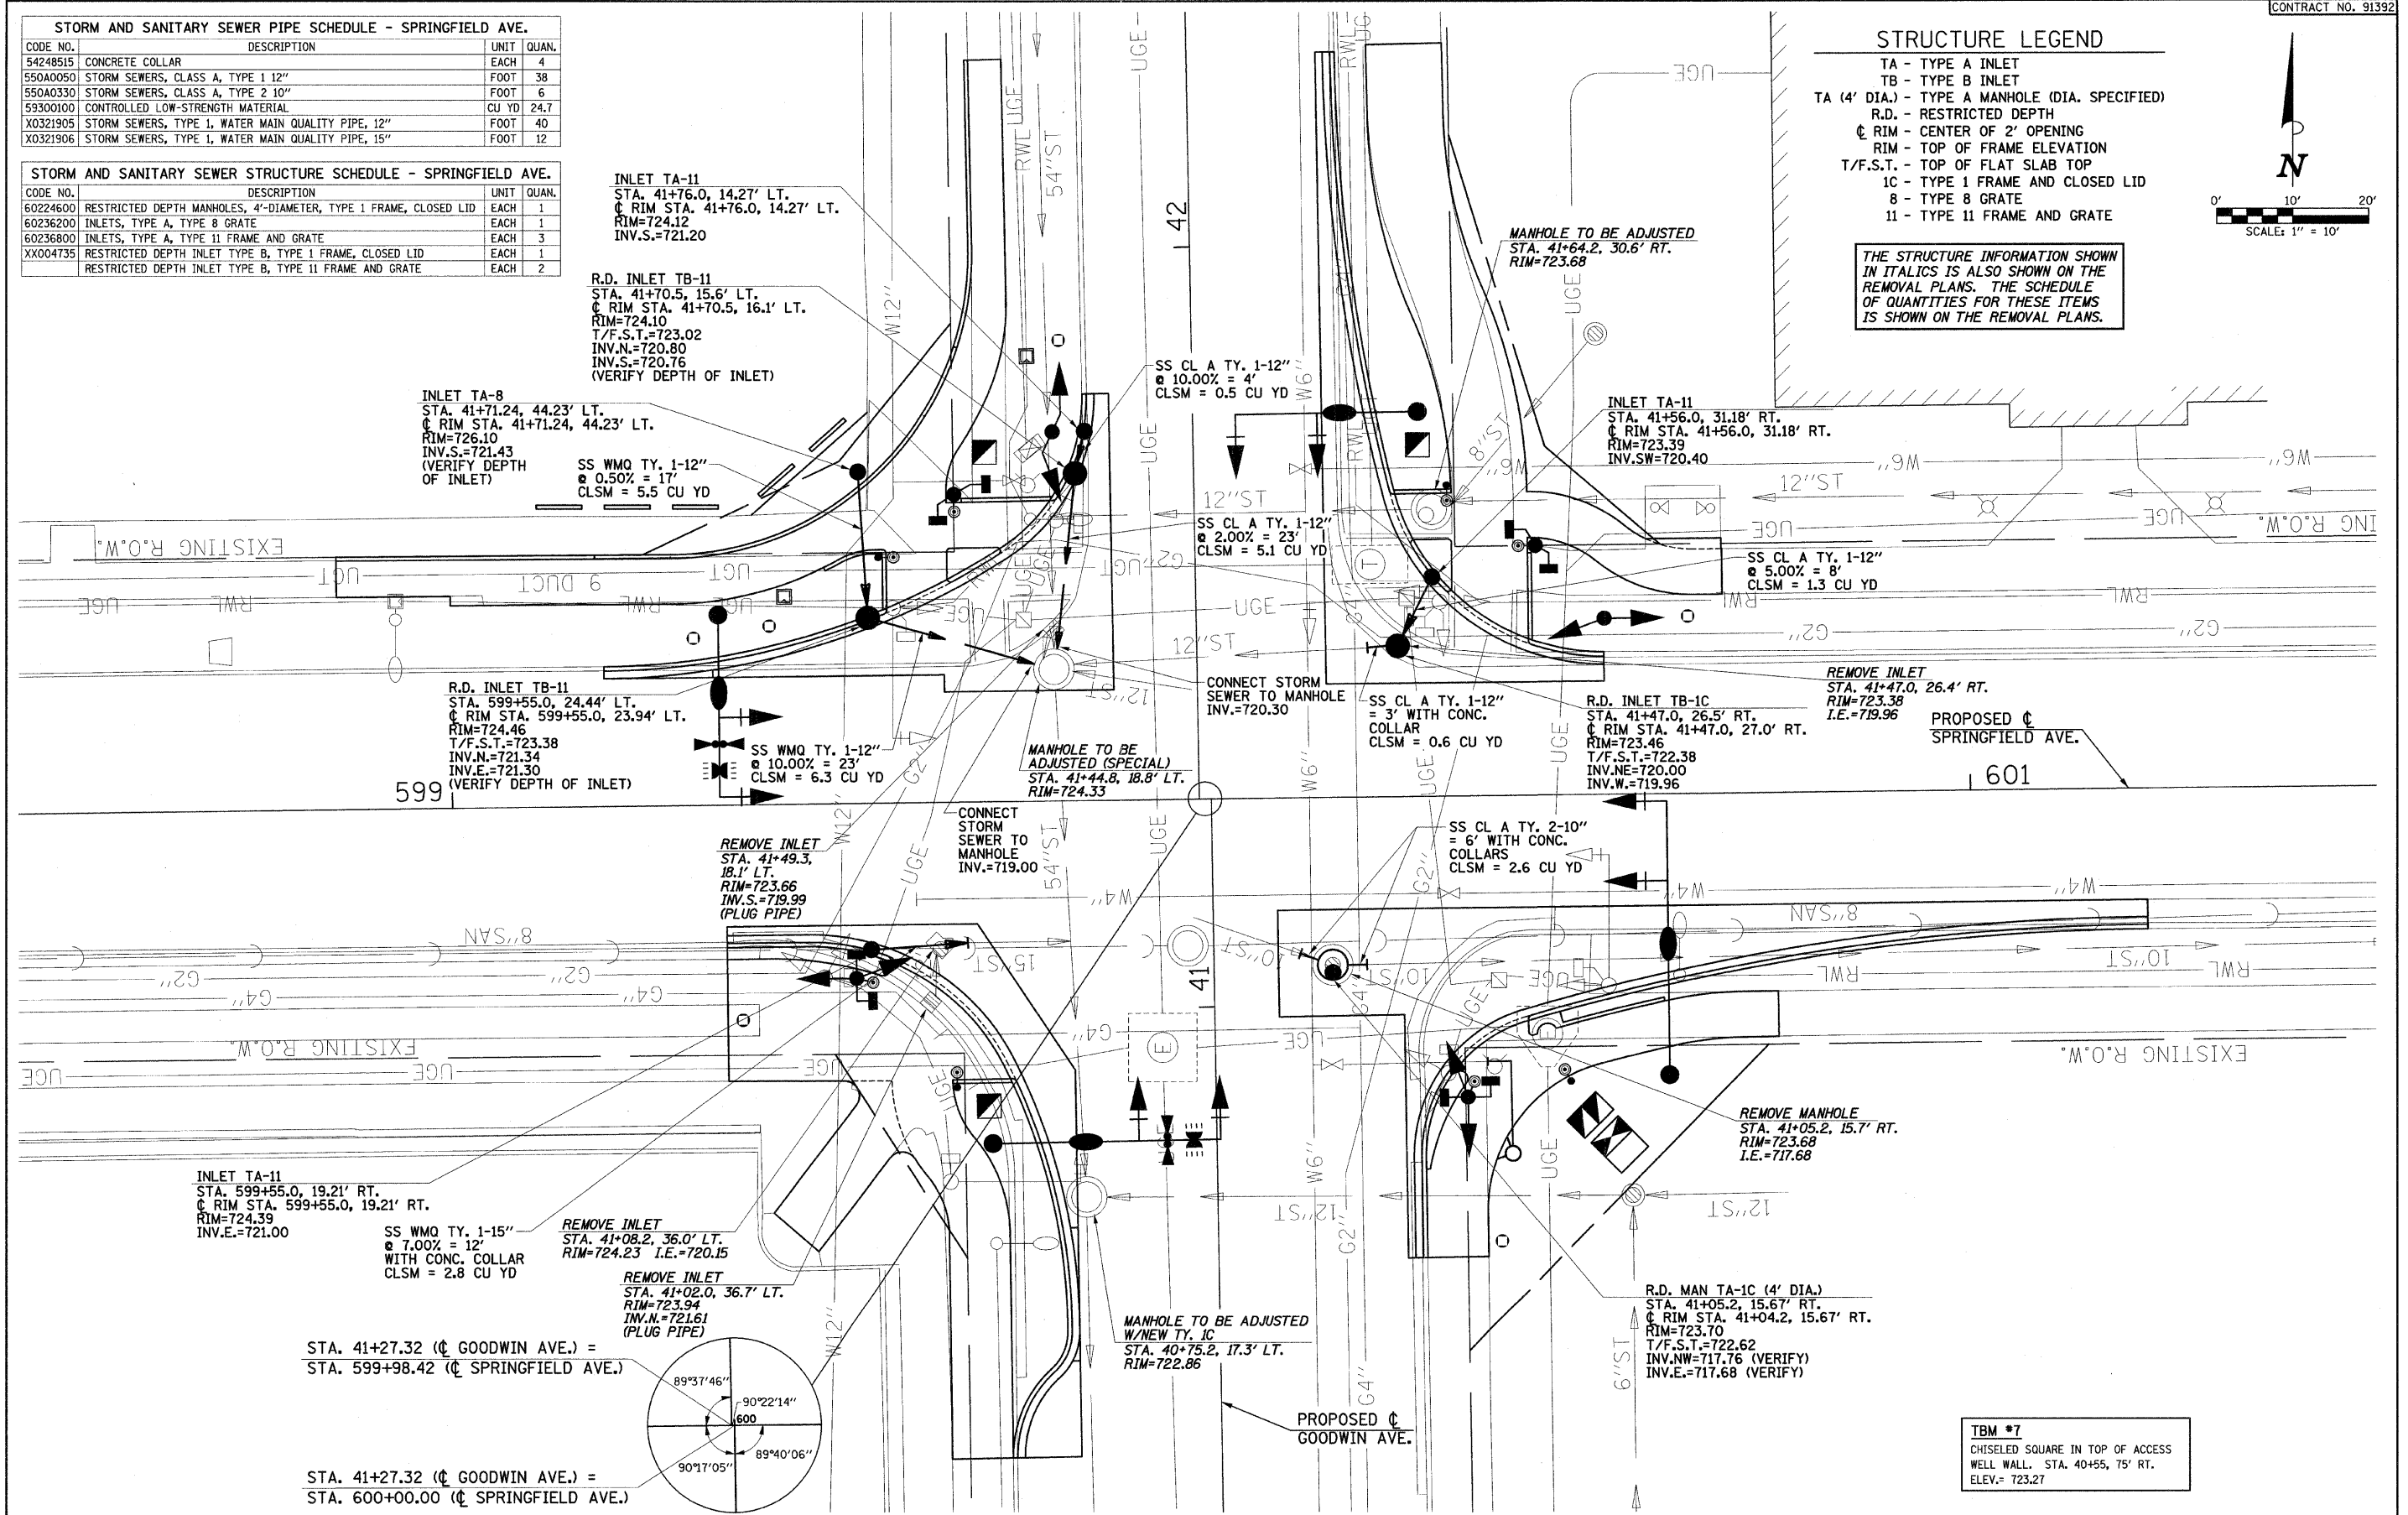

FILE NAME = p:\u0070052\plans\sheets\27-Drainage.dgn  
 PLOT DATE = 1/12/2009 7:46:36 PM

DESIGNED - RLH	REVISED -
DRAWN - JRM	REVISED -
CHECKED - JAJ	REVISED -
DATE - 01-2009	REVISED -

STATE OF ILLINOIS  
 DEPARTMENT OF TRANSPORTATION

**DRAINAGE PLAN**  
 SCALE: 1"=10' SHEET NO. 33 OF 75 SHEETS STA. TO STA.

F.A.U. RTE.	SECTION	COUNTY	TOTAL SHEETS	SHEET NO.
7175	07-00456-00-RS	CHAMPAIGN	75	33
GOODWIN AVENUE		CONTRACT NO. 91392		
FED. ROAD DIST. NO.		ILLINOIS FED. AID PROJECT		

**TBM #7**  
 CHISELED SQUARE IN TOP OF ACCESS WELL WALL. STA. 40+55, 75' RT. ELEV.= 723.27