



**STRUCTURE LEGEND**

- TA - TYPE A INLET
- TB - TYPE B INLET
- TA (4' DIA.) - TYPE A MANHOLE (DIA. SPECIFIED)
- R.D. - RESTRICTED DEPTH
- ⊕ - RIM - CENTER OF 2' OPENING
- RIM - TOP OF FRAME ELEVATION
- T/F.S.T. - TOP OF FLAT SLAB TOP
- 1C - TYPE 1 FRAME AND CLOSED LID
- 8 - TYPE 8 GRATE
- 11 - TYPE 11 FRAME AND GRATE

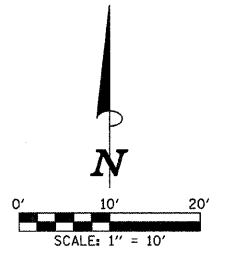

THE STRUCTURE INFORMATION SHOWN IN ITALICS IS ALSO SHOWN ON THE REMOVAL PLANS. THE SCHEDULE OF QUANTITIES FOR THESE ITEMS IS SHOWN ON THE REMOVAL PLANS.

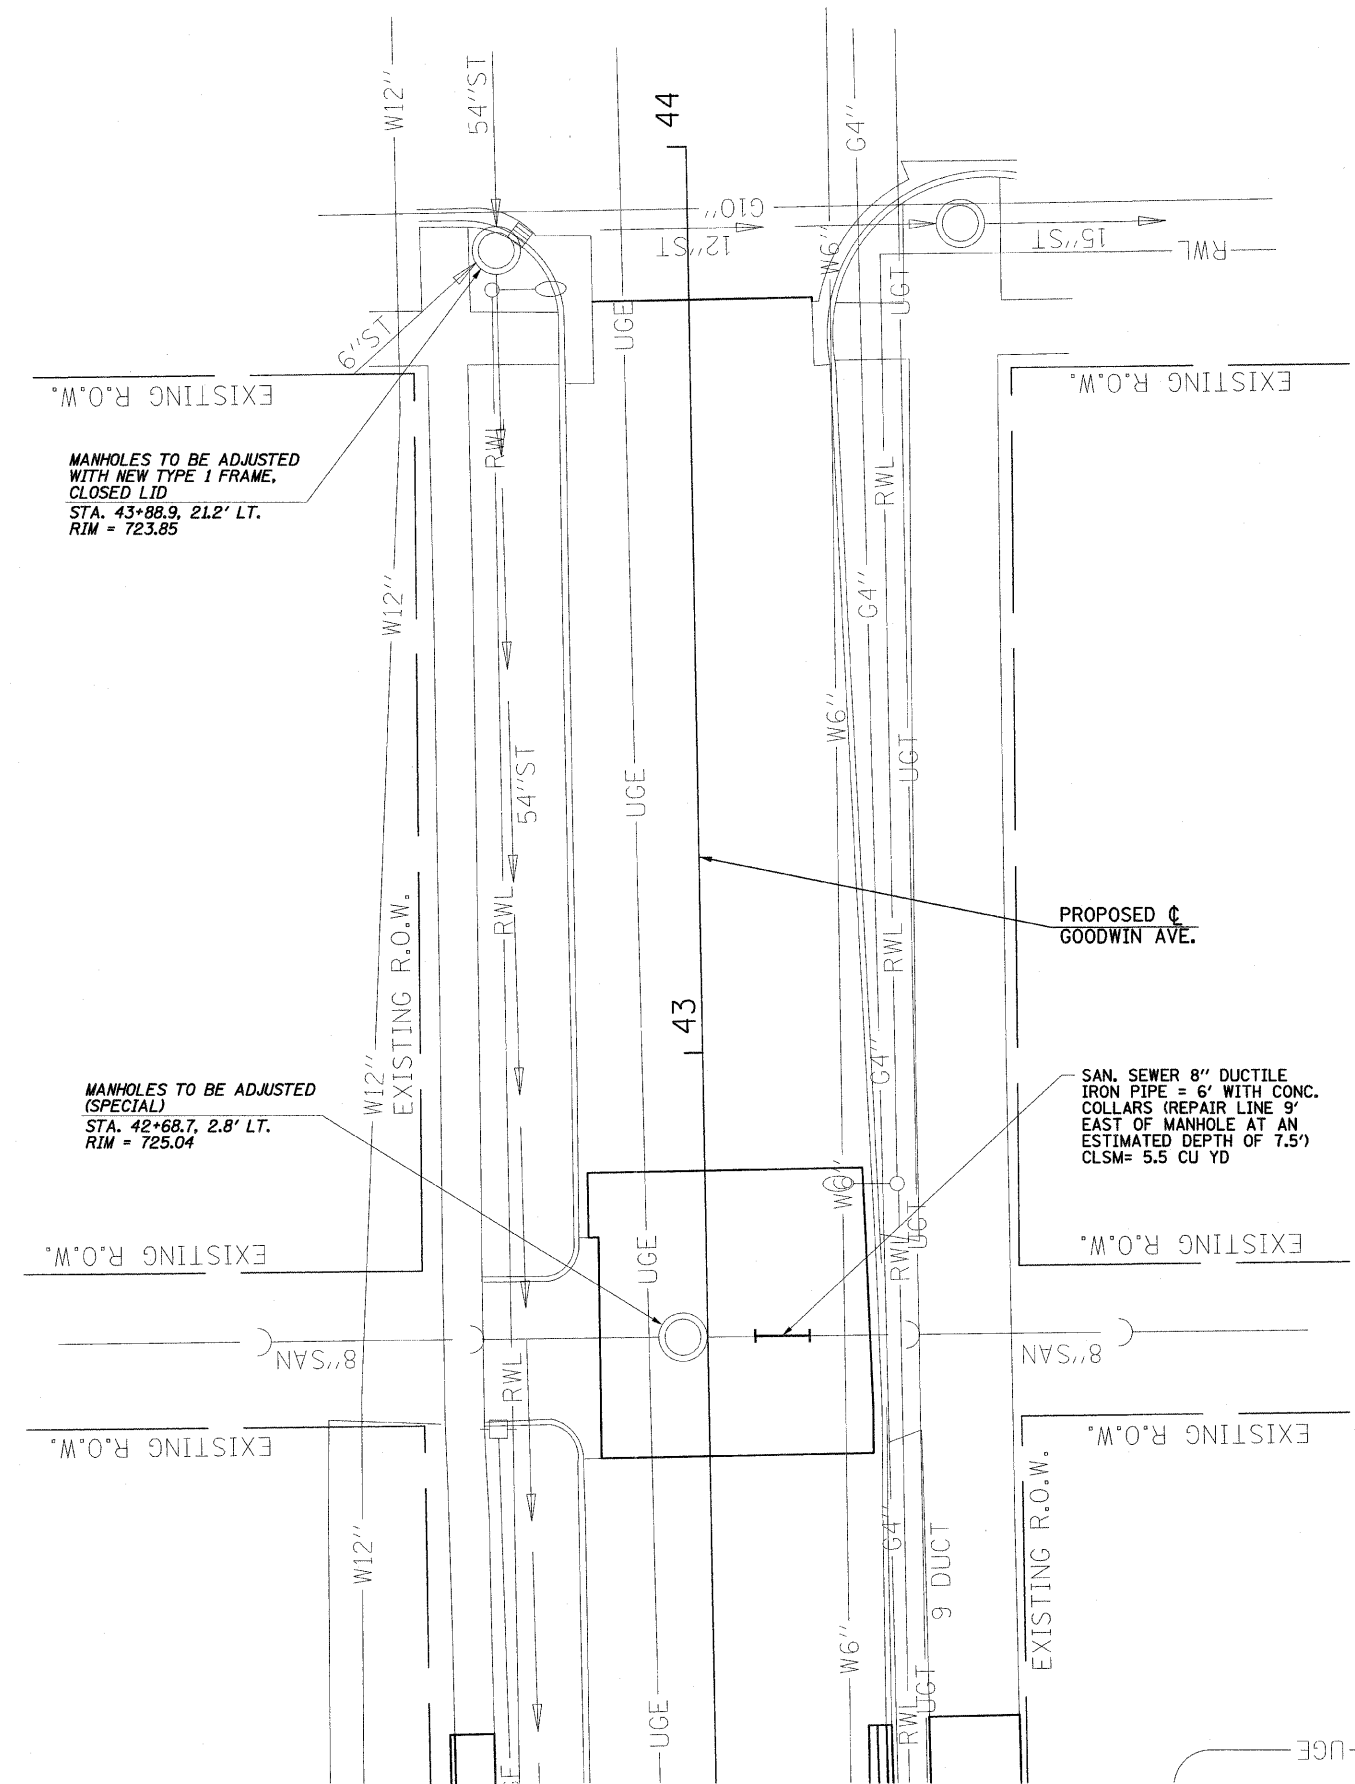

MANHOLES TO BE ADJUSTED WITH NEW TYPE 1 FRAME, CLOSED LID  
 STA. 43+88.9, 21.2' LT.  
 RIM = 723.85

MANHOLES TO BE ADJUSTED (SPECIAL)  
 STA. 42+68.7, 2.8' LT.  
 RIM = 725.04

**STORM AND SANITARY SEWER PIPE SCHEDULE - MIDBLOCK**

CODE NO.	DESCRIPTION	UNIT	QUAN.
54248515	CONCRETE COLLAR	EACH	2
59300100	CONTROLLED LOW-STRENGTH MATERIAL	CU YD	5.5
	SANITARY SEWER, DUCTILE IRON, 8"	FOOT	6

FILE NAME = p:\u0070052\plans\sheets\27-Drainage.dgn  
 PLOT DATE = 1/12/2009 7:46:37 PM

DESIGNED - RLH	REVISED -
DRAWN - JRM	REVISED -
CHECKED - JAJ	REVISED -
DATE - 01-2009	REVISED -

STATE OF ILLINOIS  
 DEPARTMENT OF TRANSPORTATION

**DRAINAGE PLAN**  
 SCALE: 1"=10' SHEET NO. 34 OF 75 SHEETS STA. TO STA.

F.A.J. RTE.	SECTION	COUNTY	TOTAL SHEETS	SHEET NO.
7175	07-00456-00-RS	CHAMPAIGN	75	34
GOODWIN AVENUE		CONTRACT NO. 91392		
FED. ROAD DIST. NO.		ILLINOIS FED. AID PROJECT		